



--

REVISION TABLE			
NUMBER	DATE	REVISED BY	DESCRIPTION
A	02/04/15	DGR	FOR REVIEW

"3D PERSPECTIVE"

THANK YOU FOR YOUR BUSINESS
MAY GOD BLESS YOU
"HIS REST MATTHEW 11:28-30"

--

DRAWINGS PROVIDED BY:
RATLIFF CONSTRUCTION
4012 SHERRY STREET
SULPHUR, LOUISIANA 70665
(337) 375-2401

DATE:


7/30/2019

SCALE:

1/4"=1'-0"

SHEET:

A.1

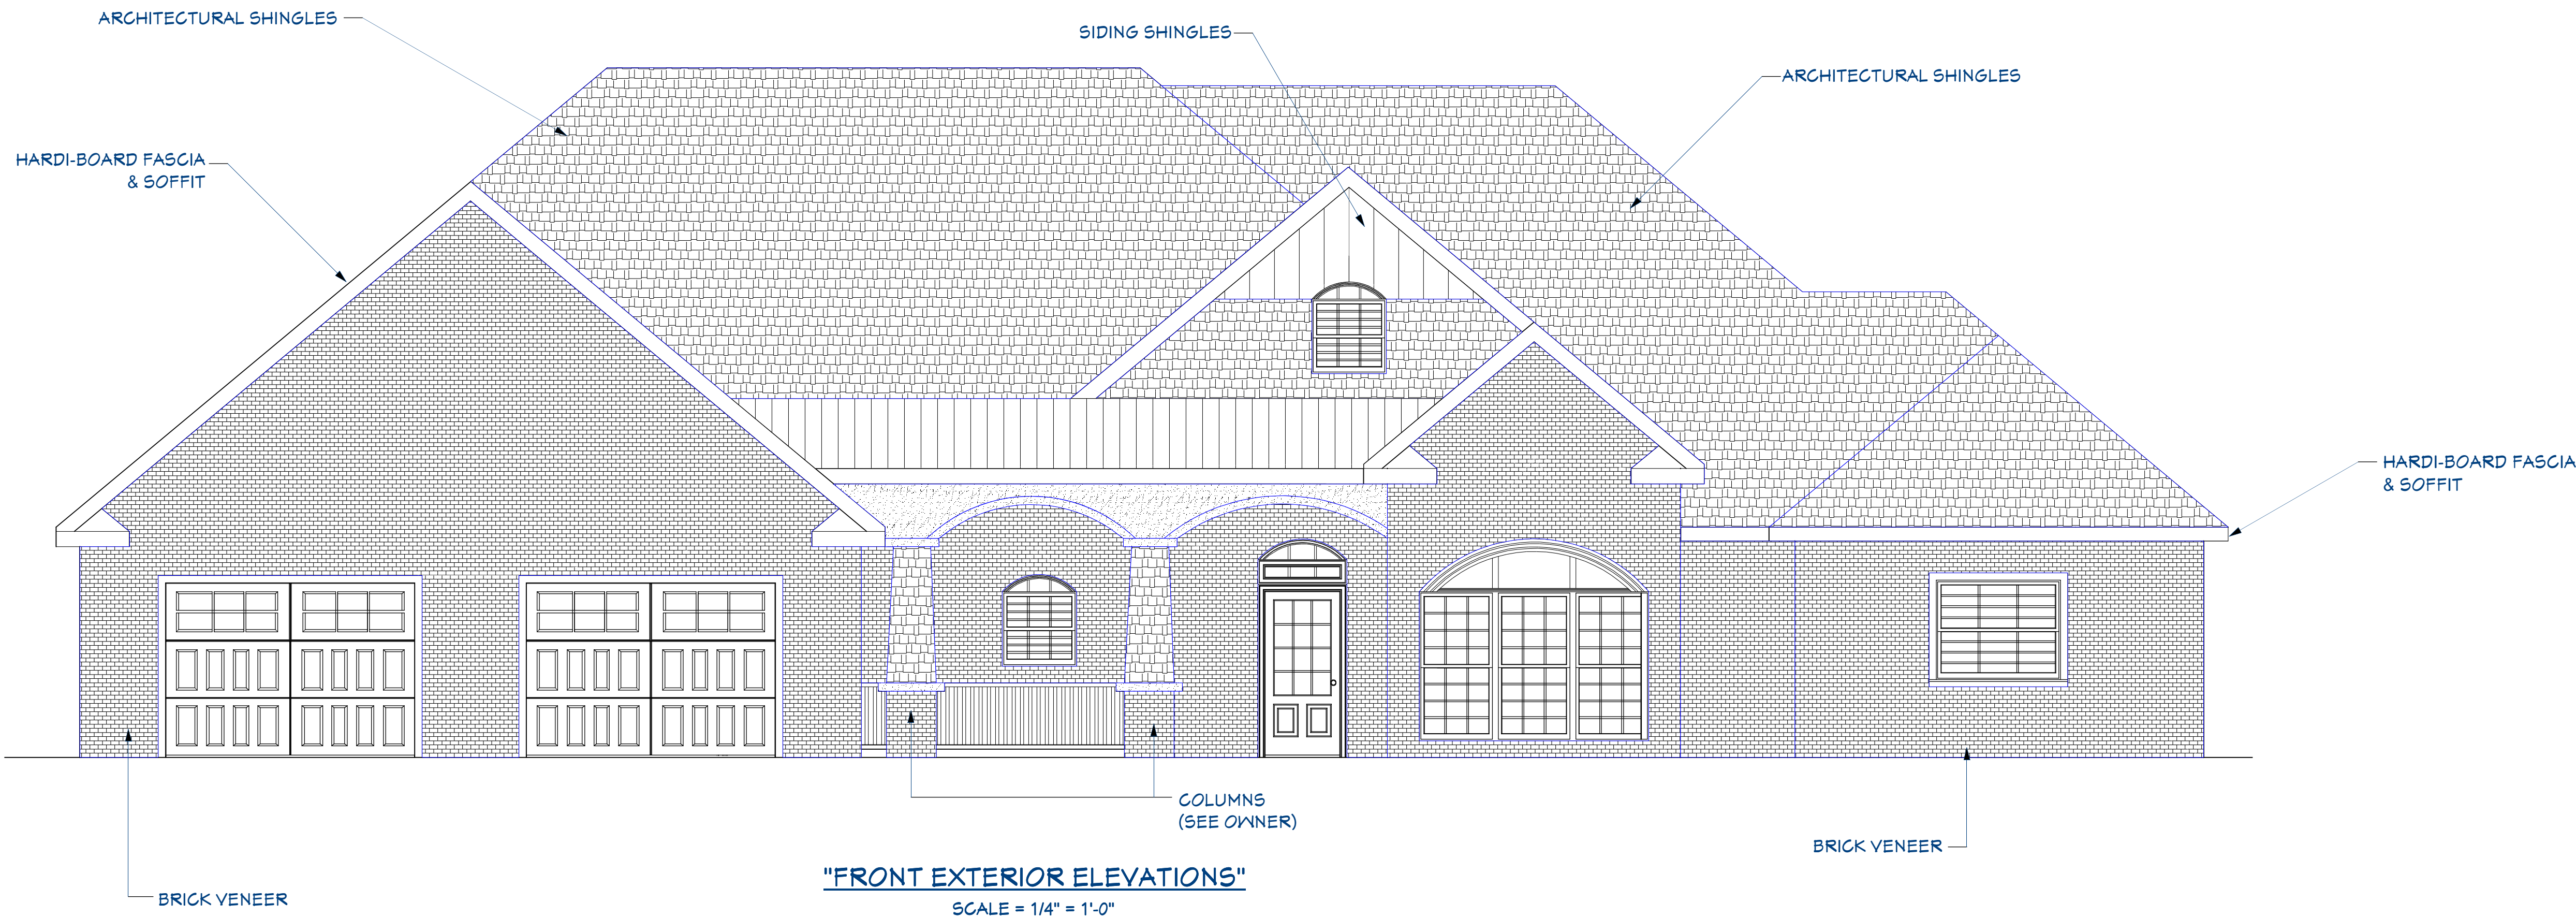

The Owner and Contractor are required to review and verify the design and dimensions, reflected on the plans and/or documents, before purchasing materials or commencement of construction. I hereby do not warrant these plans and/or documents for Engineering or Architectural applications and any use thereof is strictly prohibited, responsibility of those purposes is assumed by the Owner and/or Contractor of the facility. The drawing and dimensions shown hereon are for visual purposes only and may not be to any scale.

Signature/Date: _____

REVISION TABLE			
NUMBER	DATE	REVISED BY	DESCRIPTION FOR REVIEW
A	02/04/15	DGR	

"EXTERIOR ELEVATIONS"

THANK YOU FOR YOUR BUSINESS
MAY GOD BLESS YOU
"HIS REST MATTHEW 11:28-30"

DRAWINGS PROVIDED BY:
RATLIFF CONSTRUCTION
4012 SHERRY STREET
SULPHUR, LOUISIANA 70665
(337) 375-2401

DATE:


7/30/2019

SCALE:

1/4"=1'-0"


SHEET:

A.2

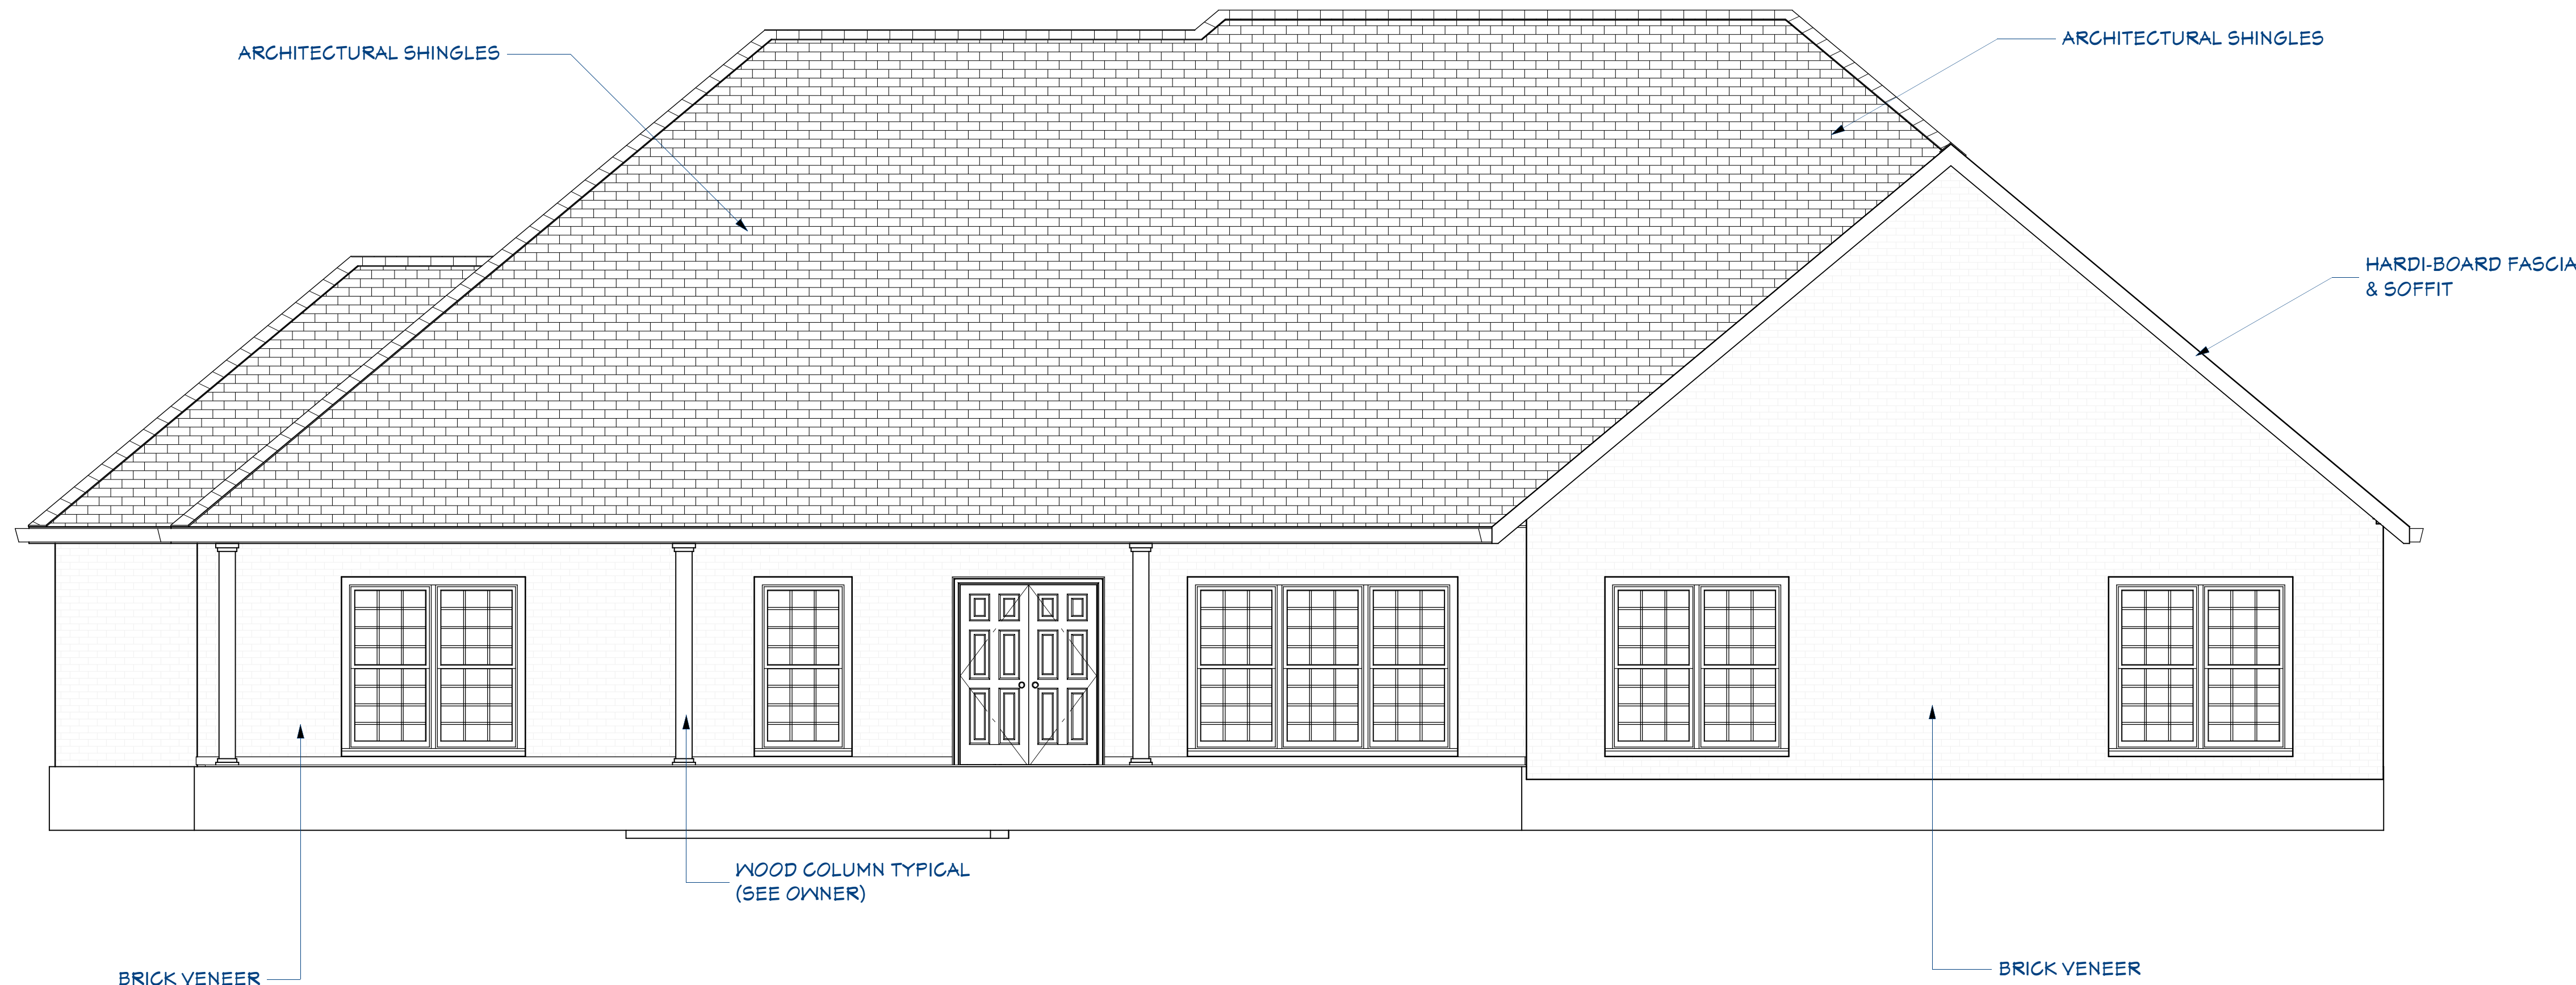

"REAR EXTERIOR ELEVATIONS"

SCALE = 1/4" = 1'-0"

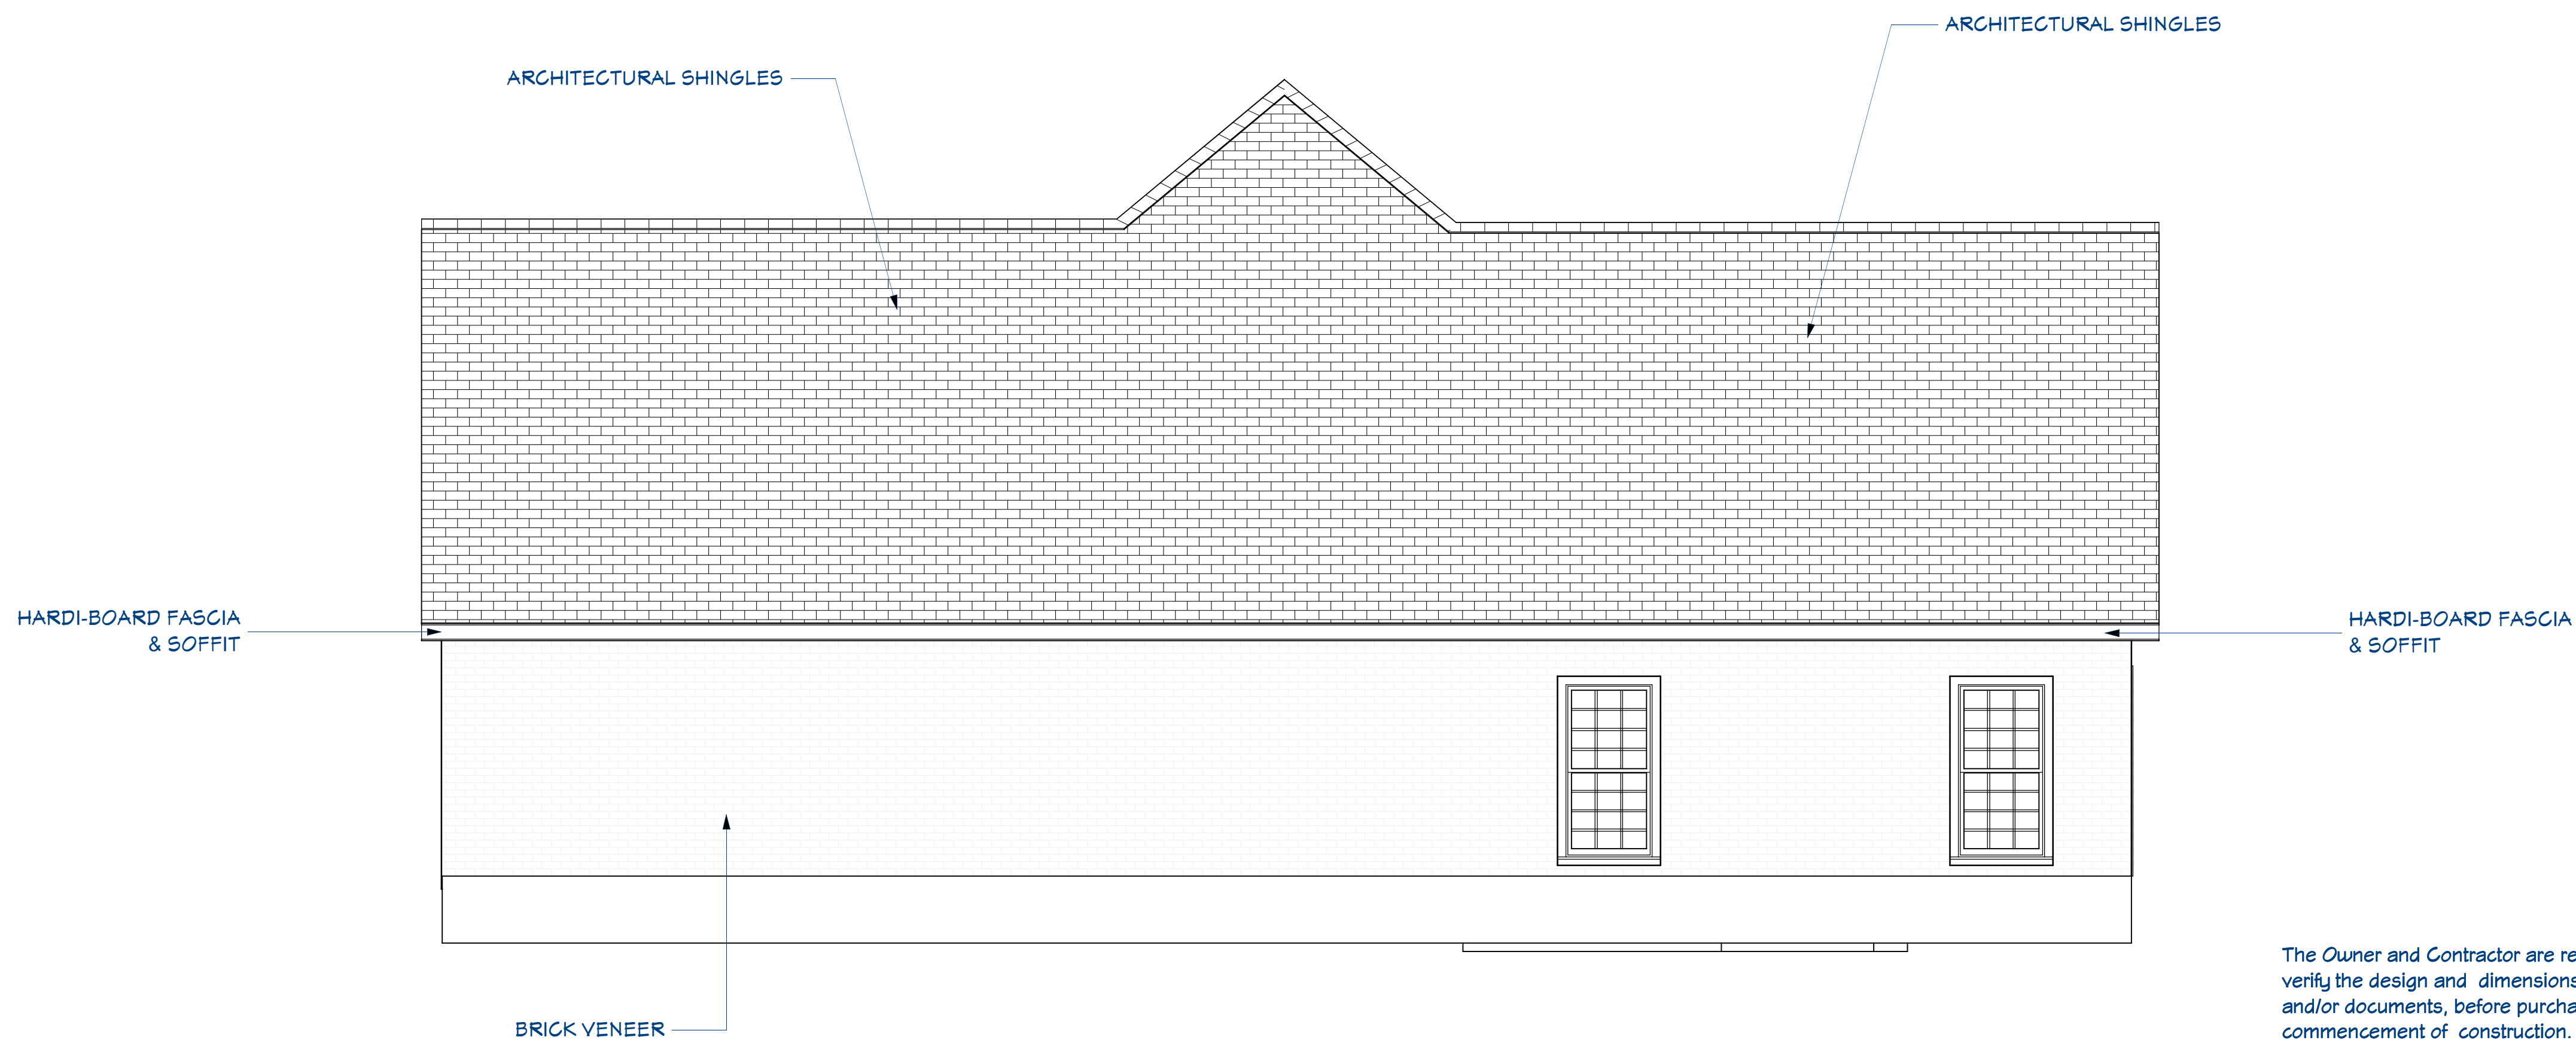

"LEFT-SIDE EXTERIOR ELEVATIONS"

SCALE = 1/4" = 1'-0"

The Owner and Contractor are required to review and verify the design and dimensions, reflected on the plans and/or documents, before purchasing materials or commencement of construction. I hereby do not warrant these plans and/or documents for Engineering or Architectural applications and any use thereof is strictly prohibited, responsibility of those purposes is assumed by the Owner and/or Contractor of the facility. The drawing and dimensions shown hereon are for visual purposes only and may not be to any scale.

Signature/Date:

REVISION TABLE			
NUMBER	DATE	REVISED BY	DESCRIPTION
A	02/04/15	DGR	FOR REVIEW

"EXTERIOR ELEVATIONS"

THANK YOU FOR YOUR BUSINESS
MAY GOD BLESS YOU
"HIS REST MATTHEW 11:28-30"

DRAWINGS PROVIDED BY:

RATLIFF CONSTRUCTION
4012 SHERRY STREET
SULPHUR, LOUISIANA 70665
(337) 375-2401

DATE:

7/30/2019

SCALE:

1/4"=1'-0"

SHEET:

A.3

A.4

ROOM FINISH SCHEDULE					
ROOM NAME	AREA (SQ FT)	CEILING HEIGHT	WALL MATERIAL	FLOOR FINISH	CEILING FINISH
BACK PORCH	424	9'-0"	DRYWALL	CONCRETE	HARDI-BOARD
MASTER TOILET AREA	16	9'-0"	DRYWALL	STAINED CONCRETE	DRYWALL
BATH 1	61	9'-0"	DRYWALL	STAINED CONCRETE	DRYWALL
BATH 2	60	9'-0"	DRYWALL	STAINED CONCRETE	DRYWALL
BATH 3	41	9'-0"	DRYWALL	STAINED CONCRETE	DRYWALL
BEDROOM #1	159	9'-0"	DRYWALL	CARPET	DRYWALL
BEDROOM #2	155	9'-0"	DRYWALL	CARPET	DRYWALL
BEDROOM #3	158	9'-0"	DRYWALL	CARPET	DRYWALL
DINING	260	9'-0"	DRYWALL	STAINED CONCRETE	DRYWALL
FRONT PORCH	98	9'-0"	CONCRETE	DRYWALL	HARDI-BOARD
FAMILY	406	VAULTED	DRYWALL	STAINED CONCRETE	DRYWALL
GARAGE	710	9'-0"	DRYWALL	CONCRETE	DRYWALL
HALL	190	9'-0"	DRYWALL	STAINED CONCRETE	DRYWALL
KITCHEN	226	9'-0"	DRYWALL	STAINED CONCRETE	DRYWALL
MASTER BATH	166	9'-0"	DRYWALL	STAINED CONCRETE	DRYWALL
MASTER BEDROOM	300	VAULTED	DRYWALL	CARPET	DRYWALL
STORAGE	171	9'-0"	DRYWALL	CONCRETE	DRYWALL
STORAGE	19	9'-0"	DRYWALL	CONCRETE	DRYWALL
UTILITY	104	9'-0"	DRYWALL	STAINED CONCRETE	DRYWALL
WIC	21	9'-0"	DRYWALL	STAINED CONCRETE	DRYWALL
WIC	25	9'-0"	DRYWALL	STAINED CONCRETE	DRYWALL
WIC	36	9'-0"	DRYWALL	STAINED CONCRETE	DRYWALL
WIC	57	9'-0"	DRYWALL	STAINED CONCRETE	DRYWALL
FOYER	52	9'-0"	DRYWALL	STAINED CONCRETE	DRYWALL
LINEN CLOSET	17	9'-0"	DRYWALL	STAINED CONCRETE	DRYWALL
TOTALS:	3939				


WINDOW SCHEDULE											
NUMBER	LABEL	ARCH	QTY	FLOOR	SIZE	WIDTH	HEIGHT	HEADER	SHGC	U-FACTOR	TEMPERED
W01	9060FX	ELLIPTICAL ARCH	1	1	9060FX	108 "	T2 "	2X12X112" (2)	0.3	0.3	YES
W02	2060FX		1	1	2060FX	24 "	T2 "	2X6X28" (2)	0.3	0.3	YES
W03	3030FX	ROUND TOP	1	1	3030FX	36 "	36 "	2X6X40" (2)	0.3	0.3	
W04	5060FX	ROUND TOP	1	1	5060FX	60 "	T2 "	2X8X64" (2)	0.3	0.3	
W05	5040FX	ROUND TOP	1	1	5040FX	60 "	48 "	2X8X64" (2)	0.3	0.3	YES
W06	3060FX		11	1	3060FX	36 "	T2 "	2X6X40" (2)	0.3	0.3	YES

DOOR SCHEDULE							
NUMBER	LABEL	QTY	FLOOR	SIZE	WIDTH	HEIGHT	DESCRIPTION
D01	10070	2	1	10070	120 "	84 "	GARAGE-GARAGE DOOR CHD05
D02	2468	1	1	2468 R IN	28 "	80 "	HINGED-DOOR P09
D03	2668	3	1	2668 L IN	30 "	80 "	HINGED-DOOR P09
D04	3087MU	1	1	3087	36 "	103 "	MULLED UNIT
D05	2668	5	1	2668 R IN	30 "	80 "	HINGED-DOOR P09
D07	3068	3	1	3068 L IN	36 "	80 "	HINGED-DOOR P09
D08	3068	2	1	3068 R IN	36 "	80 "	HINGED-DOOR P09
D09	4068	1	1	4068 L/R IN	48 "	80 "	DOUBLE HINGED-DOOR P09
D10	3068	1	1	3068 R EX	36 "	80 "	EXT. HINGED-DOOR E16

SQUARE FOOTAGE

HEATING / COOLING = 2,517 SQFT
OTHER = 1,422 SQFT

TOTAL = 3,939 SQFT

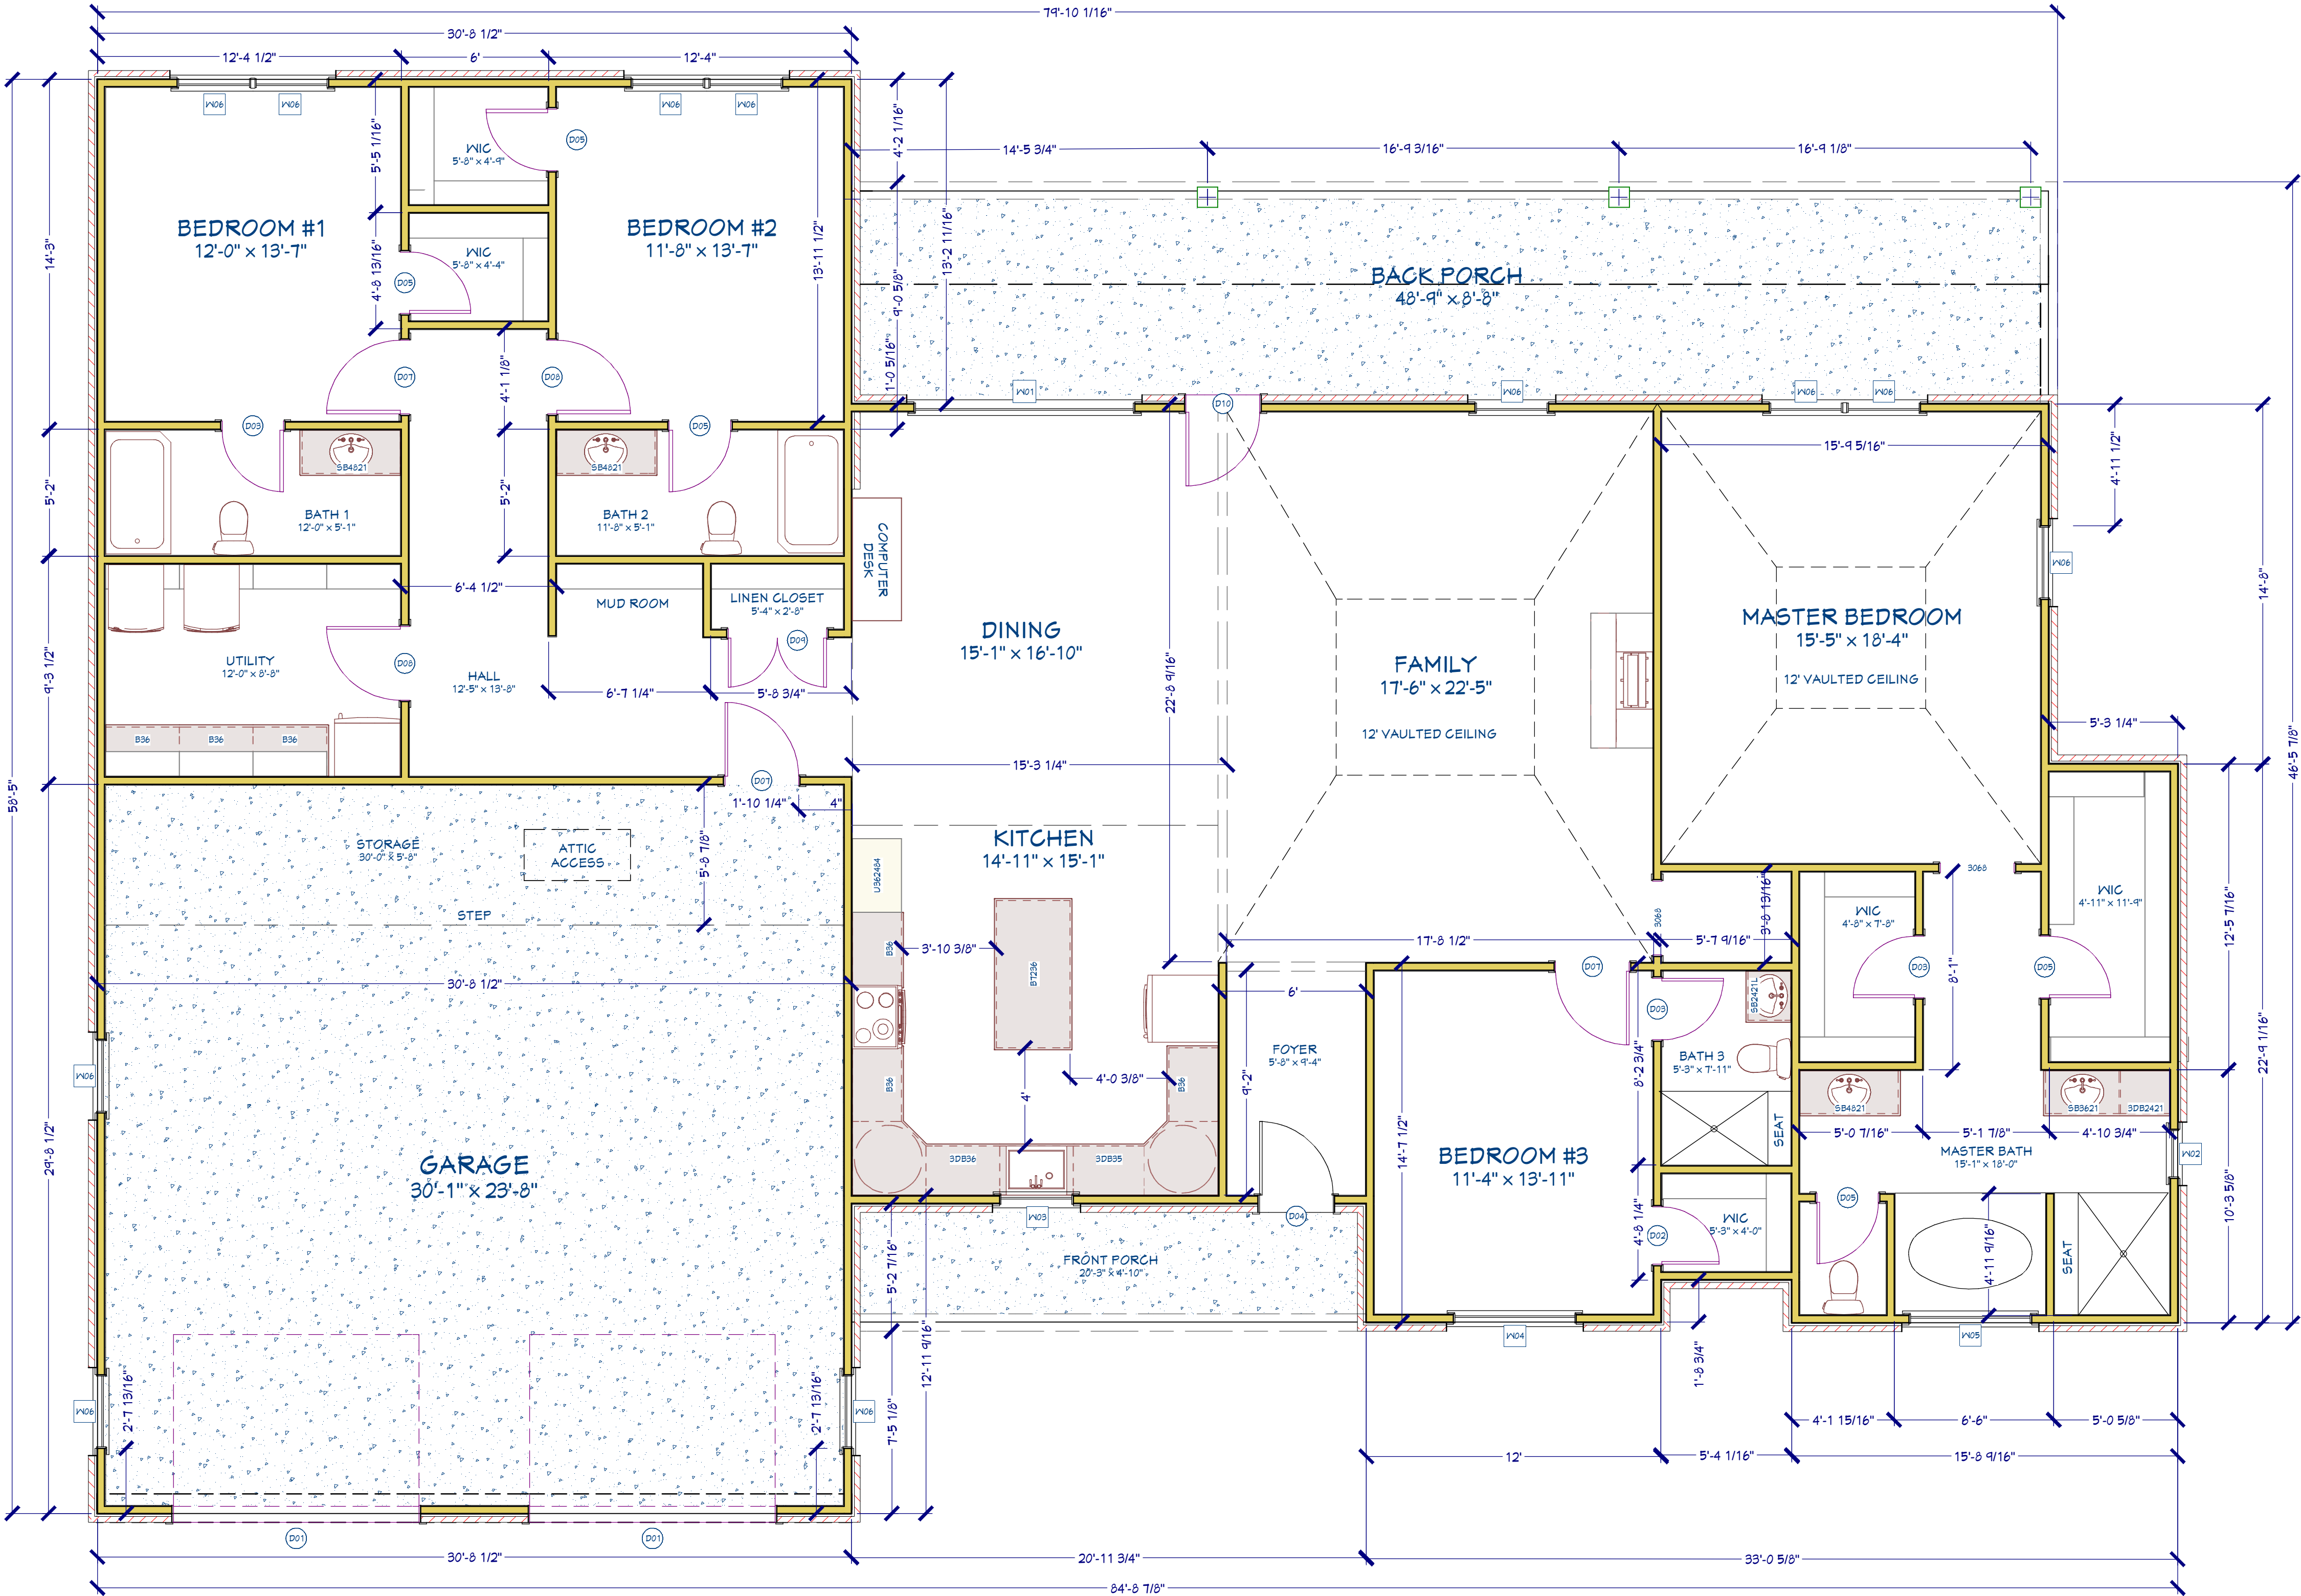

"NEW PROPOSED FLOOR PLAN"

SCALE: 1/4" = 1'-0"

The Owner and Contractor are required to review and verify the design and dimensions, reflected on the plans and/or documents, before purchasing materials or commencement of construction. I hereby do not warrant these plans and/or documents for Engineering or Architectural applications and any use thereof is strictly prohibited, responsibility of those purposes is assumed by the Owner and/or Contractor of the facility. The drawing and dimensions shown hereon are for visual purposes only and may not be to any scale.

Signature/Date:

REVISION TABLE			
NUMBER	DATE	REVISED BY	DESCRIPTION
A	02/09/15	DGR	FOR REVIEW

"NEW PROPOSED FLOOR PLAN"

THANK YOU FOR YOUR BUSINESS
MAY GOD BLESS YOU
"HIS REST MATTHEW 11:28-30"

DRAWINGS PROVIDED BY:

RATLIFF CONSTRUCTION
4012 SHERRY STREET
SULPHUR, LOUISIANA 70665
(337) 375-2401

DATE:


7/30/2019

SCALE:

1/4"=1'-0"

SHEET:

A.5

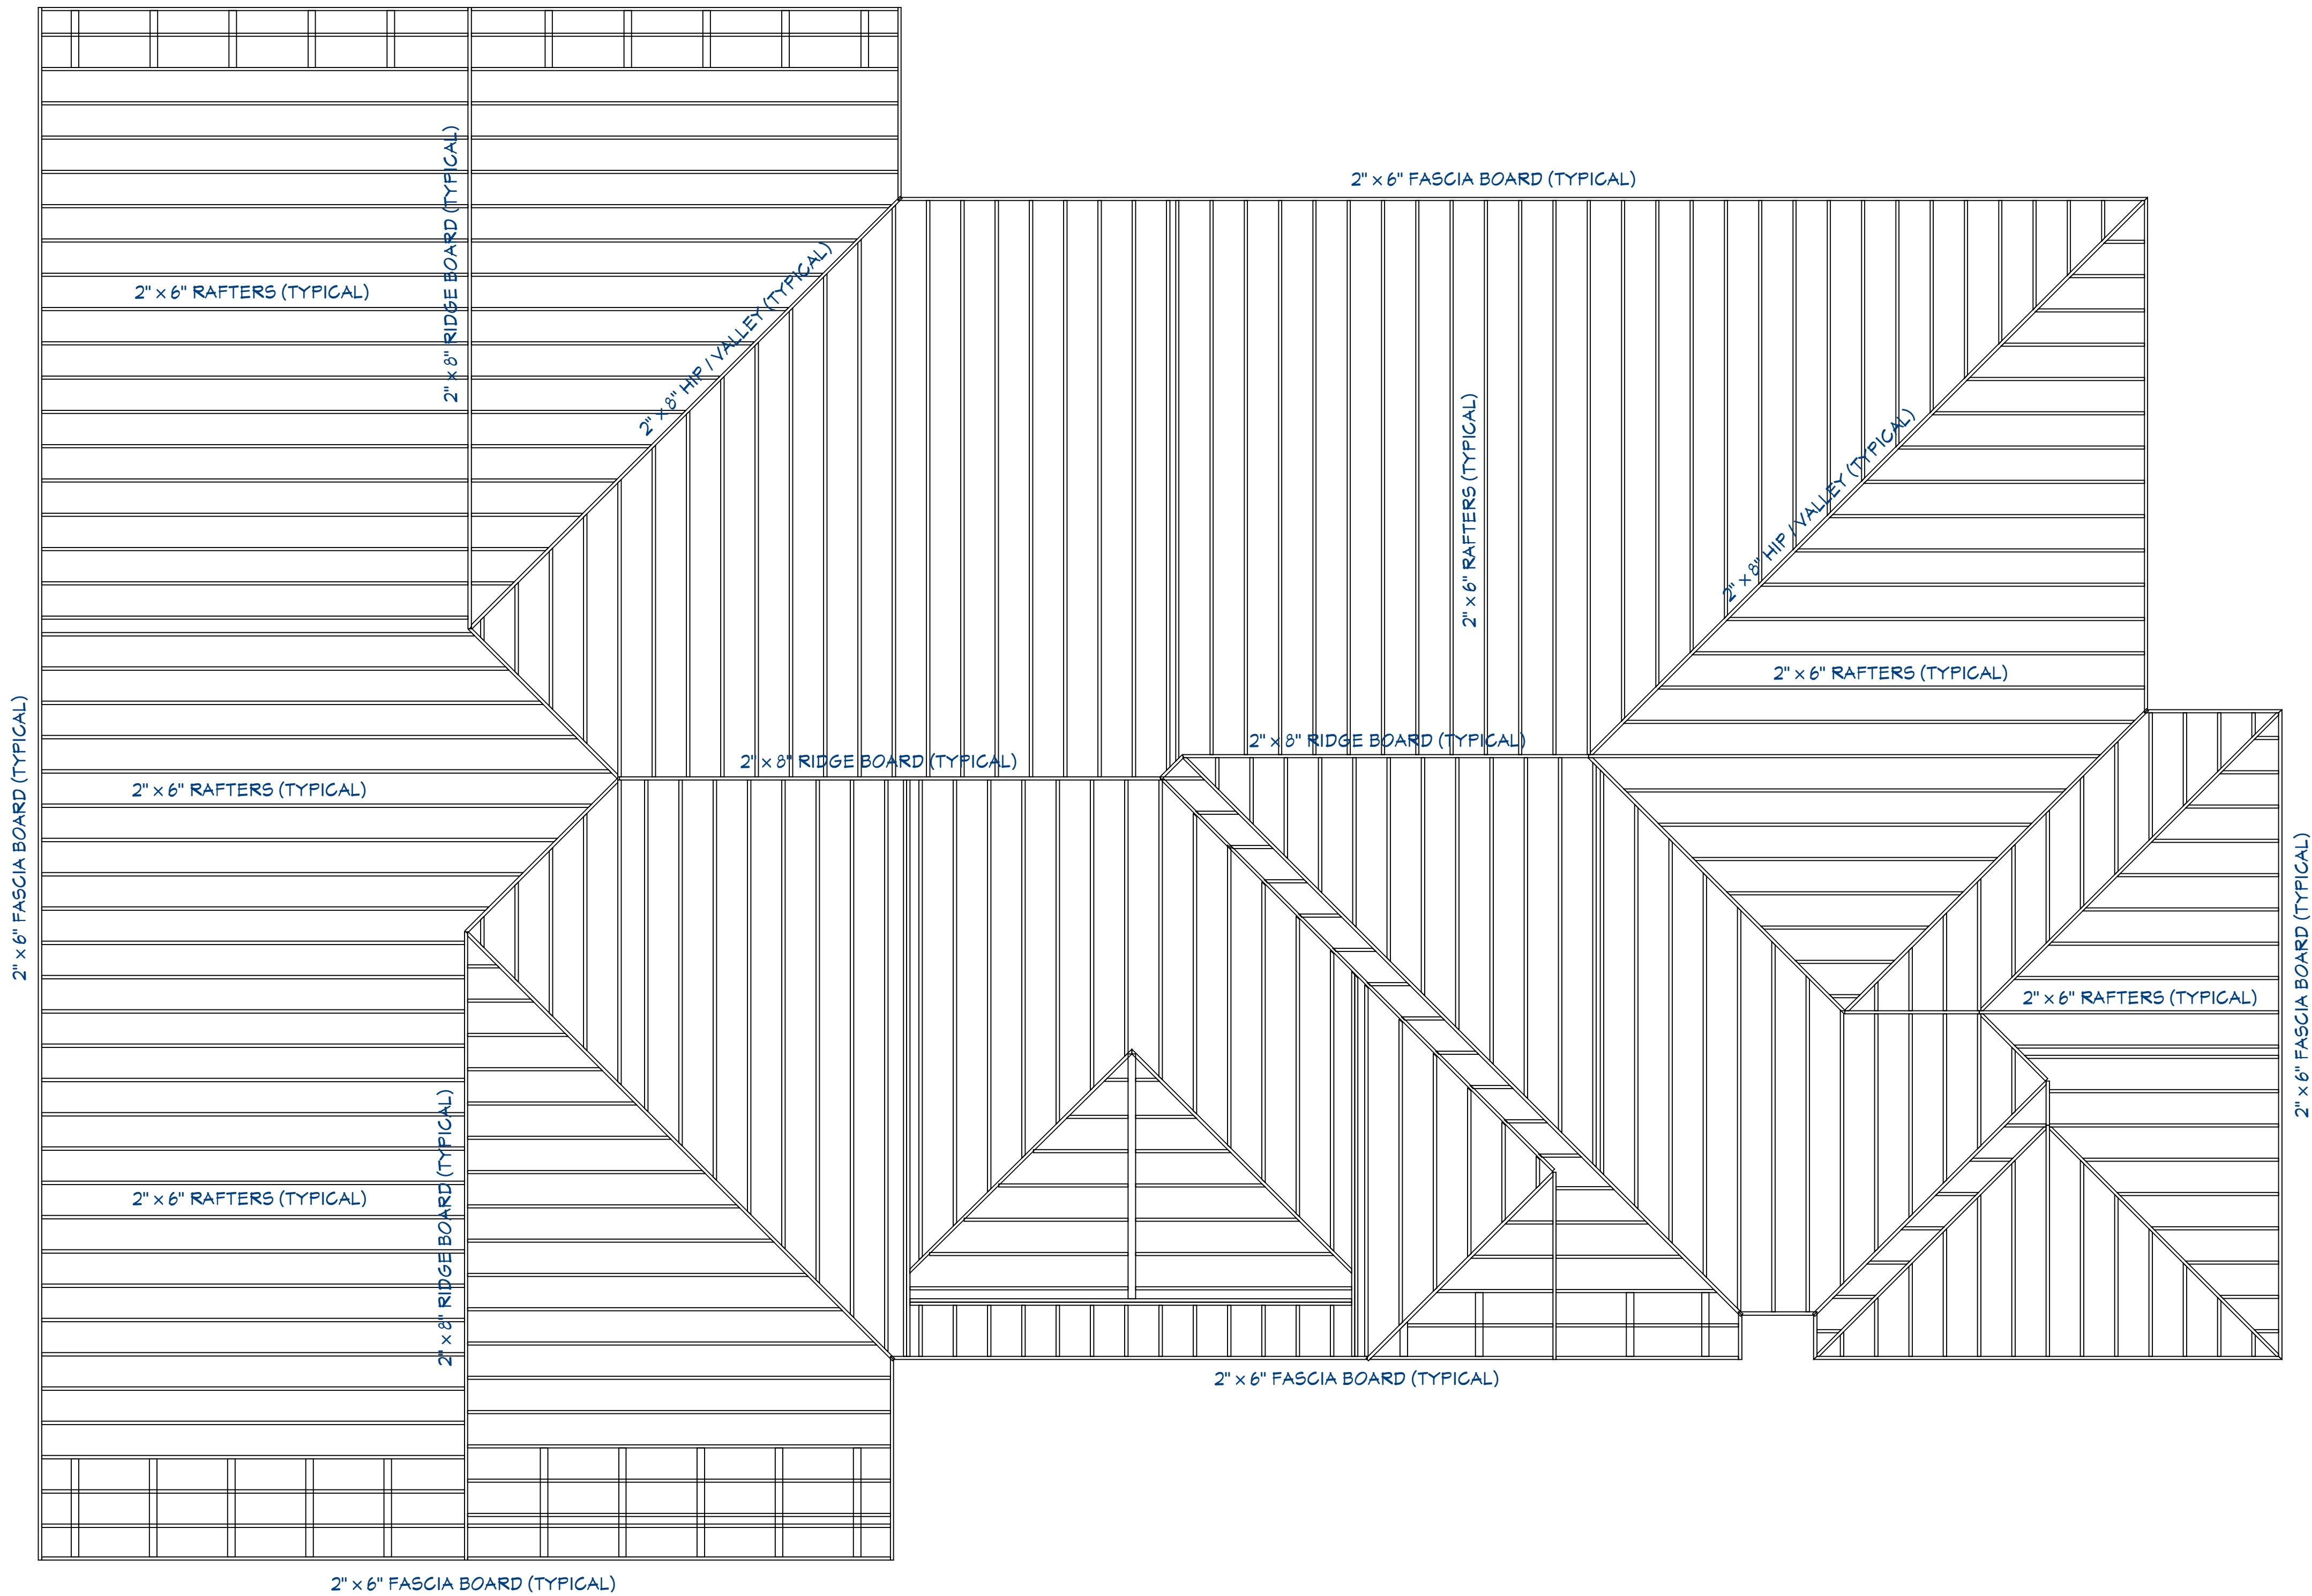

"RAFTER LAYOUT"
SCALE: 1/4" = 1'-0"

The Owner and Contractor are required to review and verify the design and dimensions, reflected on the plans and/or documents, before purchasing materials or commencement of construction. I hereby do not warrant these plans and/or documents for Engineering or Architectural applications and any use thereof is strictly prohibited, responsibility of those purposes is assumed by the Owner and/or Contractor of the facility. The drawing and dimensions shown hereon are for visual purposes only and may not be to any scale.

Signature/Date:

REVISION TABLE			
NUMBER	DATE	REVISED BY	DESCRIPTION FOR REVIEW
A	02/09/15	DGR	

"RAFTER LAYOUT"


THANK YOU FOR YOUR BUSINESS
MAY GOD BLESS YOU
"HIS REST MATTHEW 11:28-30"

DRAWINGS PROVIDED BY:
RATLIFF CONSTRUCTION
4012 SHERRY STREET
SULPHUR, LOUISIANA 70665
(337) 375-2401

DATE:
7/30/2019

SCALE:
1/4"=1'-0"

SHEET:
A.6

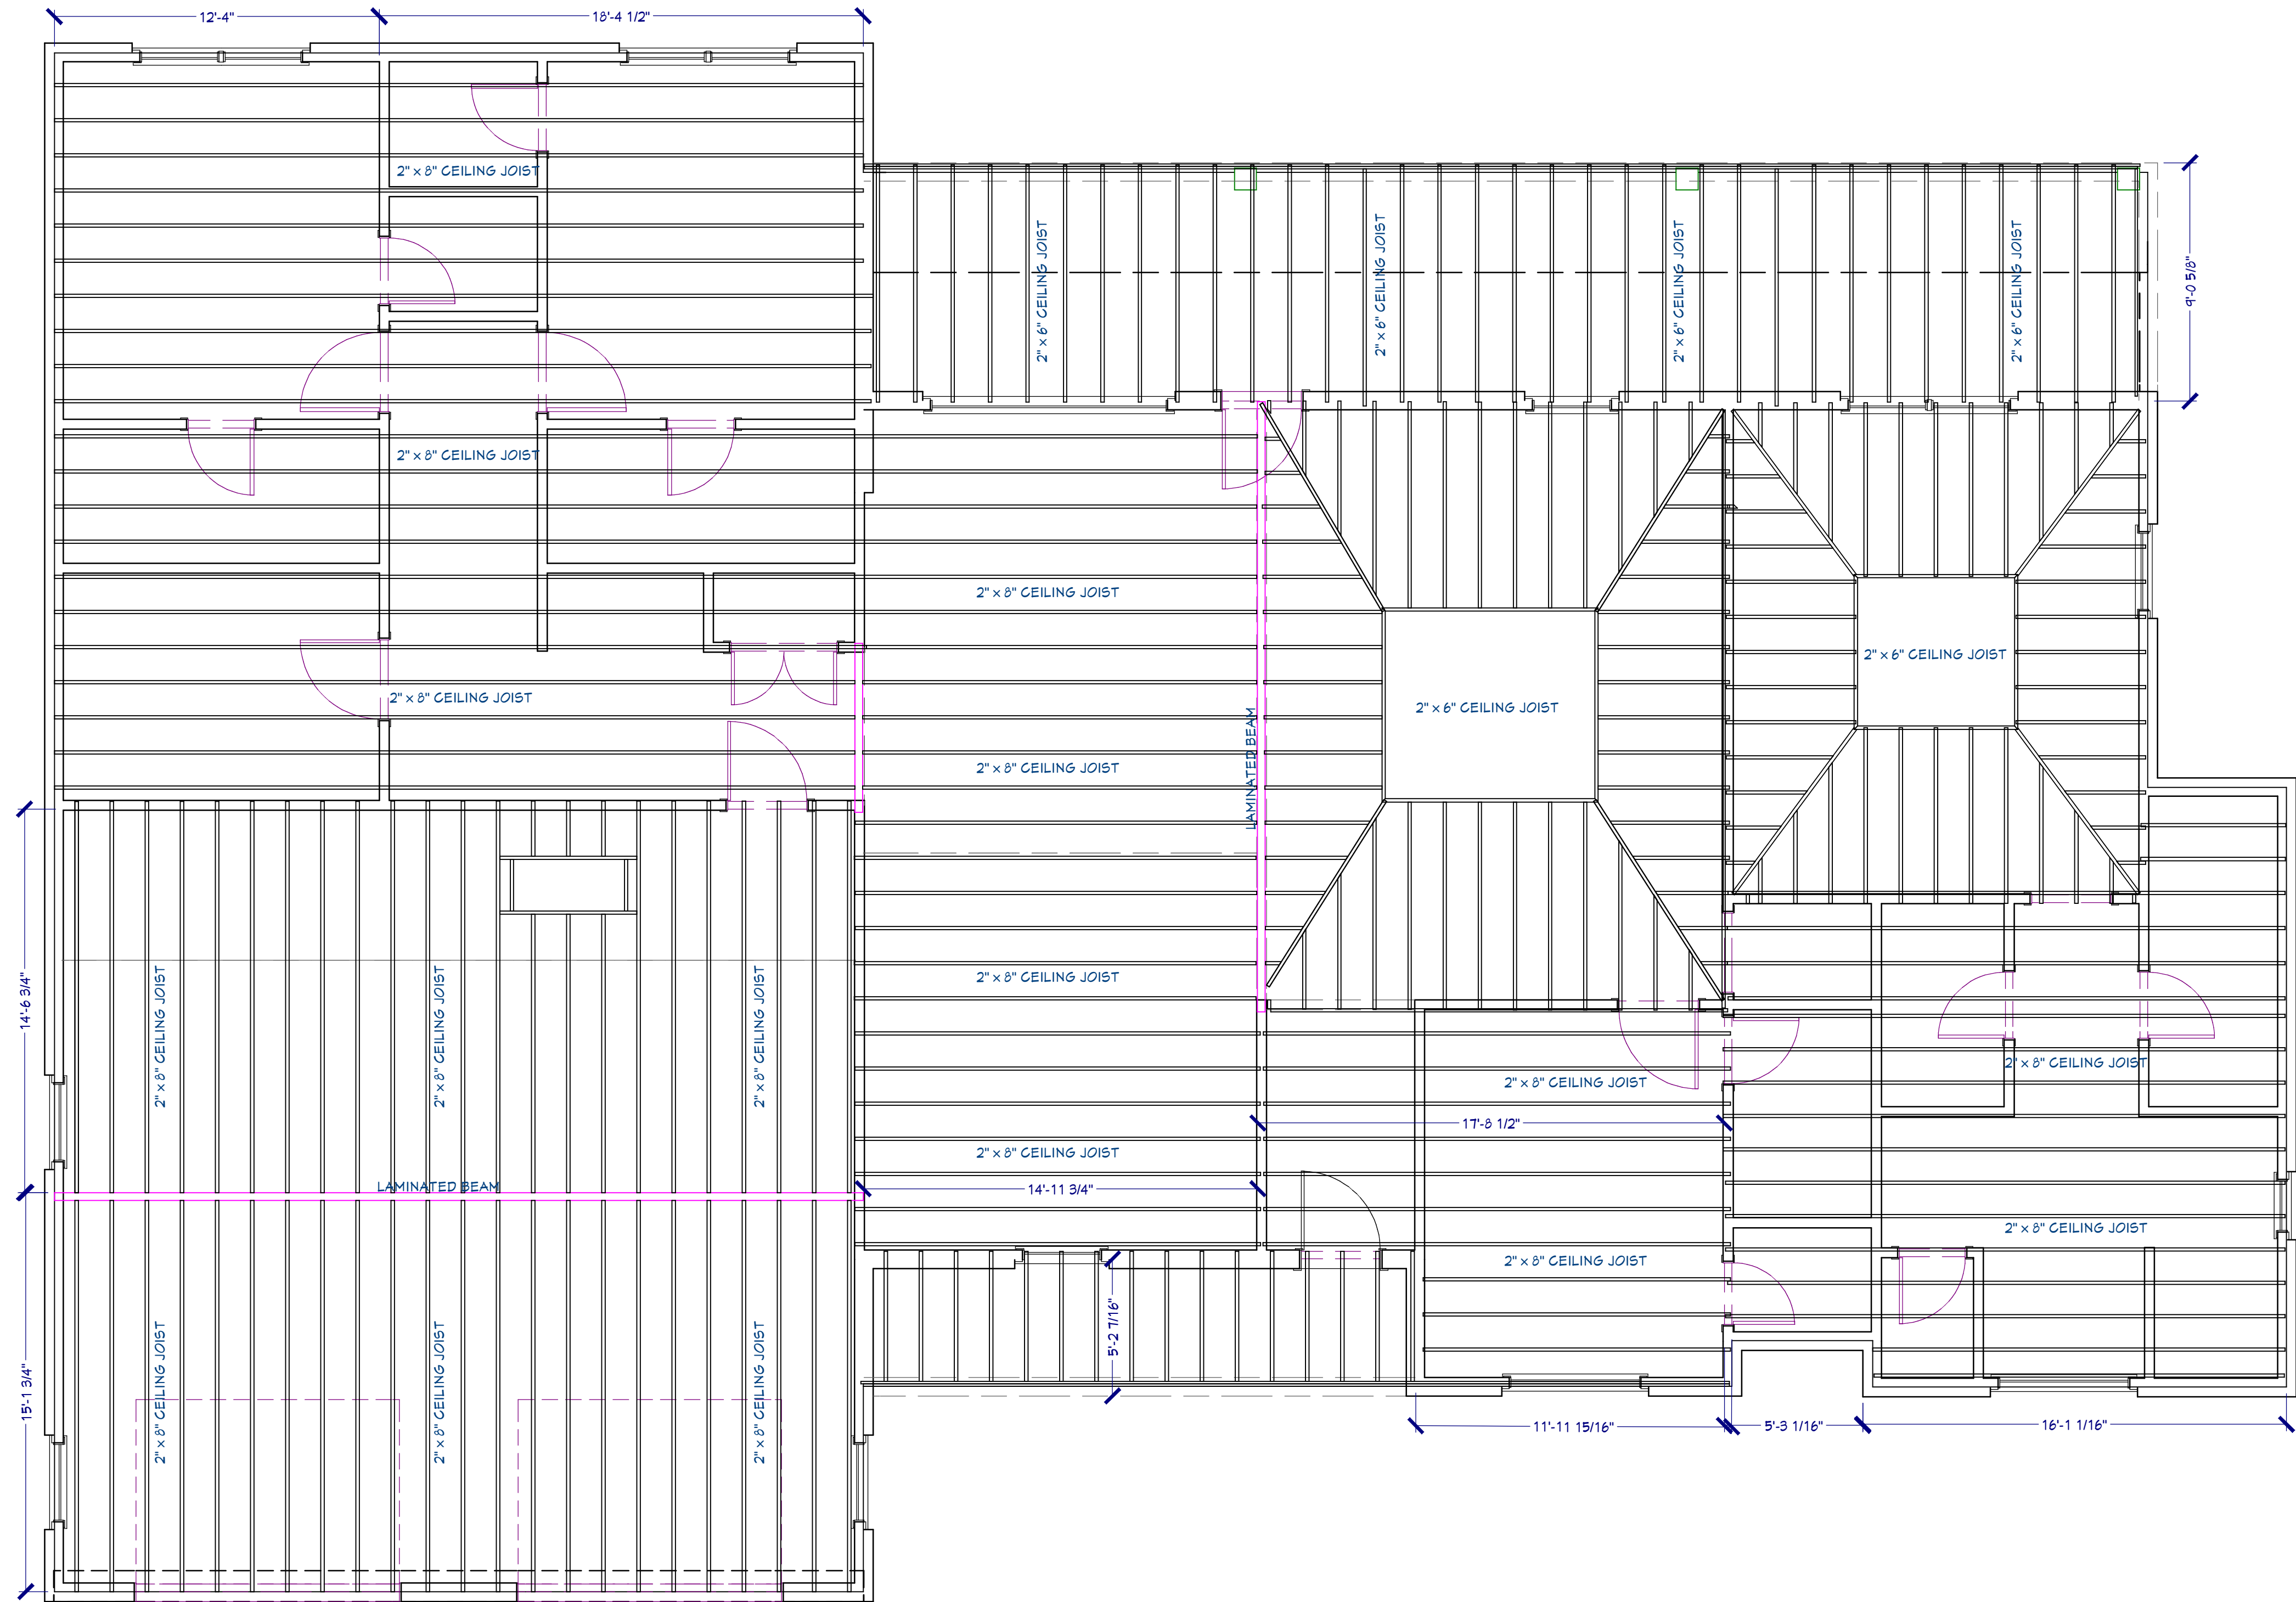

"CEILING JOIST LAYOUT"
SCALE: 1/4" = 1'-0"

The Owner and Contractor are required to review and verify the design and dimensions, reflected on the plans and/or documents, before purchasing materials or commencement of construction. I hereby do not warrant these plans and/or documents for Engineering or Architectural applications and any use thereof is strictly prohibited, responsibility of those purposes is assumed by the Owner and/or Contractor of the facility. The drawing and dimensions shown hereon are for visual purposes only and may not be to any scale.

Signature/Date:

"CEILING JOIST LAYOUT"

THANK YOU FOR YOUR BUSINESS
MAY GOD BLESS YOU
"HIS REST MATTHEW 11:28-30"

DRAWINGS PROVIDED BY:

RATLIFF CONSTRUCTION
4012 SHERRY STREET
SULPHUR, LOUISIANA 70665
(337) 375-2401

DATE:

7/30/2019

SCALE:


1/4"=1'-0"

SHEET:

A.7

REVISION TABLE

NUMBER	DATE	REVISED BY	DESCRIPTION
A	02/04/15	DGR	FOR REVIEW

 

DRAWINGS PROVIDED BY:
RATLIFF CONSTRUCTION
4012 SHERRY STREET
SULPHUR, LOUISIANA 70665
(337) 375-2401

DATE:

7/30/2019

SCALE:

1/4"=1'-0"

SHEET:

E.1

CHAD & JODIE NORMOOD
SULPHUR, LOUISIANA

"ELECTRICAL PLAN"

THANK YOU FOR YOUR BUSINESS
MAY GOD BLESS YOU
"HIS REST MATTHEW 11:28-30"

REVISION TABLE			
NUMBER	DATE	REVISED BY	DESCRIPTION
A	02/04/15	DGR	FOR REVIEW