 
 
 
 


CALL BEFORE YOU DIG
1-800-272-3020
(OR CALL 811)
SAVE TIME BY ENTERING TICKETS AT
www.1aonecall.com



- NOTES


1. PROPERTY LINES SHOWN HEREON ARE REFERENCED TO PLAT OF SURVEY NO. 130001 FOR JAMES MATTE, DATED AUGUST 5, 2013 BY AMERICAN SURVEYORS (RICKY HAYES).
2. SOURCE: NFPA 10/10/2012, IBC 2012, 2A TITLE 51, SANITARY CODE 2013.
3. SLAB LEVEL TO BE (1) ONE FOOT HIGHER THAN ADJACENT ROAD OR (1) ONE FOOT ABOVE B.F.E. (BASE FLOOD ELEVATION) WHICHEVER IS HIGHER.
4. ELEVATIONS TO BE PROVIDED BY LAND SURVEYOR.



PROPOSED SITE PLAN



"AERIAL VIEW OF SITE"

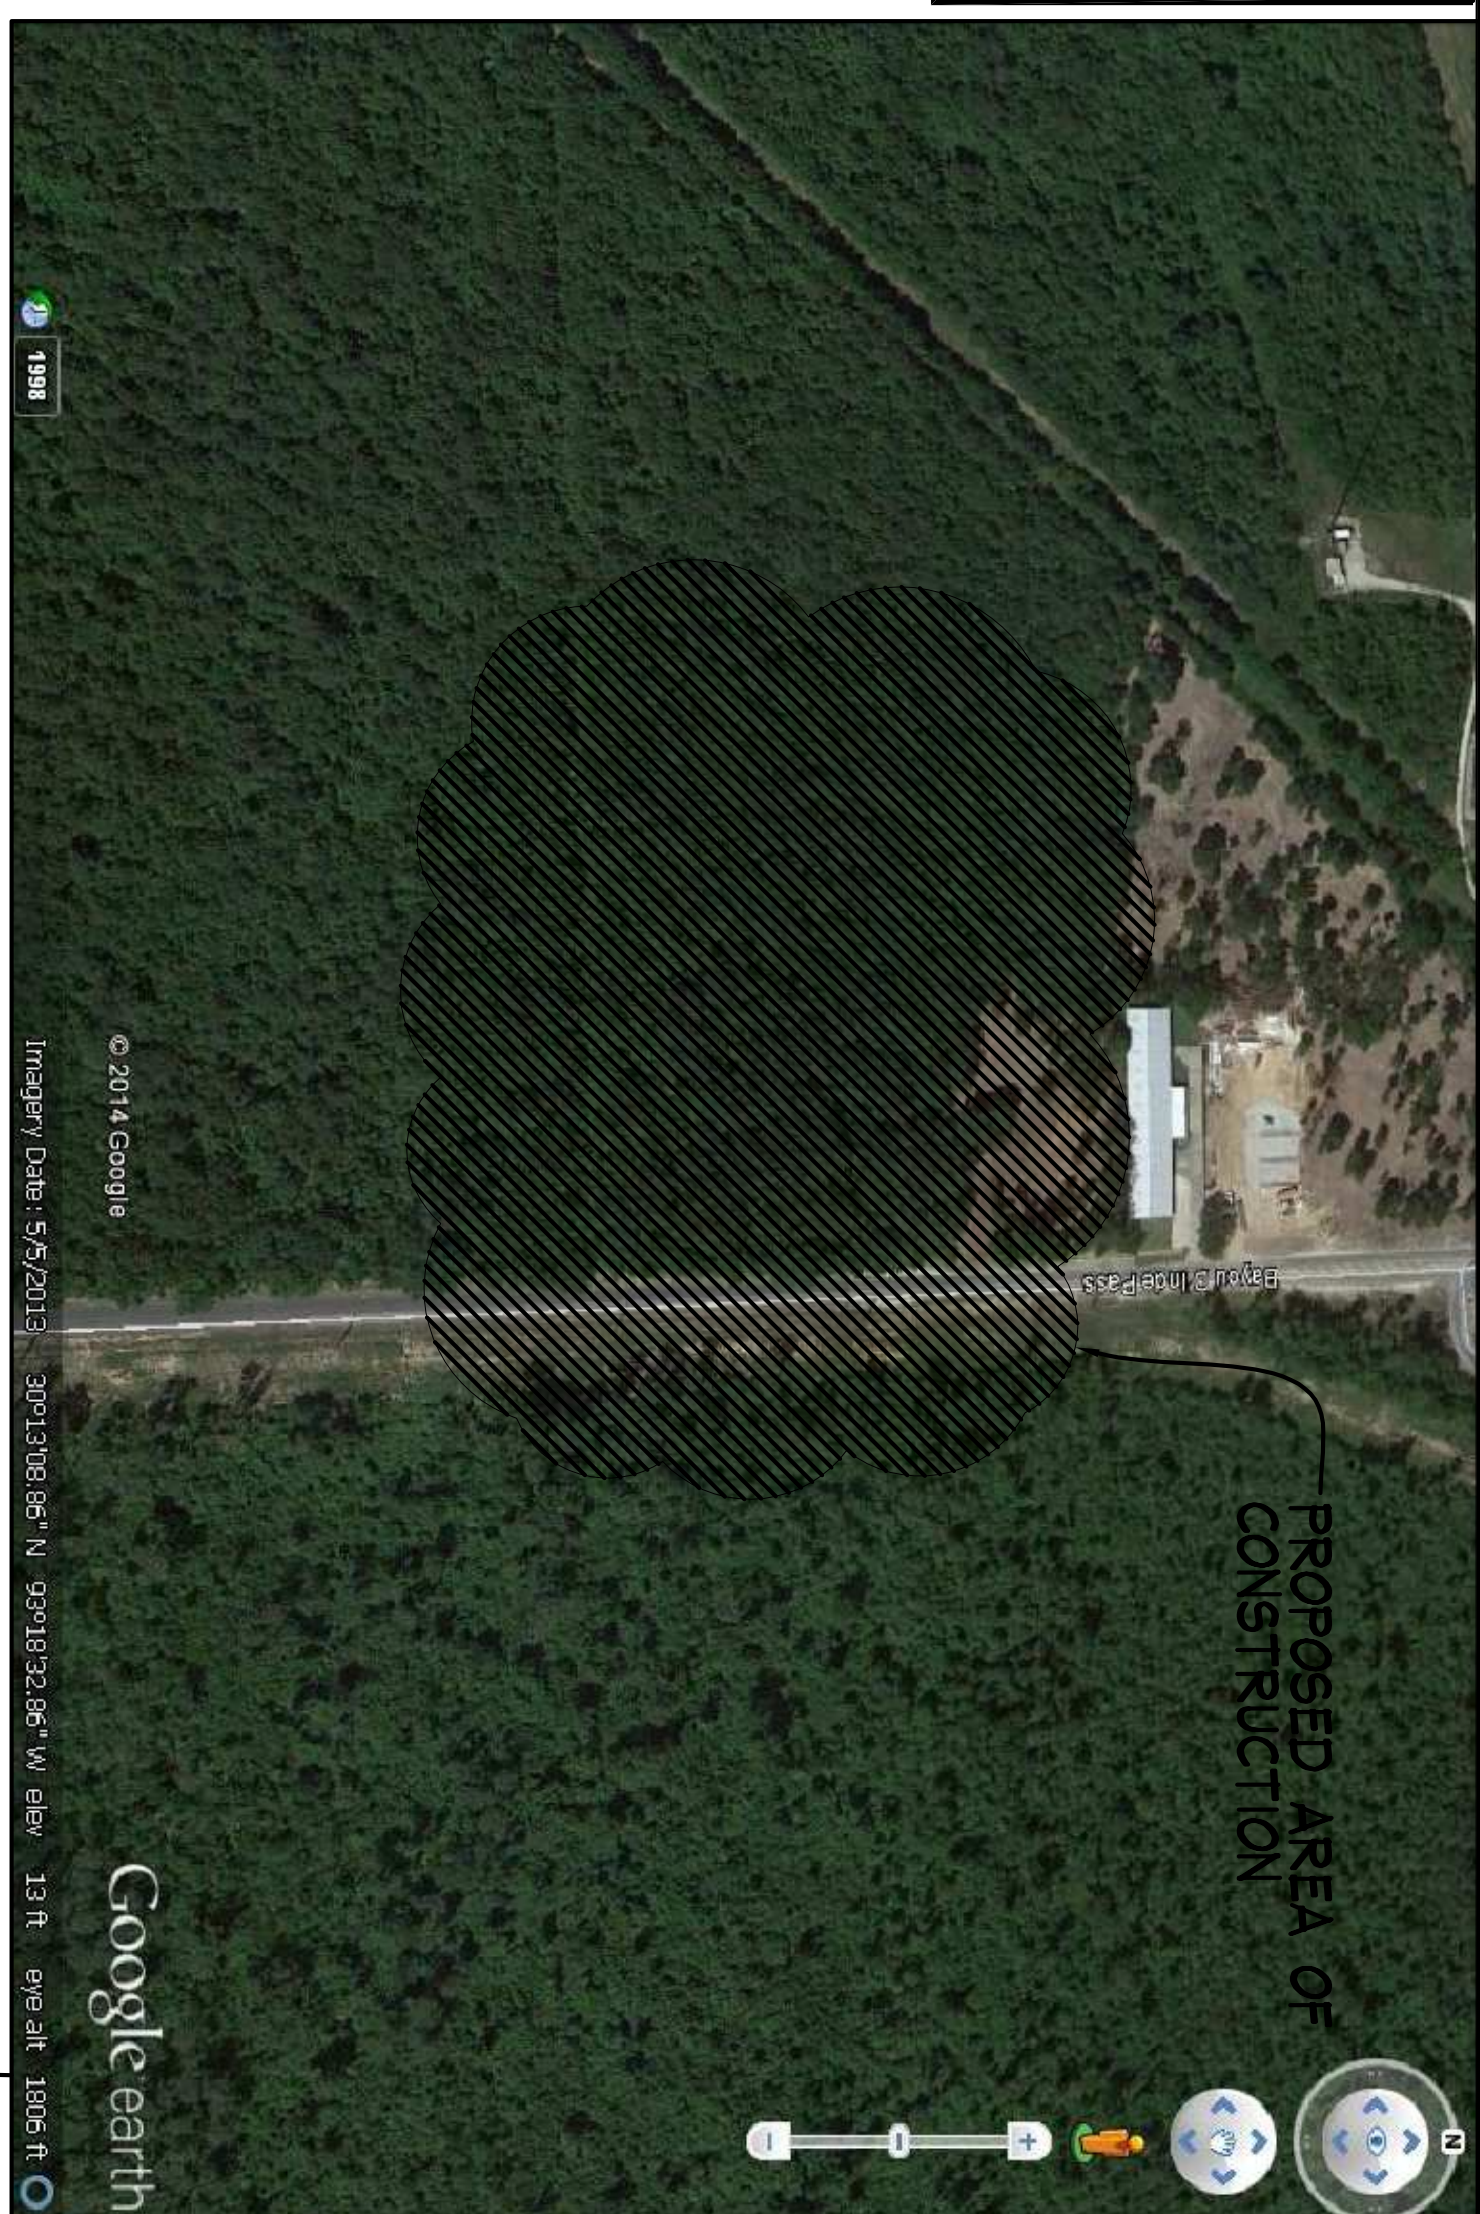


"SITE PLAN"
THANK YOU FOR YOUR BUSINESS
MAY GOD BLESS YOU
"HIS REST MATTHEW 11:-28-30"

DRAWN BY:	DATE DRAWN:
APPROVED BY:	DATE APPROVED:
	JOB#:
SULPHUR, LOUISIANA	


SULPHUR, LOUISIANA

DATE: _____

SIGNATURE _____

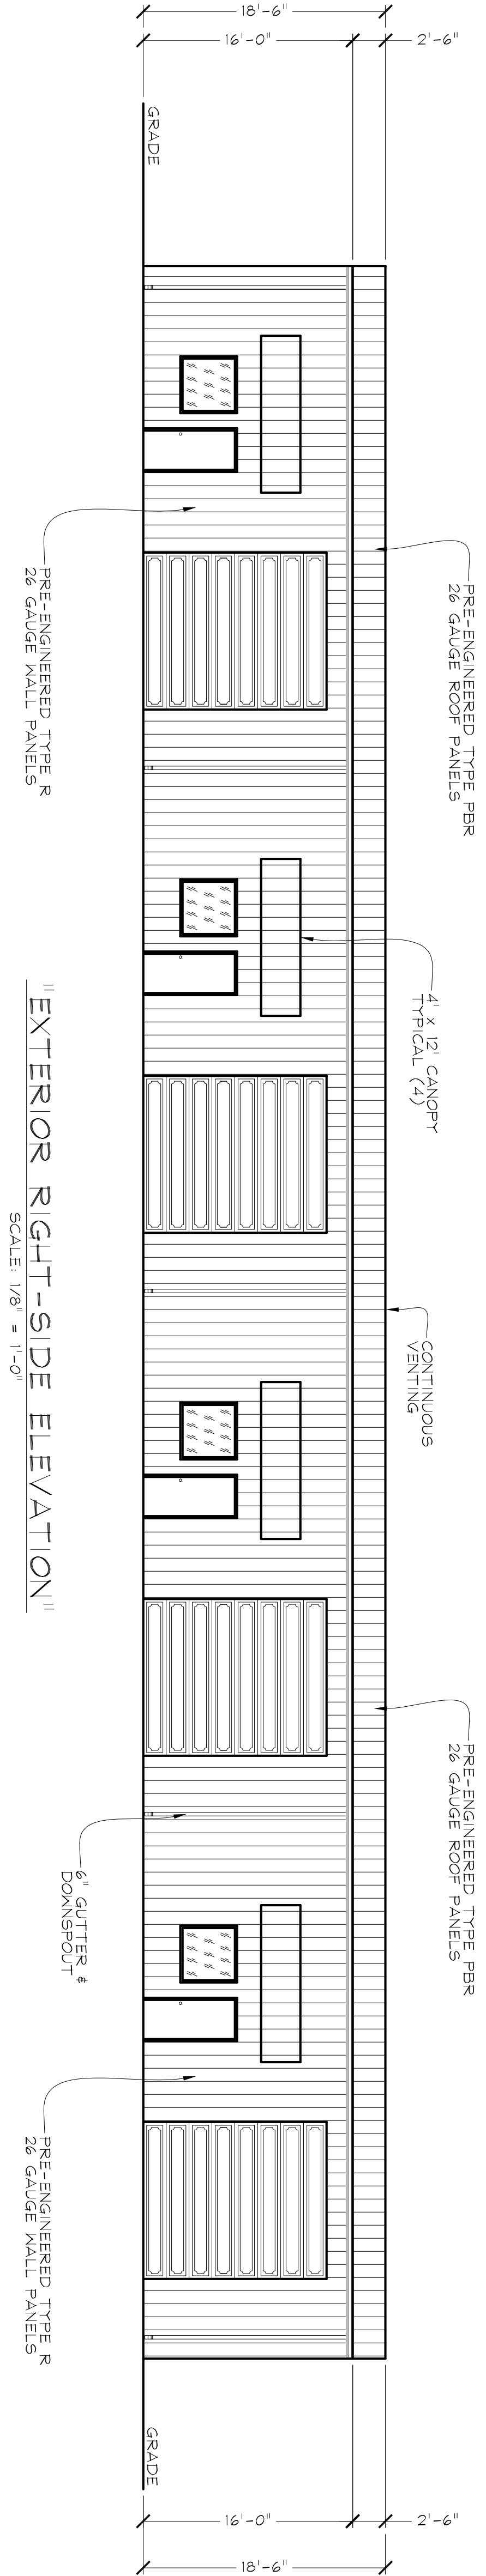

- NOTES:
- PRE-ENGINEERED FABRICATED STEEL BUILDING TO BE:
 - 60' WIDE X 160' LONG X 16' HIGH.
 - ROOF SLOPE TO BE 1:12.
 - DESIGN LOADS: 20PSF LIVE LOAD, 140 MPH WIND LOAD.
 - BUILDING TO HAVE TAPERED OR STRAIGHT COLUMNS W/FLUSH OR BYPASS GIRTS. (BUILDING SUPPLIER OPTION).
 - THIS FLOOR PLAN IS BASED ON A DESIGN WITH TAPERED COLUMNS AND BY-PASS GIRTS.
 - ROOF PANELS TO BE 26 GAUGE PBR PAINTED STEEL ROOF PANELS, 30 YEAR WARRANTY, COLOR TO BE OWNERS CHOICE WITH NO EXCEPTIONS.
 - WALL PANELS TO BE 26 GAUGE R-PANELS, GALVALUME OR PAINTED, OWNERS CHOICE WITH NO EXCEPTIONS.
 - GUTTERS AND DOWNSPOUTS W/SPLASH BLOCKS.
 - BUILDINGS TO HAVE CONTINUOUS RIDGE VENT.
 - ROOF AND WALLS TO HAVE BLANKET TPE INSULATION, 3" THICK (R10) W/3 MIL VINTL REINFORCED POLYESTER VAPOR BARRIER.

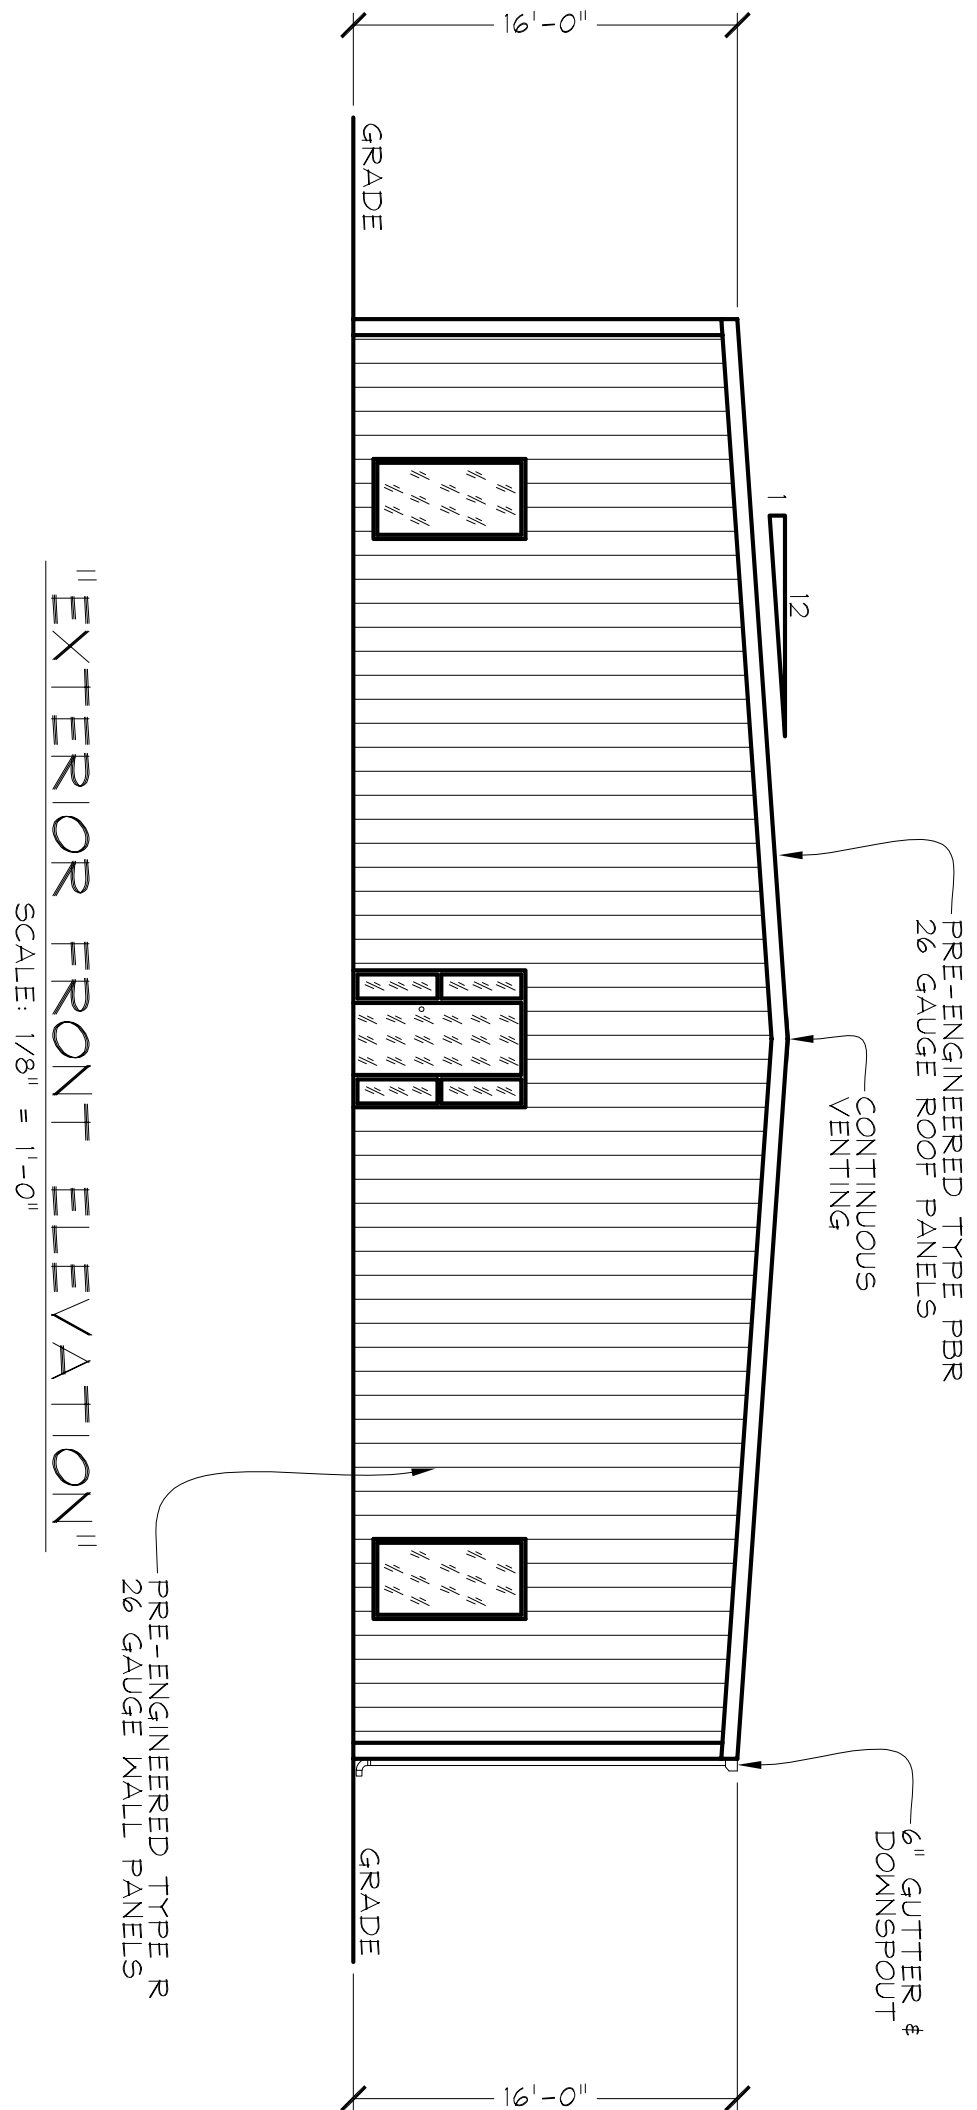


LA ONE CALL
CALL BEFORE YOU DIG
1-800-272-3020
(OR CALL 811)
SAVE TIME BY ENTERING TICKETS AT
www.laonecall.com

"EXTERIOR ELEVATIONS"
THANK YOU FOR YOUR BUSINESS
MAY GOD BLESS YOU
"HIS REST MATTHEW 11:-28-30"

DRAWN BY:	DATE DRAWN:	5/8/2014
APPROVED BY:	DATE APPROVED:	05/2014
	JOB#:	
SULPHUR, LOUISIANA		0

DATE:
SIGNATURE:


SHEET
A.2

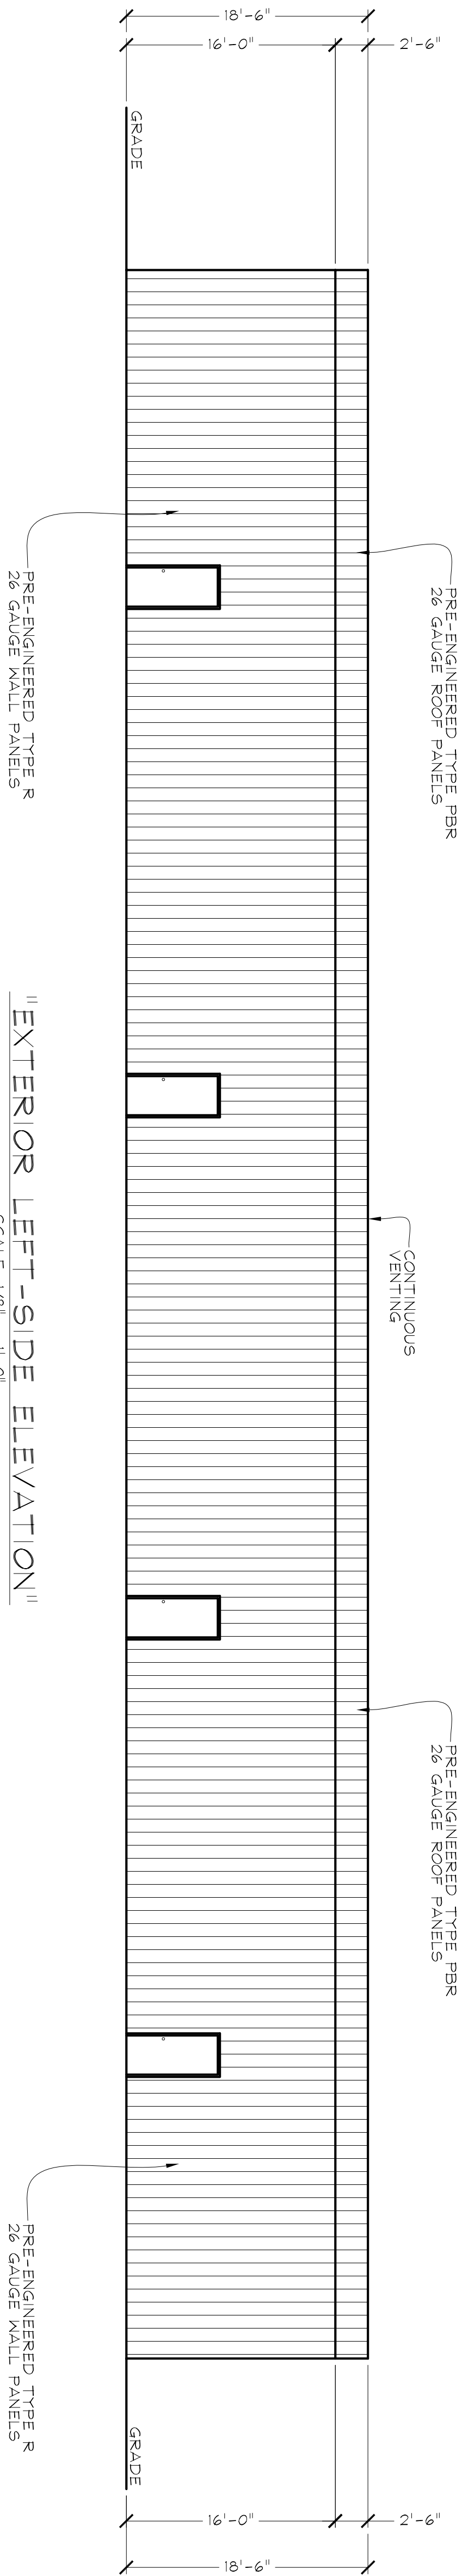

11" EXTERIOR LEFT-SIDE ELEVATION 11"

SCALE: 1/8" = 1'-0"

- NOTES:
- PRE-ENGINEERED FABRICATED STEEL BUILDING TO BE:
 - 60' WIDE X 160' LONG X 16' HIGH.
 - ROOF SLOPE TO BE 1:12.
 - DESIGN LOADS: 20PSF LIVE LOAD, 140 MPH WIND LOAD.
 - BUILDING TO HAVE TAPERED OR STRAIGHT COLUMNS W/FLUSH OR BYPASS GIRTS. (BUILDING SUPPLIER OPTION).
 - THIS FLOOR PLAN IS BASED ON A DESIGN WITH TAPERED COLUMNS AND BY-PASS GIRTS.
 - ROOF PANELS TO BE 26 GAUGE PBR PAINTED STEEL ROOF PANELS, 30 YEAR WARRANTY, COLOR TO BE OWNERS CHOICE WITH NO EXCEPTIONS.
 - WALL PANELS TO BE 26 GAUGE R-PANELS, GALVALUME OR PAINTED, OWNERS CHOICE WITH NO EXCEPTIONS.
 - GUTTERS AND DOWNSPOUTS W/SPASH BLOCKS.
 - BUILDINGS TO HAVE CONTINUOUS RIDGE VENT.
 - ROOF AND WALLS TO HAVE BLANKET TYPE INSULATION, 3" THICK (R10) W/3 MIL VINYL REINFORCED POLYESTER VAPOR BARRIER.

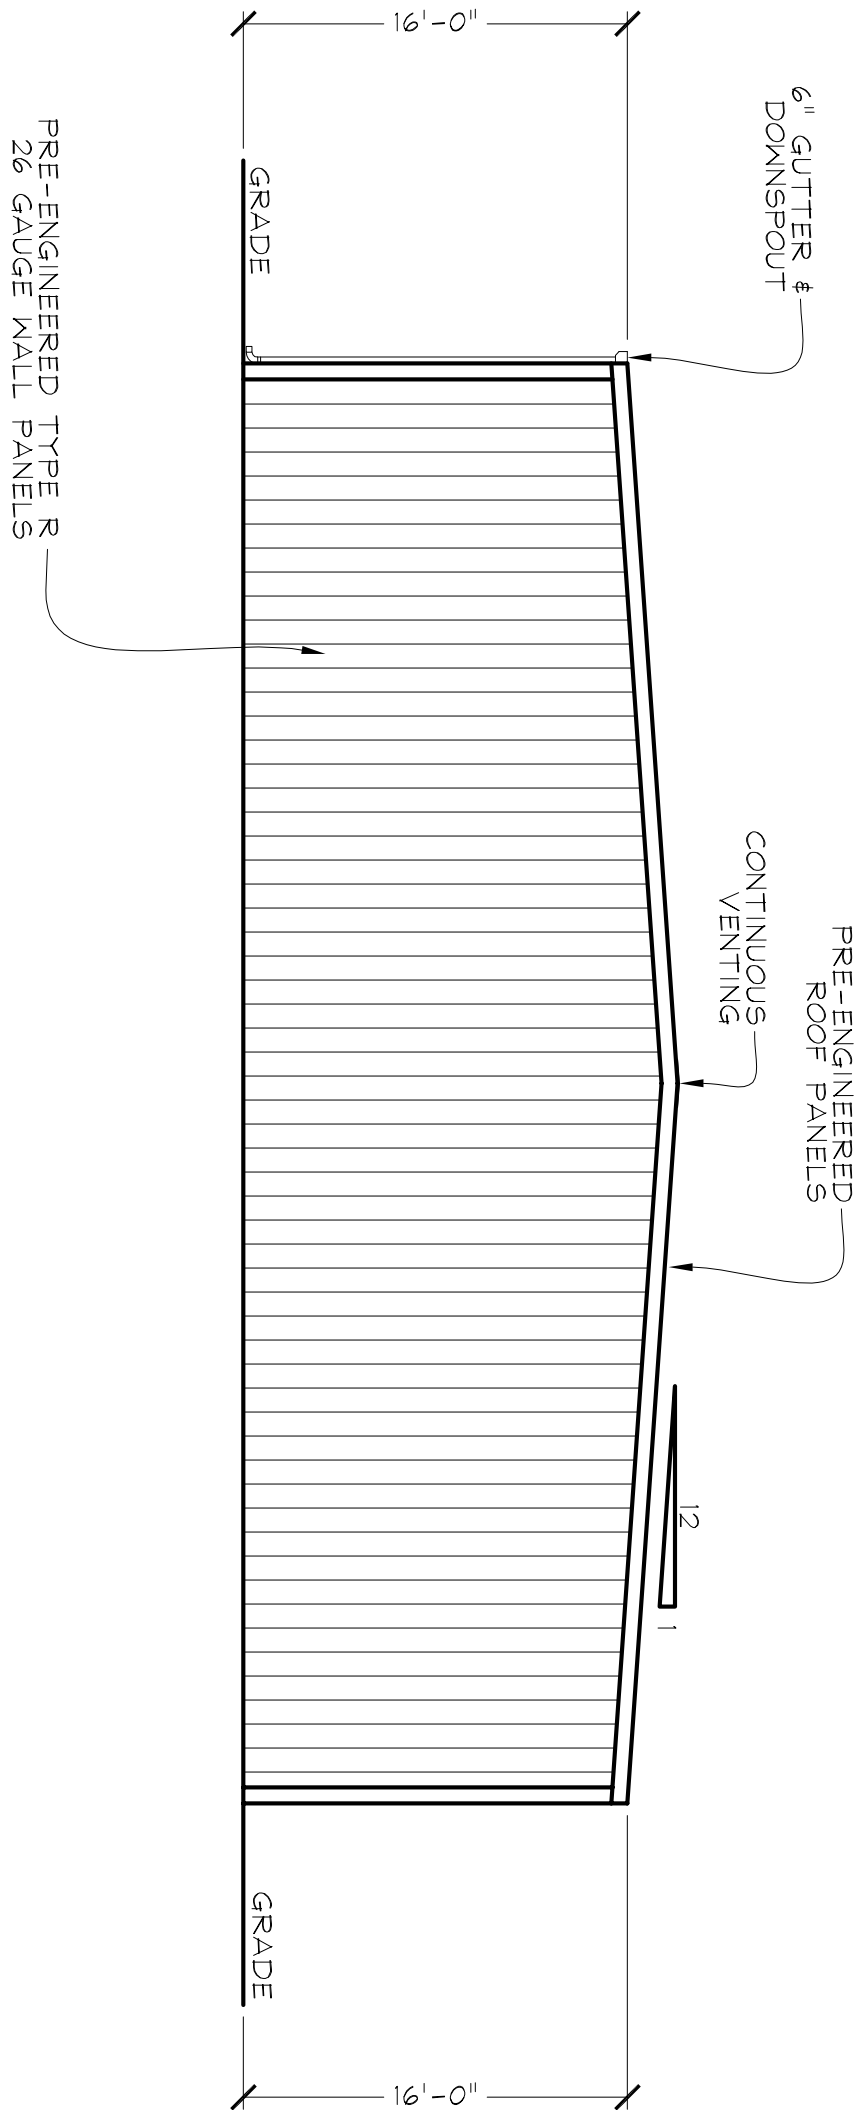

11" EXTERIOR REAR ELEVATION 11"

SCALE: 1/8" = 1'-0"



LA ONE CALL
CALL BEFORE YOU DIG
1-800-272-3020
(OR CALL 811)
SAVE TIME BY ENTERING TICKETS AT
www.laonecall.com

"EXTERIOR ELEVATIONS"
THANK YOU FOR YOUR BUSINESS
MAY GOD BLESS YOU
"HIS REST MATTHEW 11:-:28-30"

DRAWN BY:	DATE DRAWN:	5/8/2014
APPROVED BY:	DATE APPROVED:	05/2014
	JOB#:	
SULPHUR, LOUISIANA		0

SHEET
A.3

DATE:
SIGNATURE:

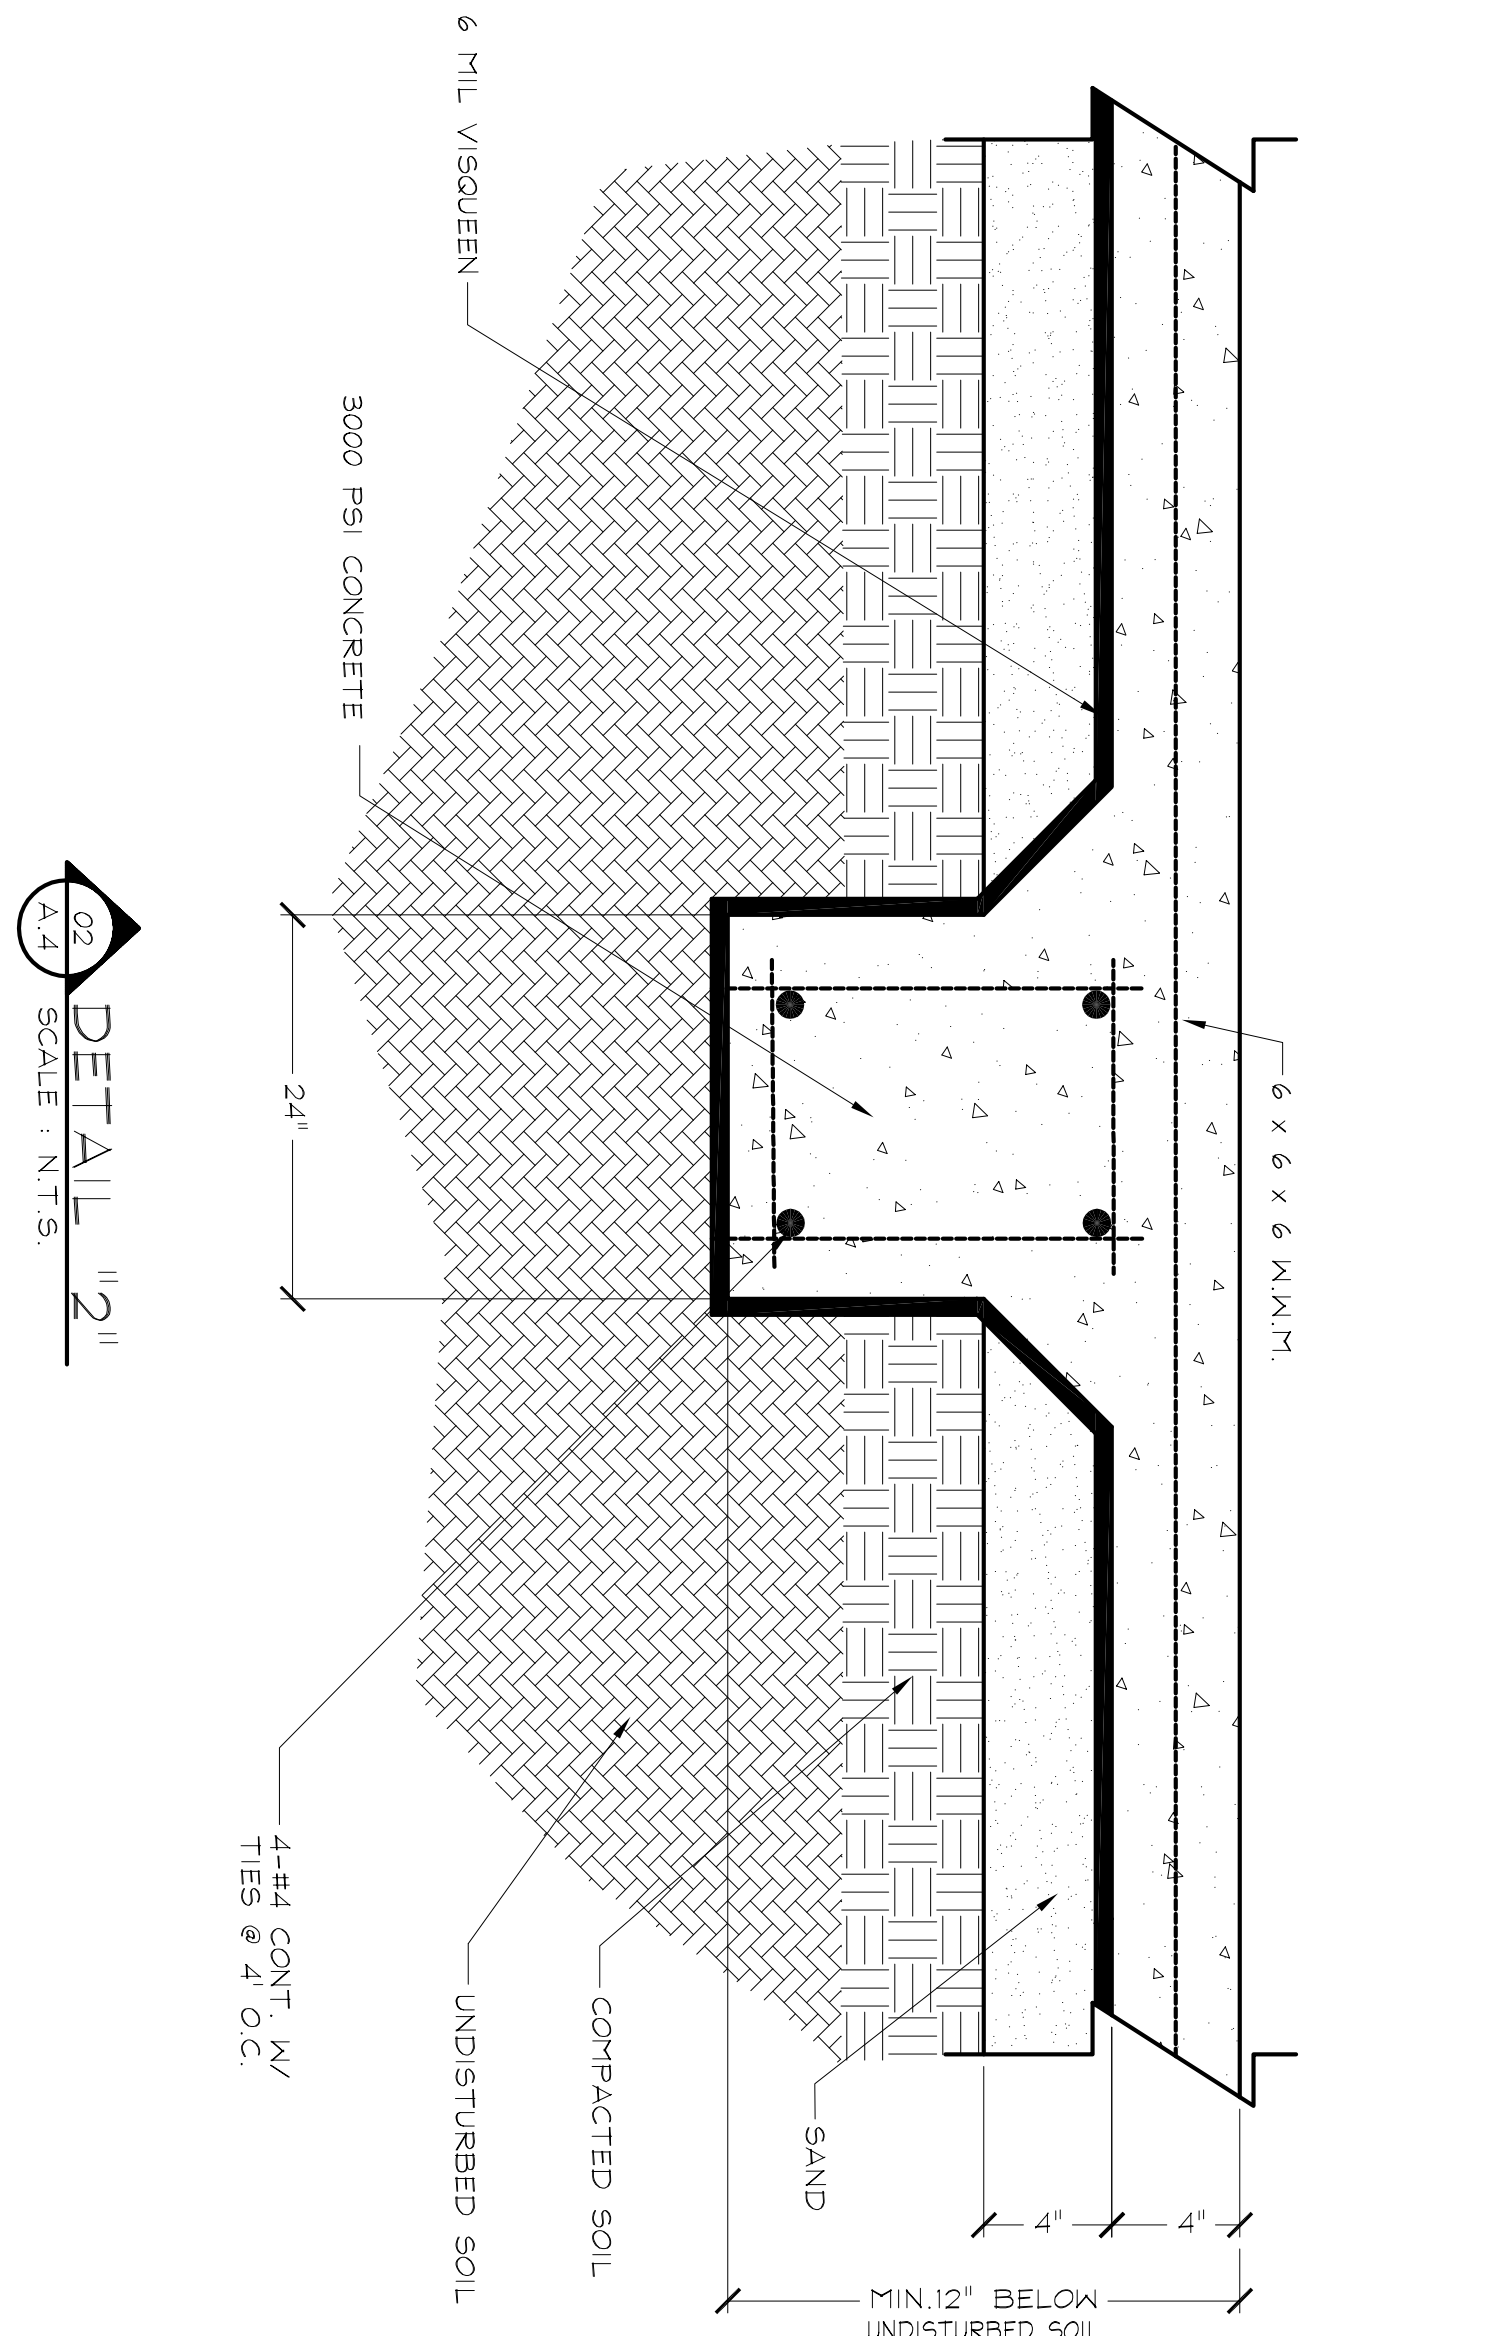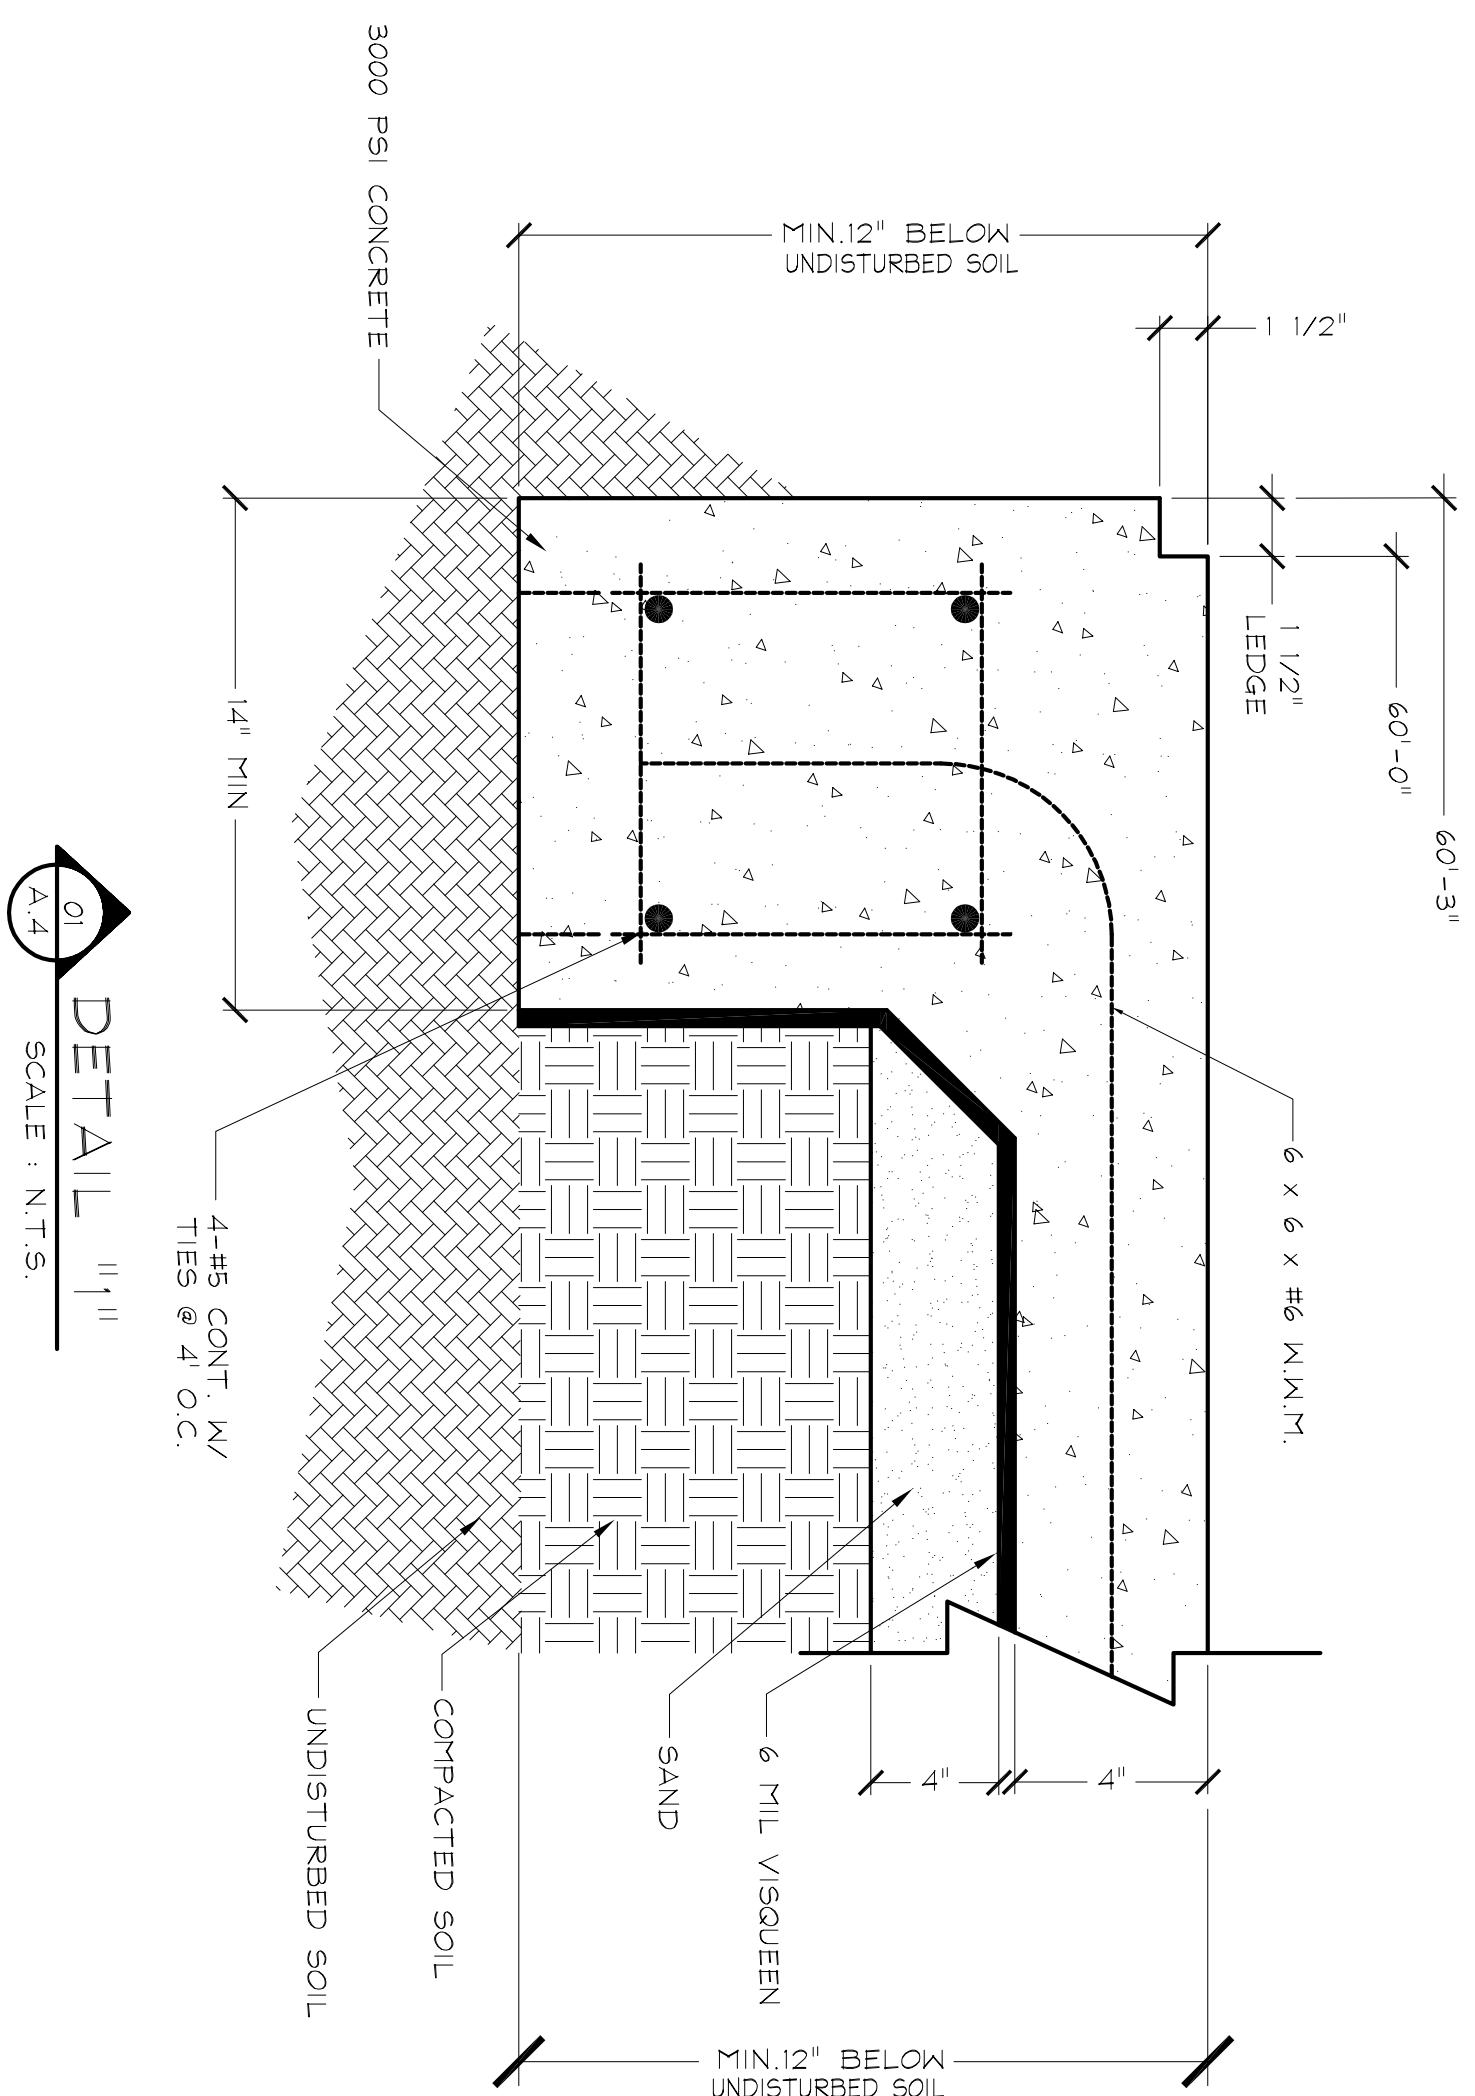

GENERAL NOTES:

1. THE CONTRACTOR SHALL CORRELATE ALL DIVISIONS BETWEEN THE PLANS BEFORE CONSTRUCTION AND NOTIFY THE ENGINEER OF ANY DISCREPANCIES OR INCONSISTENCIES BEFORE PROCEEDING WITH THE WORK.
2. ALL CUTTING AND FILLING SHALL BE IN CLOSE ACCORDANCE WITH THE SOils REPORT.
3. BEFORE SURFACE VEGETATION AND ALL OBSTRUCTIONS ARE REMOVED, INSPECTION OF THE SITE FOR EARTHWORK AND DRAINAGE IS A MAJOR REQUIREMENT TO THE PROJECT OWNER. REPLACE OVER-CUTTING ZONES WITH DENSITY-CONTROLLED SELECT FILL.
4. ALL CONCRETE POLYS AND W/TS TEMPERATURES RANGE BETWEEN 50° AND 90°F, CAN BE MADE WITHIN AN SPECIAL PROVISIONS.
5. SAND FILL MATERIAL SHALL BE CLEAN, FREE OF ORGANIC MATTER AND DEBRIS OR ROCK MATERIALS.
6. SELECT FILL SHALL CONSIST OF HOMOGENEOUS SOILS FREE OF ORGANIC MATTER AND DEBRIS OR ROCK MATERIALS.
7. ALL EXTERIOR OR EXPOSED CONCRETE SHALL BE CONSOLIDATED BY INTERNAL VIBRATION IN ACCORDANCE WITH A.C.I. 309, RECOMMENDED PRACTICE FOR CONSOLIDATION OF CONCRETE.
8. EXTERIOR BEAMS TO EXTEND N/2 TO N/10 UNDISTURBED SOIL.
9. BEAMS TO BEAR ON UNDISTURBED SOIL.
10. STEEL ROOFS & W/TS TO BE TIED AND SUPPORTED.
11. FLOOR DRAIN
12. ALL REINFORCING STEEL TO BE ASTM-A66, GRADE 60.
13. CONCRETE SHALL BE TYPE 1 PORTLAND CEMENT, 3000 PSI 28 DAY COMPRESSIVE STRENGTH, WITH A MAXIMUM SLUMP OF 4".
14. THE CONCRETE SHALL BE SET IN 10% TENSILE TENSILE, FINISH WITH A CURING COMPOUND CONFORMING TO ASTM C 1084, AND APPLIED AFTER FINISHING IS COMPLETE.
15. THE WARP BARRIER BENEATH THE GROUND FLOOR BUILDING SLAB SHALL BE # 10 POLYETHYLENE AND SHALL BE INSTALLED PER ASTM E-663.
16. ALL FLOOR DRAIN, PLUMBING, ELECTRICAL, AND MECHANICAL AND/OR OTHER SLAB REQUIREMENTS SHALL BE COORDINATED WITH THE ARCHITECTURAL DRAWINGS PRIOR TO POURING CONCRETE.
17. EROSION AND WINDMILL EXCELLENT DRAINAGE OF DISTURBED AREAS DURING CONSTRUCTION SCHEDULE CONSTRUCTION ACTIVITIES WITH RESPECT TO REVEALING WEATHER.
18. ALL CONCRETE WORK, INCLUDING REINFORCEMENT STEEL SHALL BE IN ACCORDANCE WITH ACI-309, LATEST EDITION.
19. ADDITIONAL WATER SHALL NOT BE ADDED AT THE SITE.
20. CONTRACTOR AND/OR CONCRETE SUPPLIER SHALL BE RESPONSIBLE FOR PROVIDING THE EQUIPMENT FOR CURING TESTING AND THE COLLECTION AND TESTING OF SAMPLES.
21. FUTURE ANCHOR BOLTS SHALL BE ASTM-A36, 3/4" DIA. WITH 3" PROTECTION, 12" BURY AND 3" HOOK.
22. RANDED OPENING ANCHOR BOLTS SHALL BE ASTM-A36, 1 1/2" DIA. WITH 2" PROTECTION, 8" BURY AND 2" HOOK.

DESIGN ENGINEER'S NOTES:

1. FOUNDATION/OUTRIG AND DETAILS SHOWN HERE ARE FOR INFORMATION ONLY. THE REQUIRED FOUNDATION LOADS AND PRESSURES AGAINST THE DETAILS AND TRUCK LOAD DEMANDS SHALL BE FURNISHED BY THE OWNER. THE DESIGNER SHALL BE RESPONSIBLE FOR THE DESIGN OF THE FOUNDATION FOR THE ENTIRE LOUISIANA AREA. IT SHALL BE THE RESPONSIBILITY OF THE OWNER TO HAVE THE FOUNDATION DESIGN AND DETAILS REVIEWED BY THE ENGINEER OF RECORD FOR THE INFORMATION PROVIDED BY THE BUILDING SUPPLIER.
2. THE BUILDING SUPPLIER SHALL FURNISH A COMPLETE SET OF DRAWINGS AND LOAD CALCULATIONS FOR REVIEW AND APPROVAL, PRIOR TO FABRICATING THE BUILDING.
3. THE BUILDING SUPPLIER SHALL FURNISH THE OWNER WITH A STAMPED CERTIFICATE OF DESIGN SPECIFYING THE DESIGN LOADS OF THE BUILDING (GROSS FLOOR, LIVE LOAD AND DEAD LOAD AND THE COMBINATION USED). CURRENT CODES NFPA 101 / 202 AND IBC 2002.


TYPICAL SLAB NOTES:

IF DUE TO SPECIFIC SITE CONDITIONS, LOCAL BUILDING PRACTICE OR REGULATIONS, IT IS NECESSARY TO MODIFY OR REDSIGN THE FOUNDATION FOR THIS PLAN, IT IS THE RESPONSIBILITY OF THE OWNER TO HAVE THE FOUNDATION REVISED AT HIS EXPENSE ACCORDINGLY.

THE OWNER SHALL BE RESPONSIBLE FOR THE CORRECT SITTING OF THE BUILDING ON PROPERTY AND FOR COMPLIANCE OF ALL REQUIREMENTS.

THE OWNER SHALL BE RESPONSIBLE FOR CONDITIONS SUCH AS SOIL BEARING CAPACITY, DEPTH OF FROST PENETRATION, WATER TABLE OR UNKNOWN BURIED ITEMS, ETC.

LEGEND:

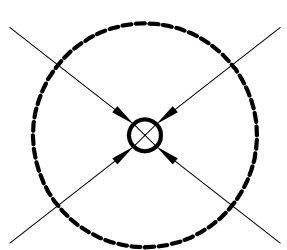

F.D. = FLOOR DRAIN
3" FLOOR DRAIN W/12" ϕ SLOPE
TO DRAIN

3" FLOOR DRAIN W/1/2" SLOPE
TO DRAIN

LA ONE CALL
CALL BEFORE YOU DIG

CALL 1-800-372-3020
(OR CALL 811)
SAVE TIME BY ENTERING TICKETS AT
www.lapnecall.com

(OR CALL 811)

(OR CALL 811)

www.laonecall.com

www.laonecall.com

"FOUNDATION PLAN & DETAILS"
THANK YOU FOR YOUR BUSINESS
MAY GOD BLESS YOU
"HIS REST MATTHEW 11:-28-30"

THANK YOU FOR YOUR BUSINESS
MAY GOD BLESS YOU

MAY GOD BLESS YOU

"HIS REST MATTHEW 11:28-30"

CONTRACTOR TO REVIEW METAL BUILDING SPECIFICATIONS FOR BEAM LAYOUT BEFORE STARTING CONSTRUCTION.

SPECIFICATIONS FOR BEAM LAYOUT
BEFORE STARTING CONSTRUCTION.

BEFORE STARTING CONSTRUCTION.

01
A.4
DETAIL "1"
SCALE : N.T.S.

A.4 SCALE : N.T.S.

02
A.4
DETAIL "2"
SCALE : N.T.S.

SCALE : N.T.S.

"FOUNDATION PLAN"

SCALE: 1/8" = 1'-0"

SULPHUR, LOUISIANA

0

DRAWN BY:

APPROVED

APPROVED BY:

DATE DRAWN:

5/8/2014

DATE APPROVED:

05/2014

JOB#:

DATE:

SIGNATURE:


DOOR SCHEDULE

ROOM NO.	ROOM NAME	FLOOR	BASE	WALL	CEILING	CEILING HEIGHT
		VINYL TILE CARPET WOOD CONCRETE CEREMIC TILE	VINYL NONE	GYPSTUM BOARD WALL PAPER ROUGHT SIDING (T-11) WAINSCOAT 48" HIGH	GYPSTUM BOARD ACOUSTIC TILE WOOD EXPPOSED STRUCTURE	
101	FOYER		X	X		8'-0"
102	UNSEX. BATHROOM		X	X		8'-0"
103	PRIVATE BATHROOM		X	X		8'-0"
104	OFFICE	X	X	X		8'-0"
105	WAREHOUSE	X	X	X		8'-0"
106	STORAGE		X		X	OPEN


WINDOW SCHEDULE			
SYMBOL	TYPE	WINDOW SIZE	HEADER SIZE
1	GLASS STORE FRONT WITH SIDELITES	3'-0" x 7'-0"	
2	METAL DOOR (BY OTHERS)	3'-0" x 7'-0"	
3	INTERIOR SOLID CORE 6-PANEL DOOR	3'-0" x 6'-8" L.H.I.S.	2" x 6"
4	INTERIOR SOLID CORE 6-PANEL DOOR	3'-0" x 6'-8" R.H.I.S.	2" x 6"
5	2 HR FIRE RATED METAL DOOR	3'-0" x 7'-0" R.H.I.S.	2" x 6"
6	OVERHEAD PANEL ROLL-UP DOOR	12'-0" x 14'-0"	
7			
8			
9			
10			
11			
12			
13			
14			
15			

SYMBOL	TYPE	WINDOW SIZE	HEADER SIZE
1		4'-0" x 4'-0"	
2	STORE FRONT WINDOW	3'-0" x 6'-0"	
3			
4			
5			
6			
7			
8			
9			
10			
11			
12			
13			
14			
15			


1. ALL FIRE WALLS WILL CONSIST OF METAL STUDS.
2. FIRE WALL MUST GO TO ROOF DECK WITH FIRE CAULK ALONG ROOF DECK AND AROUND ANY PENETRATIONS.

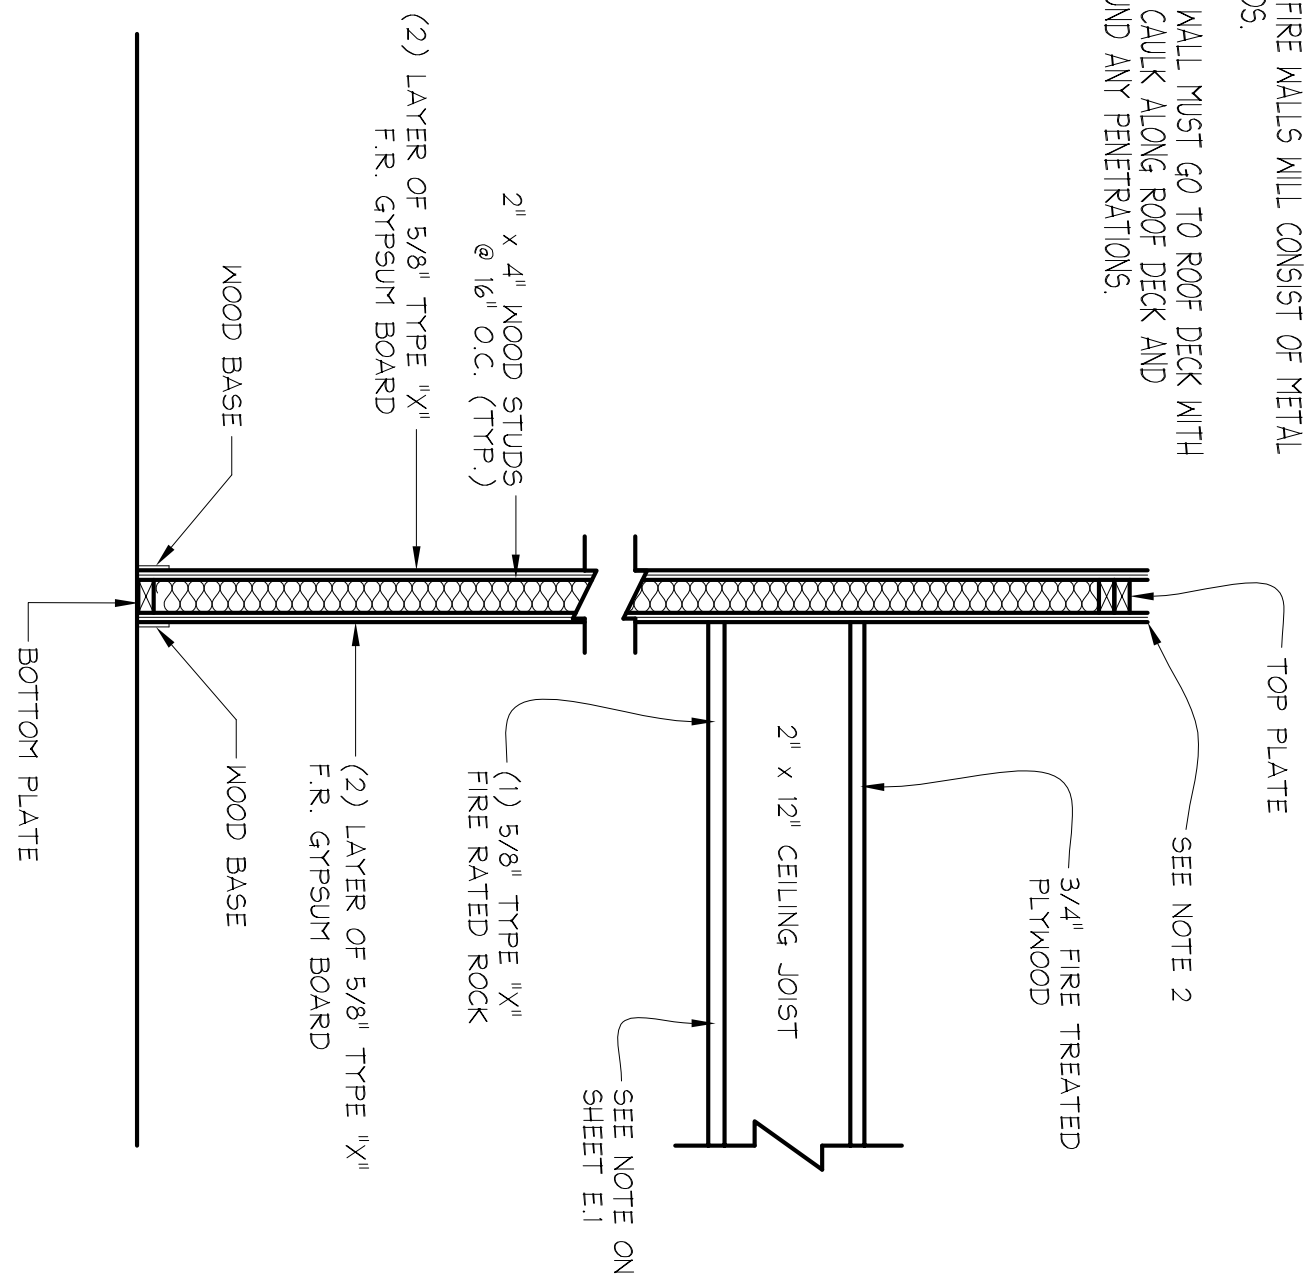


DETAIL "6"
(2) HOUR FIRE RATED CEILING &
WALL SECTION DETAIL
SEE UL LISTING 263 DESIGN NO. U304

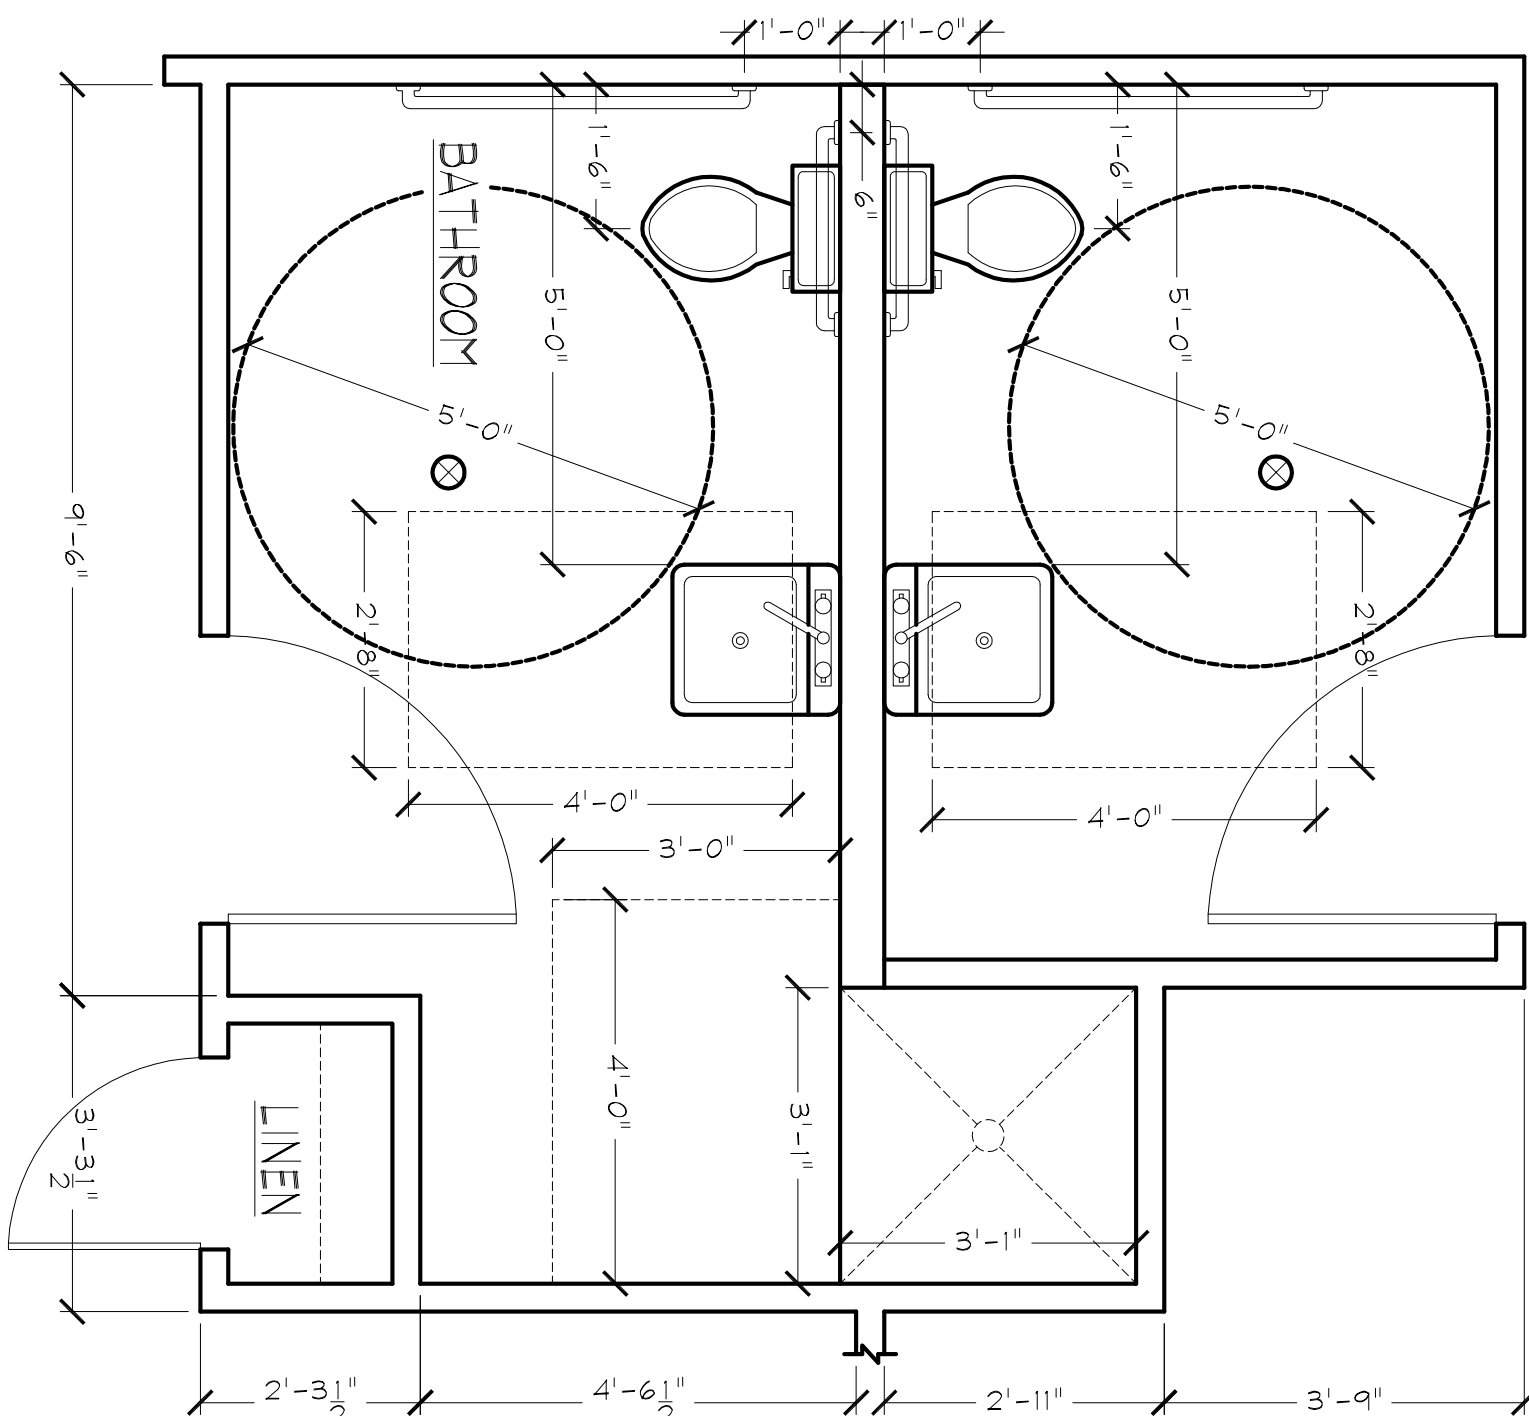

DETAIL "A"
SCALE: 1/2" = 1'-0"

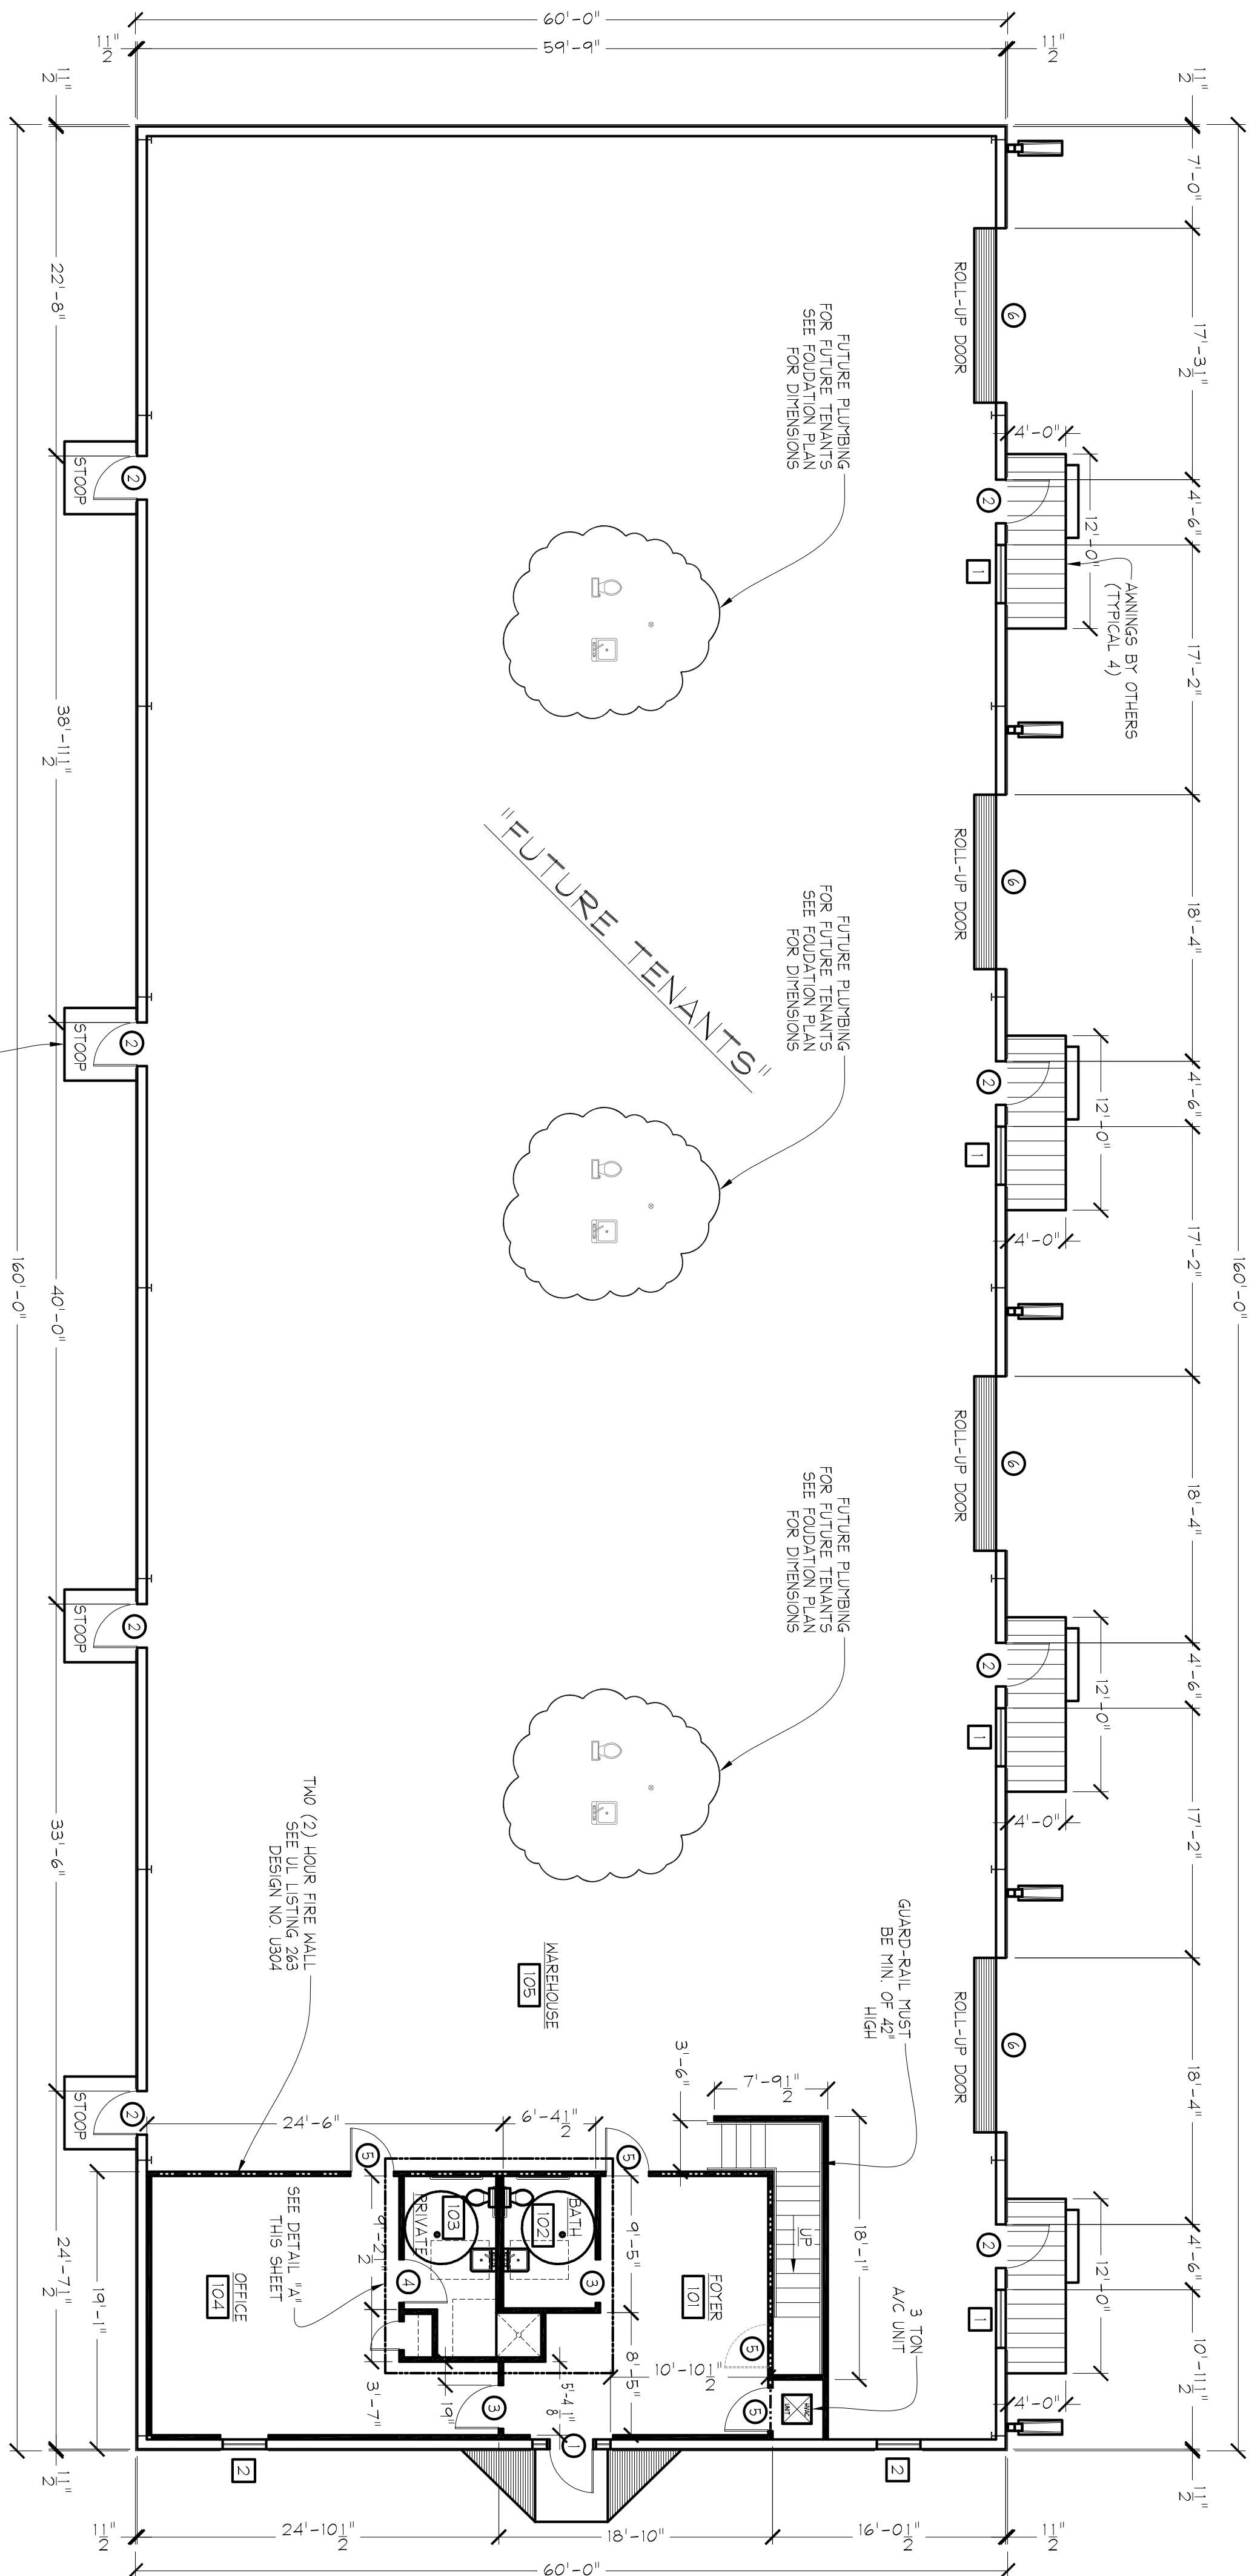

FLOOR PLAN

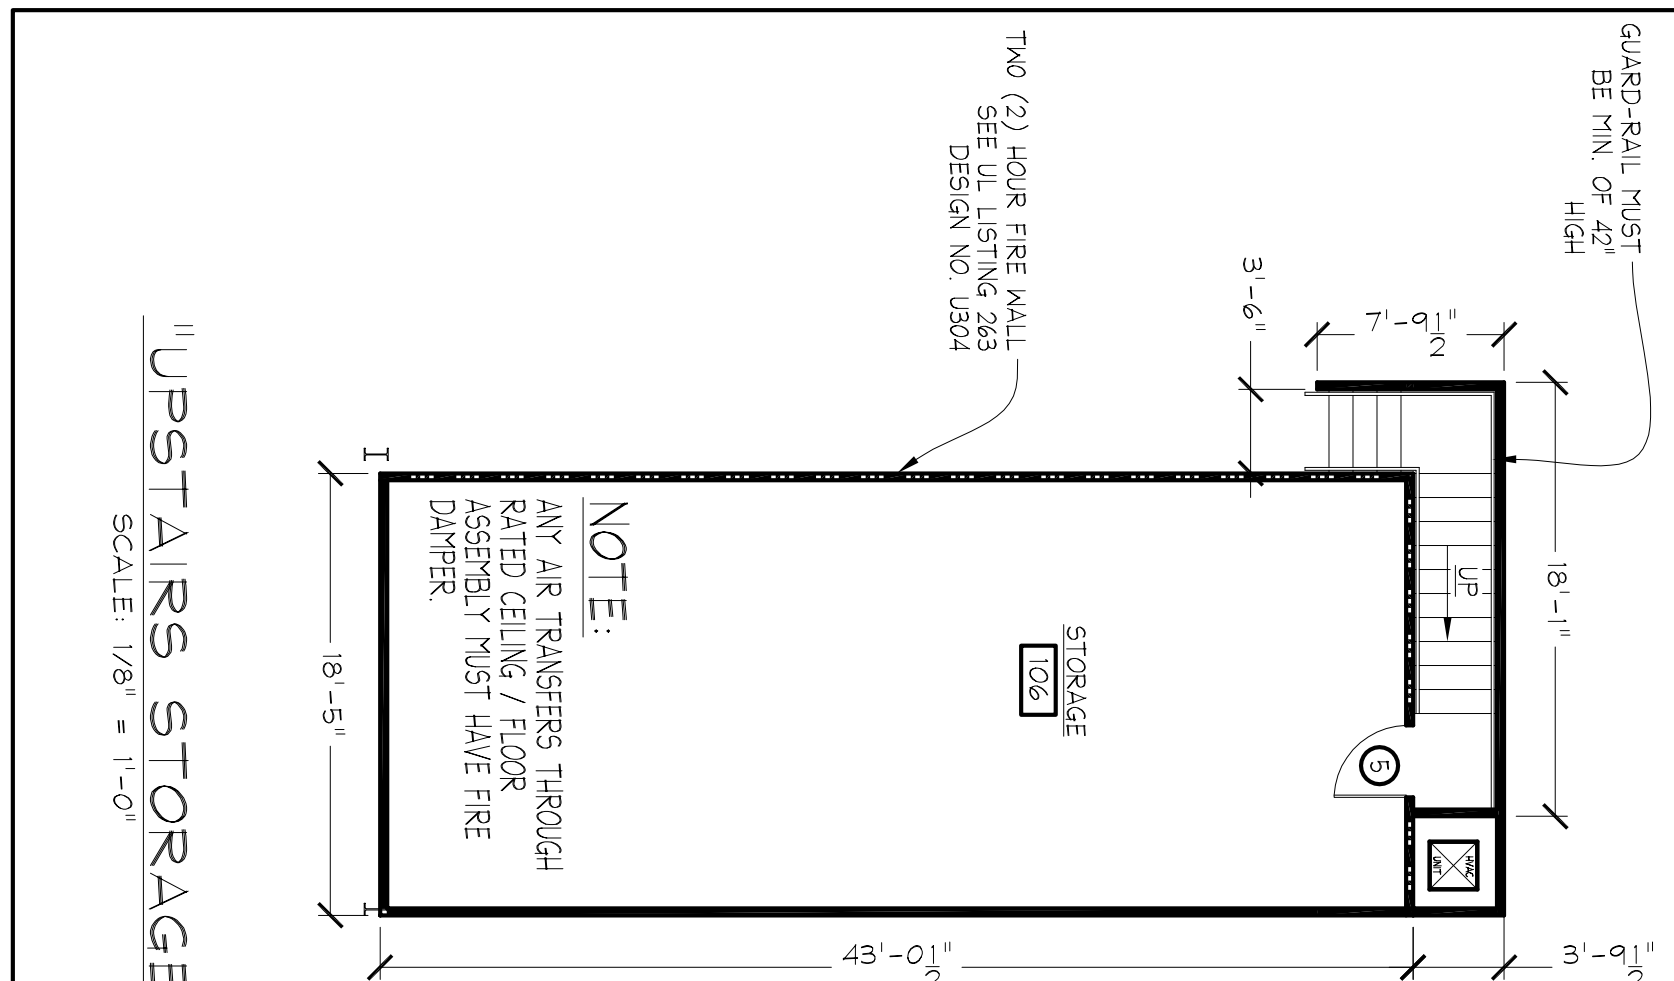

"UPSTAIRS STORAGE"

LEGEND:

-  2 HOUR FIRE WALL
 2" x 4" STUD WALL
 2" x 6" STUD WALL

LA ONE CALL
CALL BEFORE YOU DIG
1-800-272-5020
(OR CALL 811)
SAVE TIME BY ENTERING TICKETS AT
www.laonecall.com

"FLOOR PLAN"
THANK YOU FOR YOUR BUSINESS
MAY GOD BLESS YOU
"HIS REST MATTHEW 11:-28-30"

DATE: _____

SIGNATURE:

DRAWN BY:

APPROVED

DATE DRAWN:	5/8/2014
DATE APPROVED:	05/2014

SULPHUR, LOUISIANA


0

GENERAL ELECTRICAL NOTES

1. THE LAYOUT SHOWN IS A GUIDE ONLY AND MAY BE MODIFIED AS REQUIRED TO FIT WITHIN STRUCTURAL ELEMENTS AND WALLS. MEET CODE OR MANUFACTURER REQUIREMENTS. VERIFY SIZES AND LOCATIONS.
2. ALL WIRING AND INSULATION SHALL BE IN STRICT ACCORDANCE WITH THE NATIONAL ELECTRICAL CODE, LATEST EDITION, WITH LIFE SAFETY CODE (IF) (2002 EDITION) AND IBC 2002.
3. THE ELECTRICAL CONTRACTOR SHALL COORDINATE INSTALLATION & INFORMATION WITH OTHER TRADES INVOLVED (CARPENTERS, PLUMBING, HVAC, ETC.).
4. ALL ELECTRICAL WORK PERFORMED UNDER DIRECT SUPERVISION OF A LICENSED ELECTRICAL FIRM. IF THE SPECIFICATIONS ARE EQUAL AND OWNER AGREES.
5. ACCEPTABLE ALTERNATE MANUFACTURERS MAY BE USED FOR LISTED FIXTURE AND MOUNTING DETAILS.
6. SEE OWNER AND GENERAL CONTRACTOR FOR EXACT TYPE OF FIXTURE AND MOUNTING DETAILS.
7. ANY FEES ASSOCIATED WITH CONTRACTOR AND INSPECTION SHALL BE BORNE BY THE CONTRACTOR. CONTRACTOR TO DELIVER TO THE OWNER A FINISHED BUILDING, READY FOR OCCUPANCY AND 100% OPERATION.
8. ALL PANELBOARDS AND EMERGENCY LIGHTING DISCONNECT SWITCHES SHALL BE LABELED WITH RESPECT TO THEIR TITLE, VOLTAGE & PHASE. I.E. PANEL X" 120V/208/3P.
9. PANELBOARDS SHALL CONTAIN A TYPE WRITTEN DIRECTORY WITH A PLASTIC COVER AFFIXED TO THE INSIDE DOOR.
10. ANY DEVIATION FROM PLANS WITHOUT PRIOR APPROVAL OF THE OWNER SHALL BE CONSIDERED A VIOLATION OF THE CONTRACT. THE CONTRACTOR SHALL CORRECT SUCH DEVIATION TO THE SATISFACTION OF THE OWNER. SHALL BE BORNE BY THE CONTRACTOR.
11. ANY COSTS INCURRED DUE TO LACK OF COOPERATION AMONG THE TRADES SHALL BE BORNE BY THE CONTRACTOR.
12. CONTRACTORS SHALL VERIFY SERVICE VOLTAGE WITH UTILITY COMPANY, AND REVERSE AND BALANCE PANEL AS REQUIRED PER CODE.
13. CONTRACTOR SHALL VERIFY LOCATION OF PARKING LOT LIGHTS AND Pylon SIGNS ON INDIVIDUAL SITE PLAN.
14. ALL REPORT EQUIPMENT ON ROOF OR GROUNDS SHALL HAVE A DISCONNECT SWITCH AT EACH PIECE OF EQUIPMENT. FURNISH FUSED DISCONNECTS AS REQUIRED BY N.E.C. BE WEATHERPROOF.
15. ALL EXTERIOR RECEPTACLES, JUNCTION BOXES AND EQUIPMENT SHALL BE WEATHERPROOF.
16. IT SHALL BE THE CONTRACTOR'S RESPONSIBILITY, PRIOR TO ANY INDIVIDUAL CIRCUIT'S INSTALLATION, TO VERIFY WITH ALL OTHER TRADES CONCERNED THAT THE CIRCUIT WITH DRIVES, AS DRAWN IS ADEQUATE IN SIZE AND MAKE-UP FOR THE EQUIPMENT'S REQUIREMENTS. THE CONTRACTOR SHALL BE RESPONSIBLE FOR ANY CONFLICT IN VOLTAGE, PHASE OR LOAD IS ENCOUNTERED WHICH WOULD ALTER THE CIRCUIT SIZE. THIS CONTRACTOR SHALL NOTIFY THE ENGINEER OR OWNER IMMEDIATELY. THE CONTRACTOR SHALL BE RESPONSIBLE FOR THE CORRECTION FOR ANY SUBSEQUENT CIRCUIT CHANGE DIRECTLY UPON THE CONTRACTOR.
17. ALL ITEMS IN THE NOTES, SCHEDULES AND LEGEND MAY NOT NECESSARILY APPEAR ON THESE DRAWINGS.
18. MINIMUM WIRE SIZE SHALL BE #12 AWG AND MINIMUM CONDUIT SIZE SHALL BE 3/4" C". ALL WIRING SHALL BE RUN IN CONDUIT OR PVC CABLE.
19. THE ONLY CIRCUITS THAT WILL BE HAVING SWITCHES IS SHOWN & LOCATED ON THE LAYOUT. ALL OTHERS WILL BE WIRED DIRECTLY TO DIST. PANELS.
20. WIRING RUNS IN EXCESS OF 90'-0" (ONE WAY) SHALL BE SIZED PER THE N.E.C. MAXIMUM 25 V/D.
21. ALL BOXES FOR RECEPTACLES, BLANK, INTERMITTENT & ETC. IN TWO (2) HOUR FIRE WALL NEED TO BE WRAPPED IN FIRE PUTTY PADS PER UL/CULV/R3240.
22. ALL PENETRATIONS IN TWO (2) HOUR FIRE WALL MUST BE FIRE CAULKED WITH APPROVED FIRE CAULK PER UL/WHENL-2145.
23. WHERE POSSIBLE, MATERIALS AND EQUIPMENT USED IN THIS PROJECT SHALL BE MANUFACTURED IN THE UNITED STATES OF AMERICA.
24. ALL UNDERGROUND WIRING SHALL BE RUN IN PVC CONDUIT AND ALL ABOVE GROUND EXTERIOR WIRING SHALL BE RUN IN RIGID CONDUIT.
25. ELECTRIC OUTLET BOXES AND SWITCH BOXES CANNOT BE PLACED BACK-TO-BACK IN FIRE WALLS.


II ELECTRICAL FEED DETAIL II

SCALE: N.T.S.

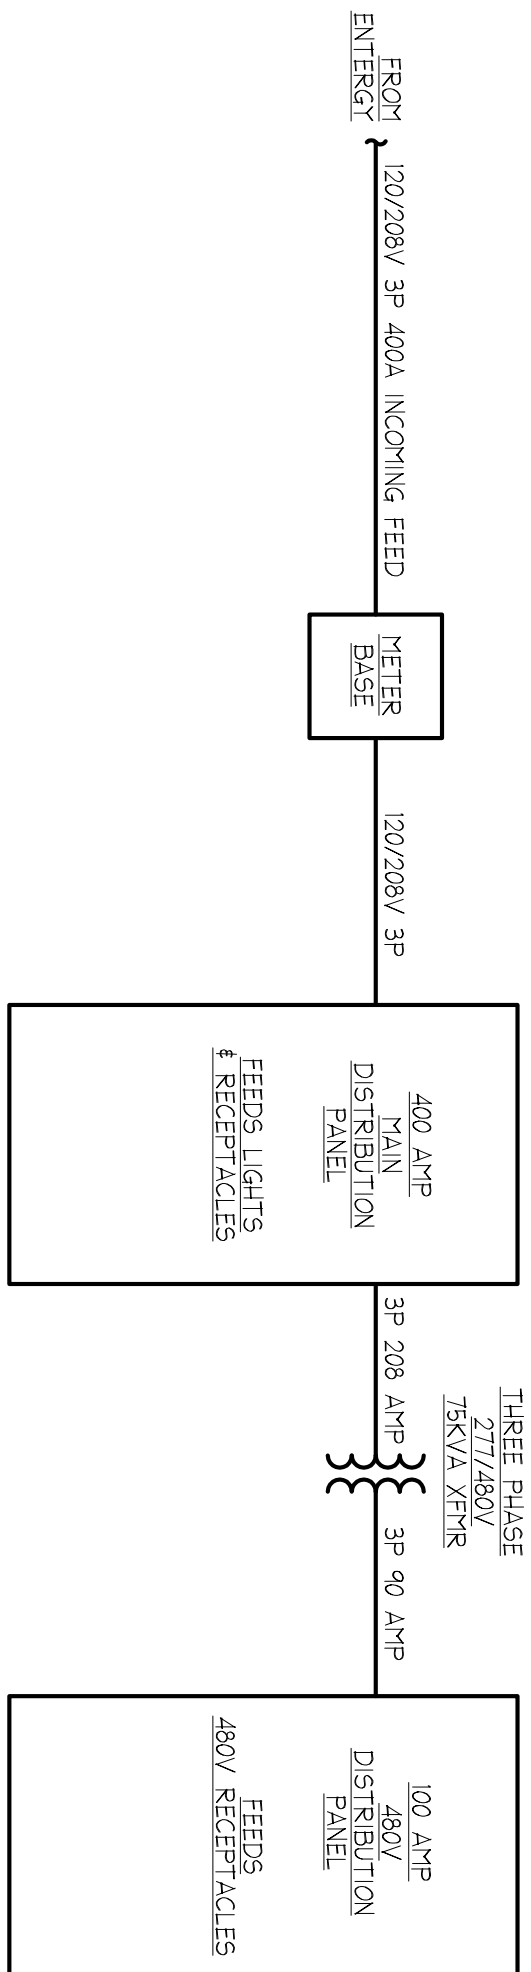

II UPSTAIRS STORAGE II


SCALE: 1/8" = 1'-0"

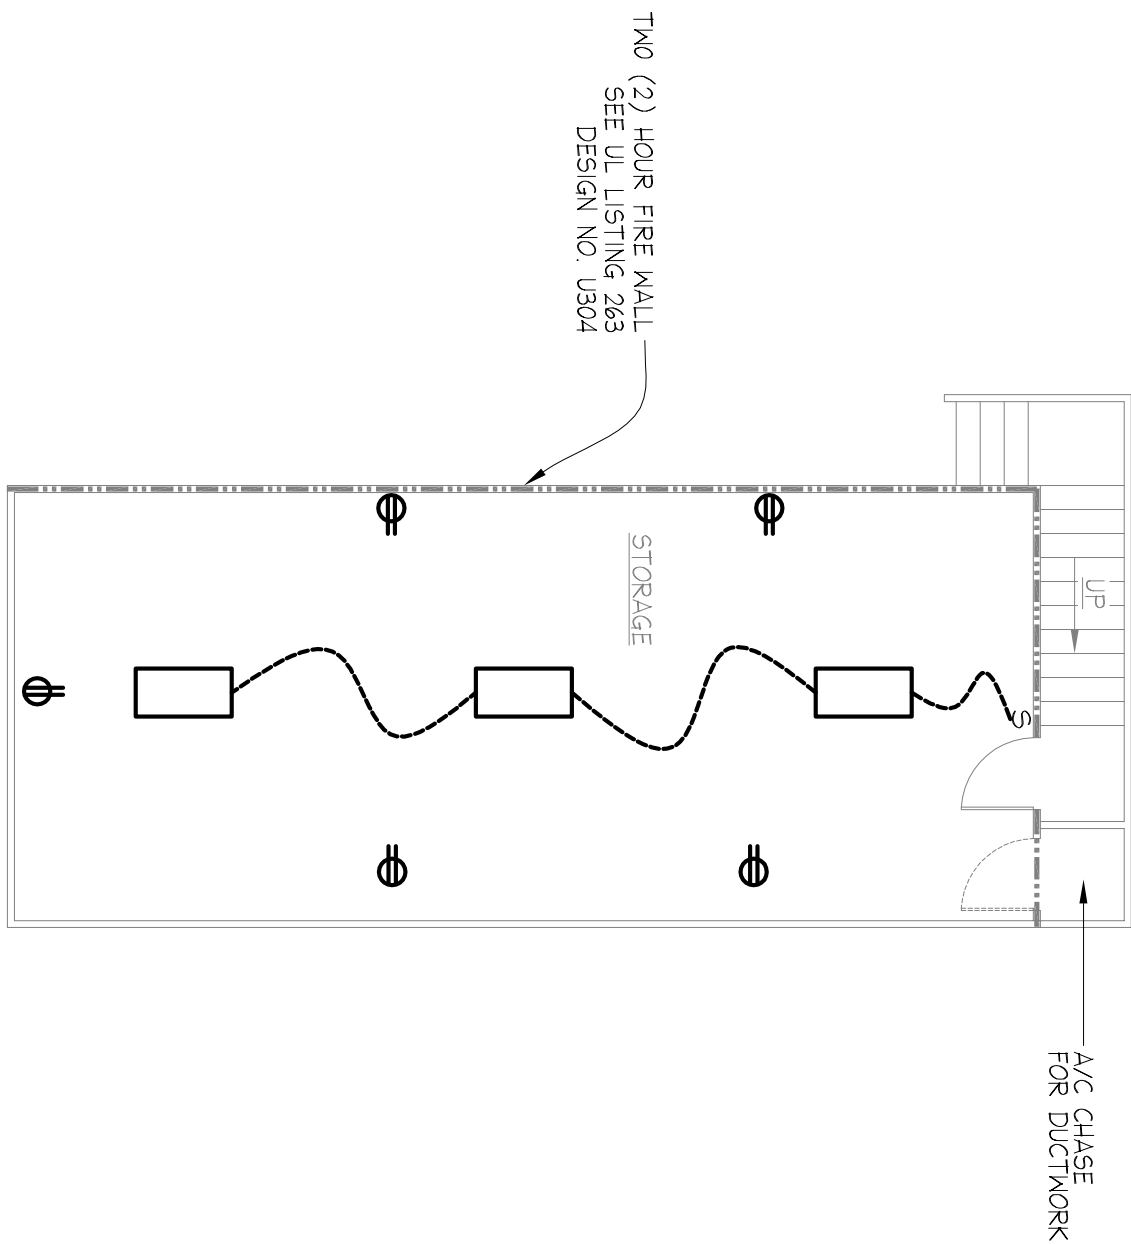

LEGEND:

- 100VAC GROUND FAULT CIRCUIT INTERRUPTER
- 100VAC CEILING PLUG CIRCUIT INTERRUPTER
- 100VAC RECEPTACLE
- 220VAC RECEPTACLE
- 480VAC RECEPTACLE
- PHONE JACK
- CAT 6
- 2-WAY SWITCH
- 3-WAY SWITCH
- 4-WAY SWITCH
- FAN SWITCH
- VENT FAN
- BASIC LIGHT FIXTURE
- RECESS LIGHT
- 220V POWER CIRCUIT
- 110V POWER CIRCUIT
- EMERGENCY EXIT COMBO W/BACKUP LIGHTS
- 2 X 4 FLUORESCENT LIGHTING FIXTURE (4 BULBS)
- TE MATT
- WALL PLACK
- CEILING FAN

NOTE:
ANY PENETRATIONS OF RATED CEILING / FLOOR ASSEMBLY MUST HAVE SIMILAR FIRE RATING.

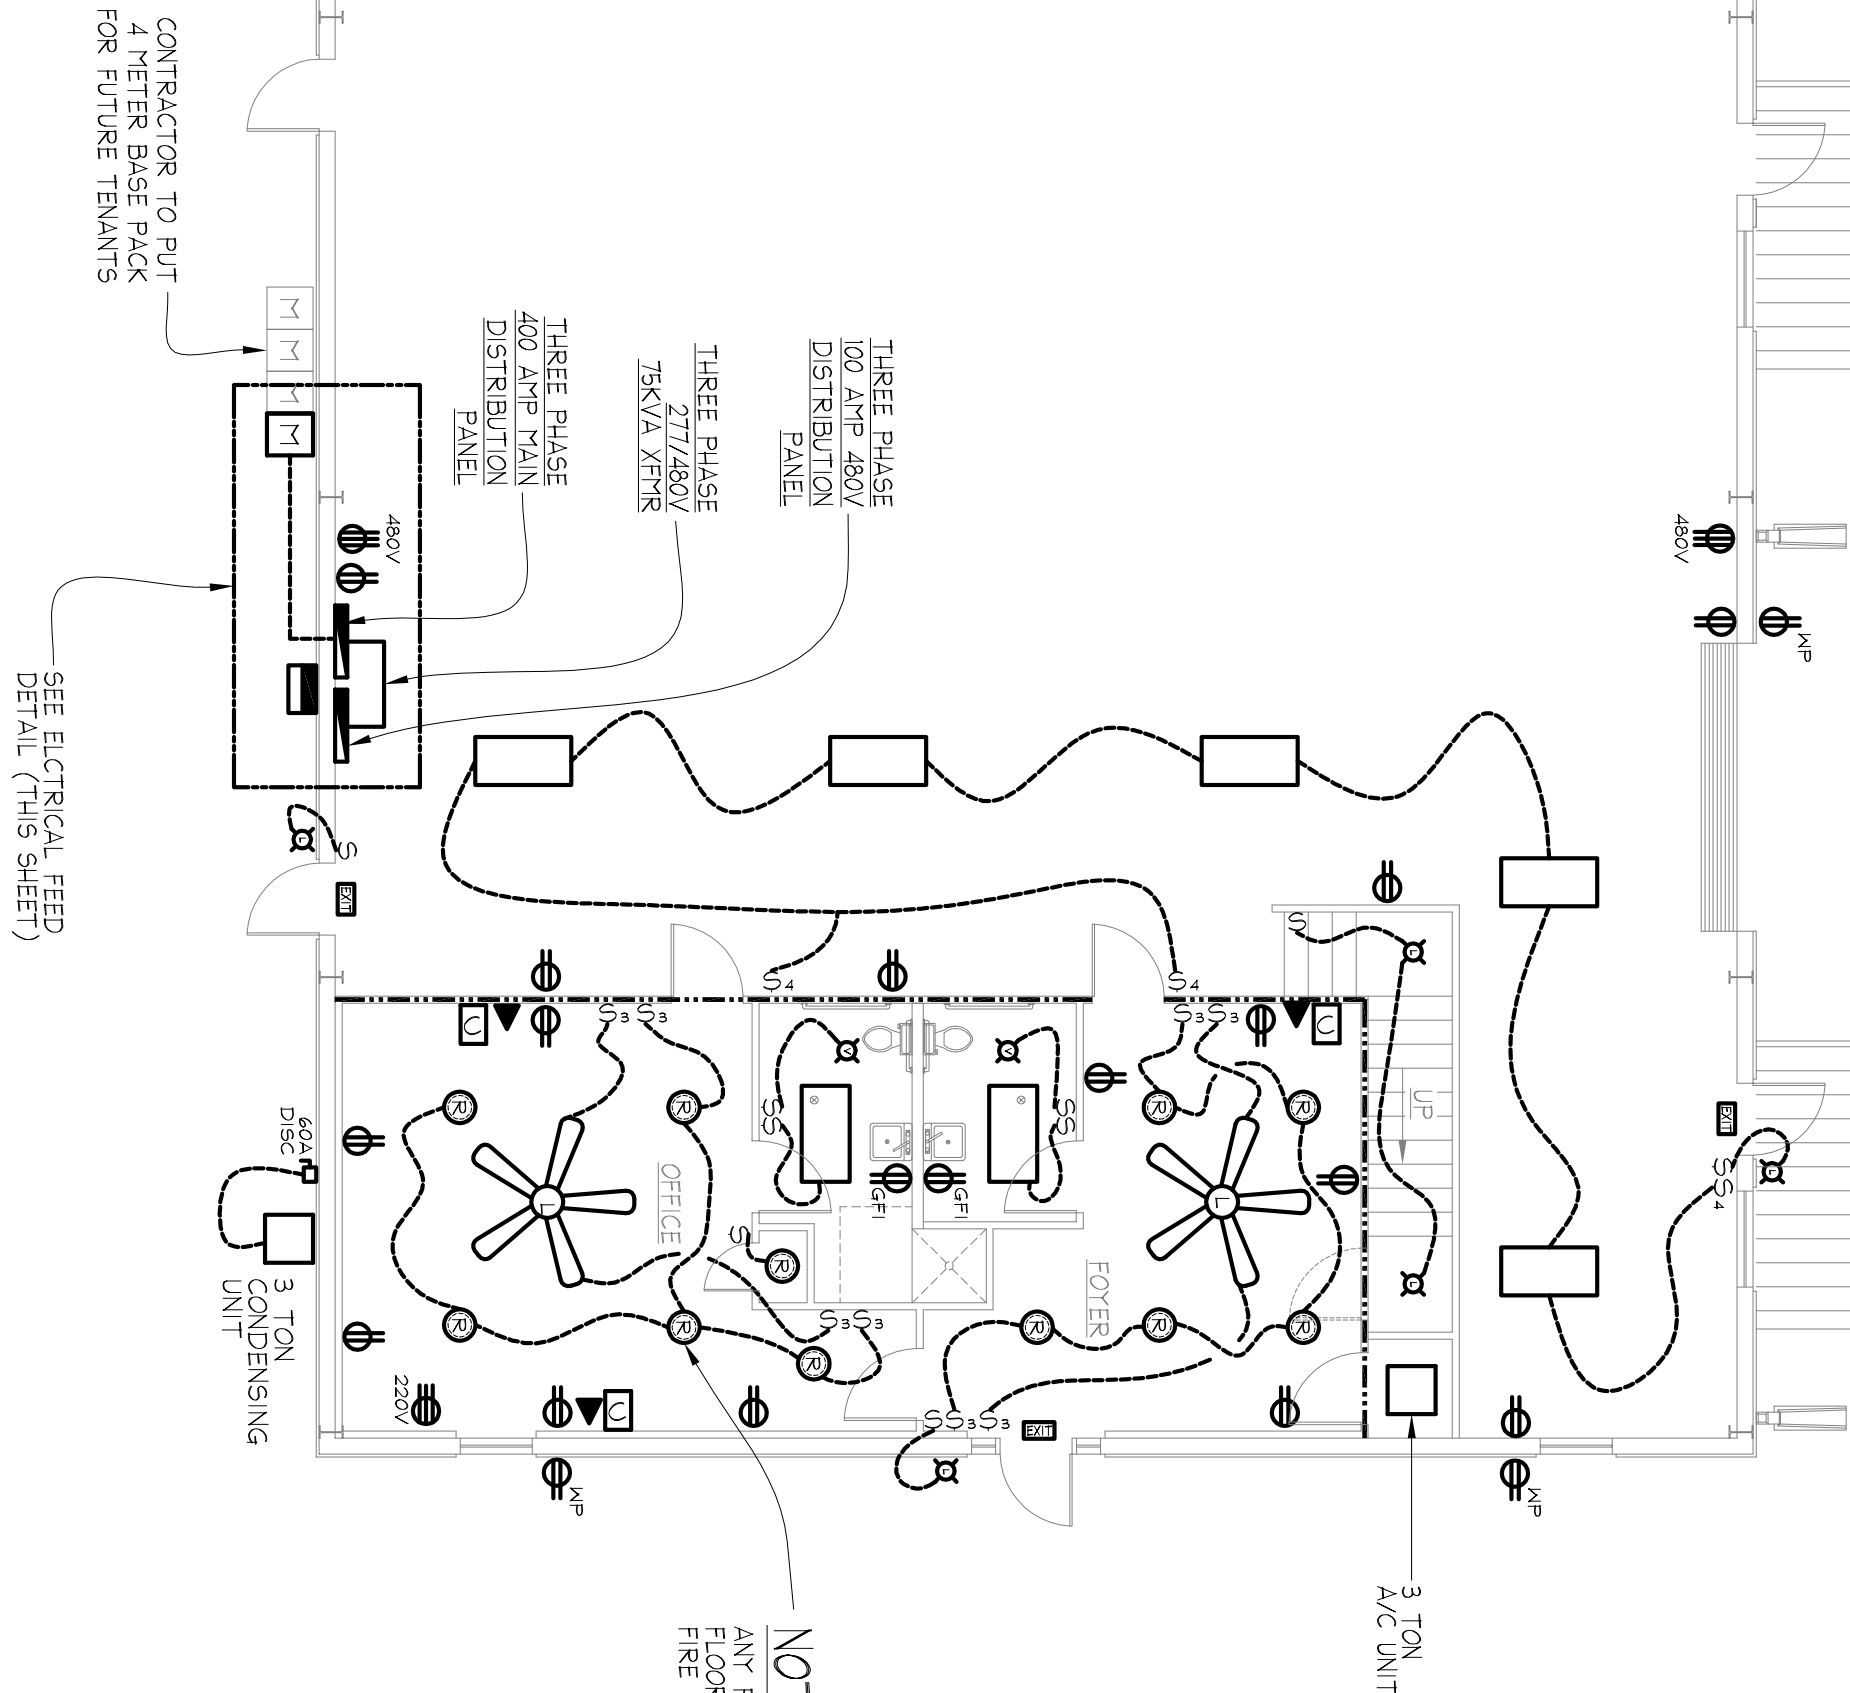

"FUTURE TENANTS"

II ELECTRICAL PLAN II

SCALE: 1/8" = 1'-0"

LA ONE CALL

CALL BEFORE YOU DIG
1-800-272-3020
(OR CALL 811)
SAVE TIME BY ENTERING TICKETS AT
www.laonecall.com

"ELECTRICAL PLAN"
THANK YOU FOR YOUR BUSINESS
MAY GOD BLESS YOU
"HIS REST MATTHEW 11:-28-30"

SULPHUR, LOUISIANA

SHEET
E1

SIGNATURE:

DATE:

DRAWN BY:

APPROVED BY:

DATE DRAWN:

DATE APPROVED:

JOB#:

5/8/2014

05/2014

0