


REV	DESCRIPTION	BY	DATE
A	INITIAL CONCEPT	DC	4/05/13
B	UPDATED QUANTITIES AND LOGO	DC	4/05/13

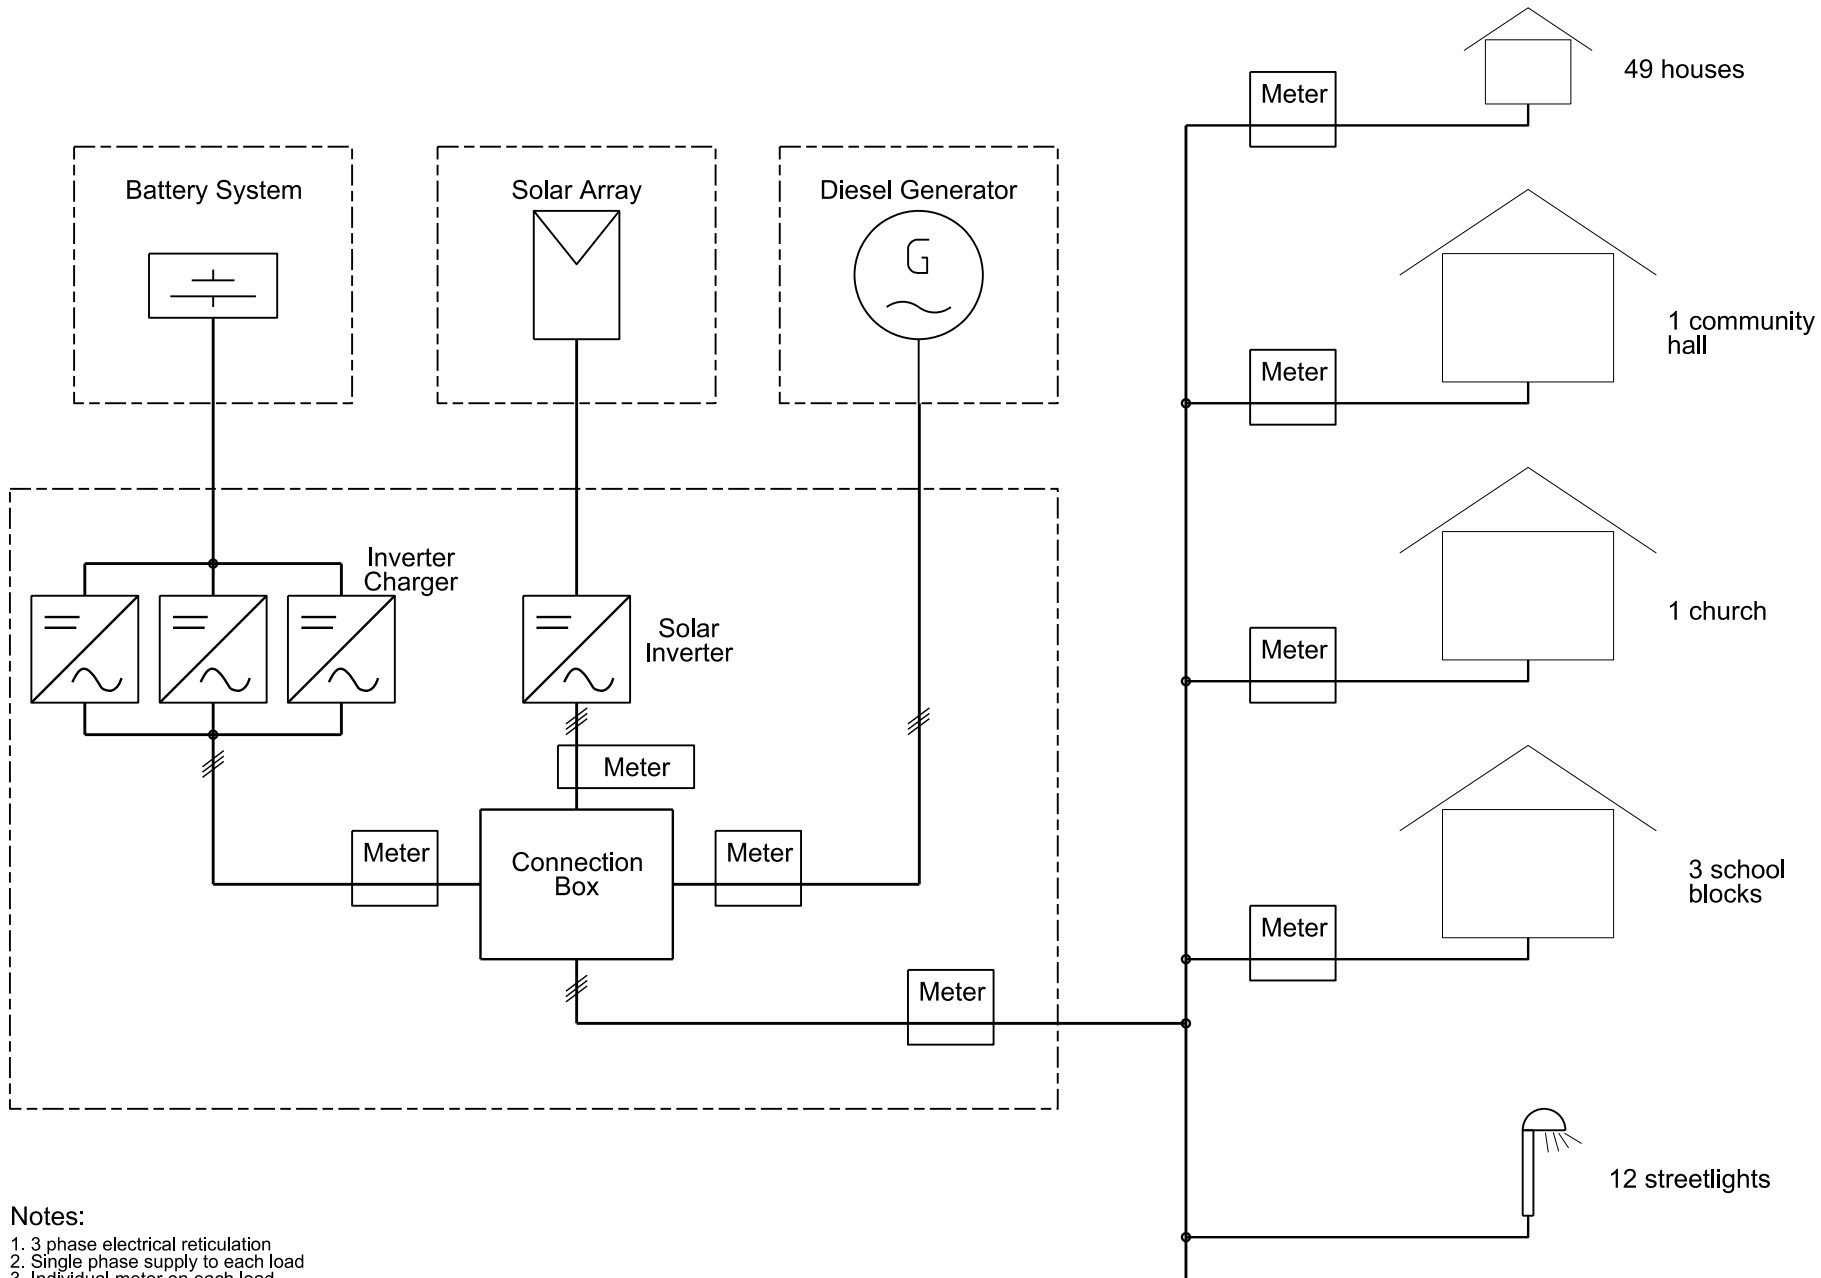

- Notes:**
1. 3 phase electrical reticulation
  2. Single phase supply to each load
  3. Individual meter on each load
  4. Streetlights are not metered



**CONDON CONSULTING**  
0439 898 145    d@condon@gmail.com

Project: MGE PROPOSED HYBRID POWER SYSTEM

Sheet: SINGLE LINE DIAGRAM

Status: FOR INFORMATION

PROJECT	DRAWING No.	REV No.
MUA1301	E-01	B

DRAWN: DWC

DATE: 6/05/2013

SCALE: NTS

CHECKED: DWC

APPROVED: