

PROPOSED EXTERIOR ELEVATION
SCALE 1/4" = 1'-0"

THE OWNER AND CONTRACTOR ARE REQUIRED TO REVIEW AND VERIFY THE DESIGN AND DIMENSIONS, REFLECTED ON THE PLANS AND/OR DOCUMENTS, BEFORE PURCHASING MATERIALS OR COMMENCEMENT OF CONSTRUCTION.

I HEREBY DO NOT WARRANT THESE PLANS AND/OR DOCUMENTS FOR ENGINEERING OR ARCHITECTURAL APPLICATIONS. ANY USE THEREOF IS STRICTLY PROHIBITED. RESPONSIBILITY OF THOSE PURPOSES IS ASSUMED BY THE OWNER AND/OR CONTRACTOR OF THE FACILITY.

THE DRAWING AND DIMENSIONS SHOWN HEREON ARE FOR VISUAL PURPOSES ONLY AND MAY NOT BE TO ANY SCALE.
SIGNATURE/DATE: _____

"EXTERIOR ELEVATION"
THANK YOU FOR YOUR BUSINESS
MAY GOD BLESS YOU
"HIS REST MATTHEW 11:28-30"


DRAWN BY:	DATE DRAWN: 05/2015
APPROVED BY:	DATE APPROVED:
	JOB#: _____
LAKE CHARLES, LOUISIANA	
	0

SHEET
A.1

ROOM No.	ROOM NAME	FLOOR	BASE	WALL	CEILING	CEILING HEIGHT
101	HUD ROOM		VINYL TILE			10'-0"
102	GREAT ROOM	X	CARPET			10'-0"
103	LAUNDRY ROOM	X	WOOD			10'-0"
104	MASTER CLOSET	X	STAINED CONCRETE			10'-0"
105	MASTER BATHROOM	X	CEREMIC TILE			10'-0"
106	GUN SAFE ROOM	X	WOOD			10'-0"
107	MASTER BEDROOM	X	WOOD			10'-0"
108	HALLWAY	X	VINYL			10'-0"
			NONE			
			GYPSUM BOARD			
			WALL PAPER			
			ROUGH SIDING (T-11)			
			WAINSCOT 48" HIGH			
			GYPSUM BOARD			
			ACOUSTIC TILE			
			WOOD			
			EXPOSED STRUCTURE			
						FIELD VERIFY FOR DITCHWORK

FINISHED ROOM SCHEDULE

PROPOSED FLOOR PLAN FOR NEW ADDITION
SCALE 1/4" = 1'-0"

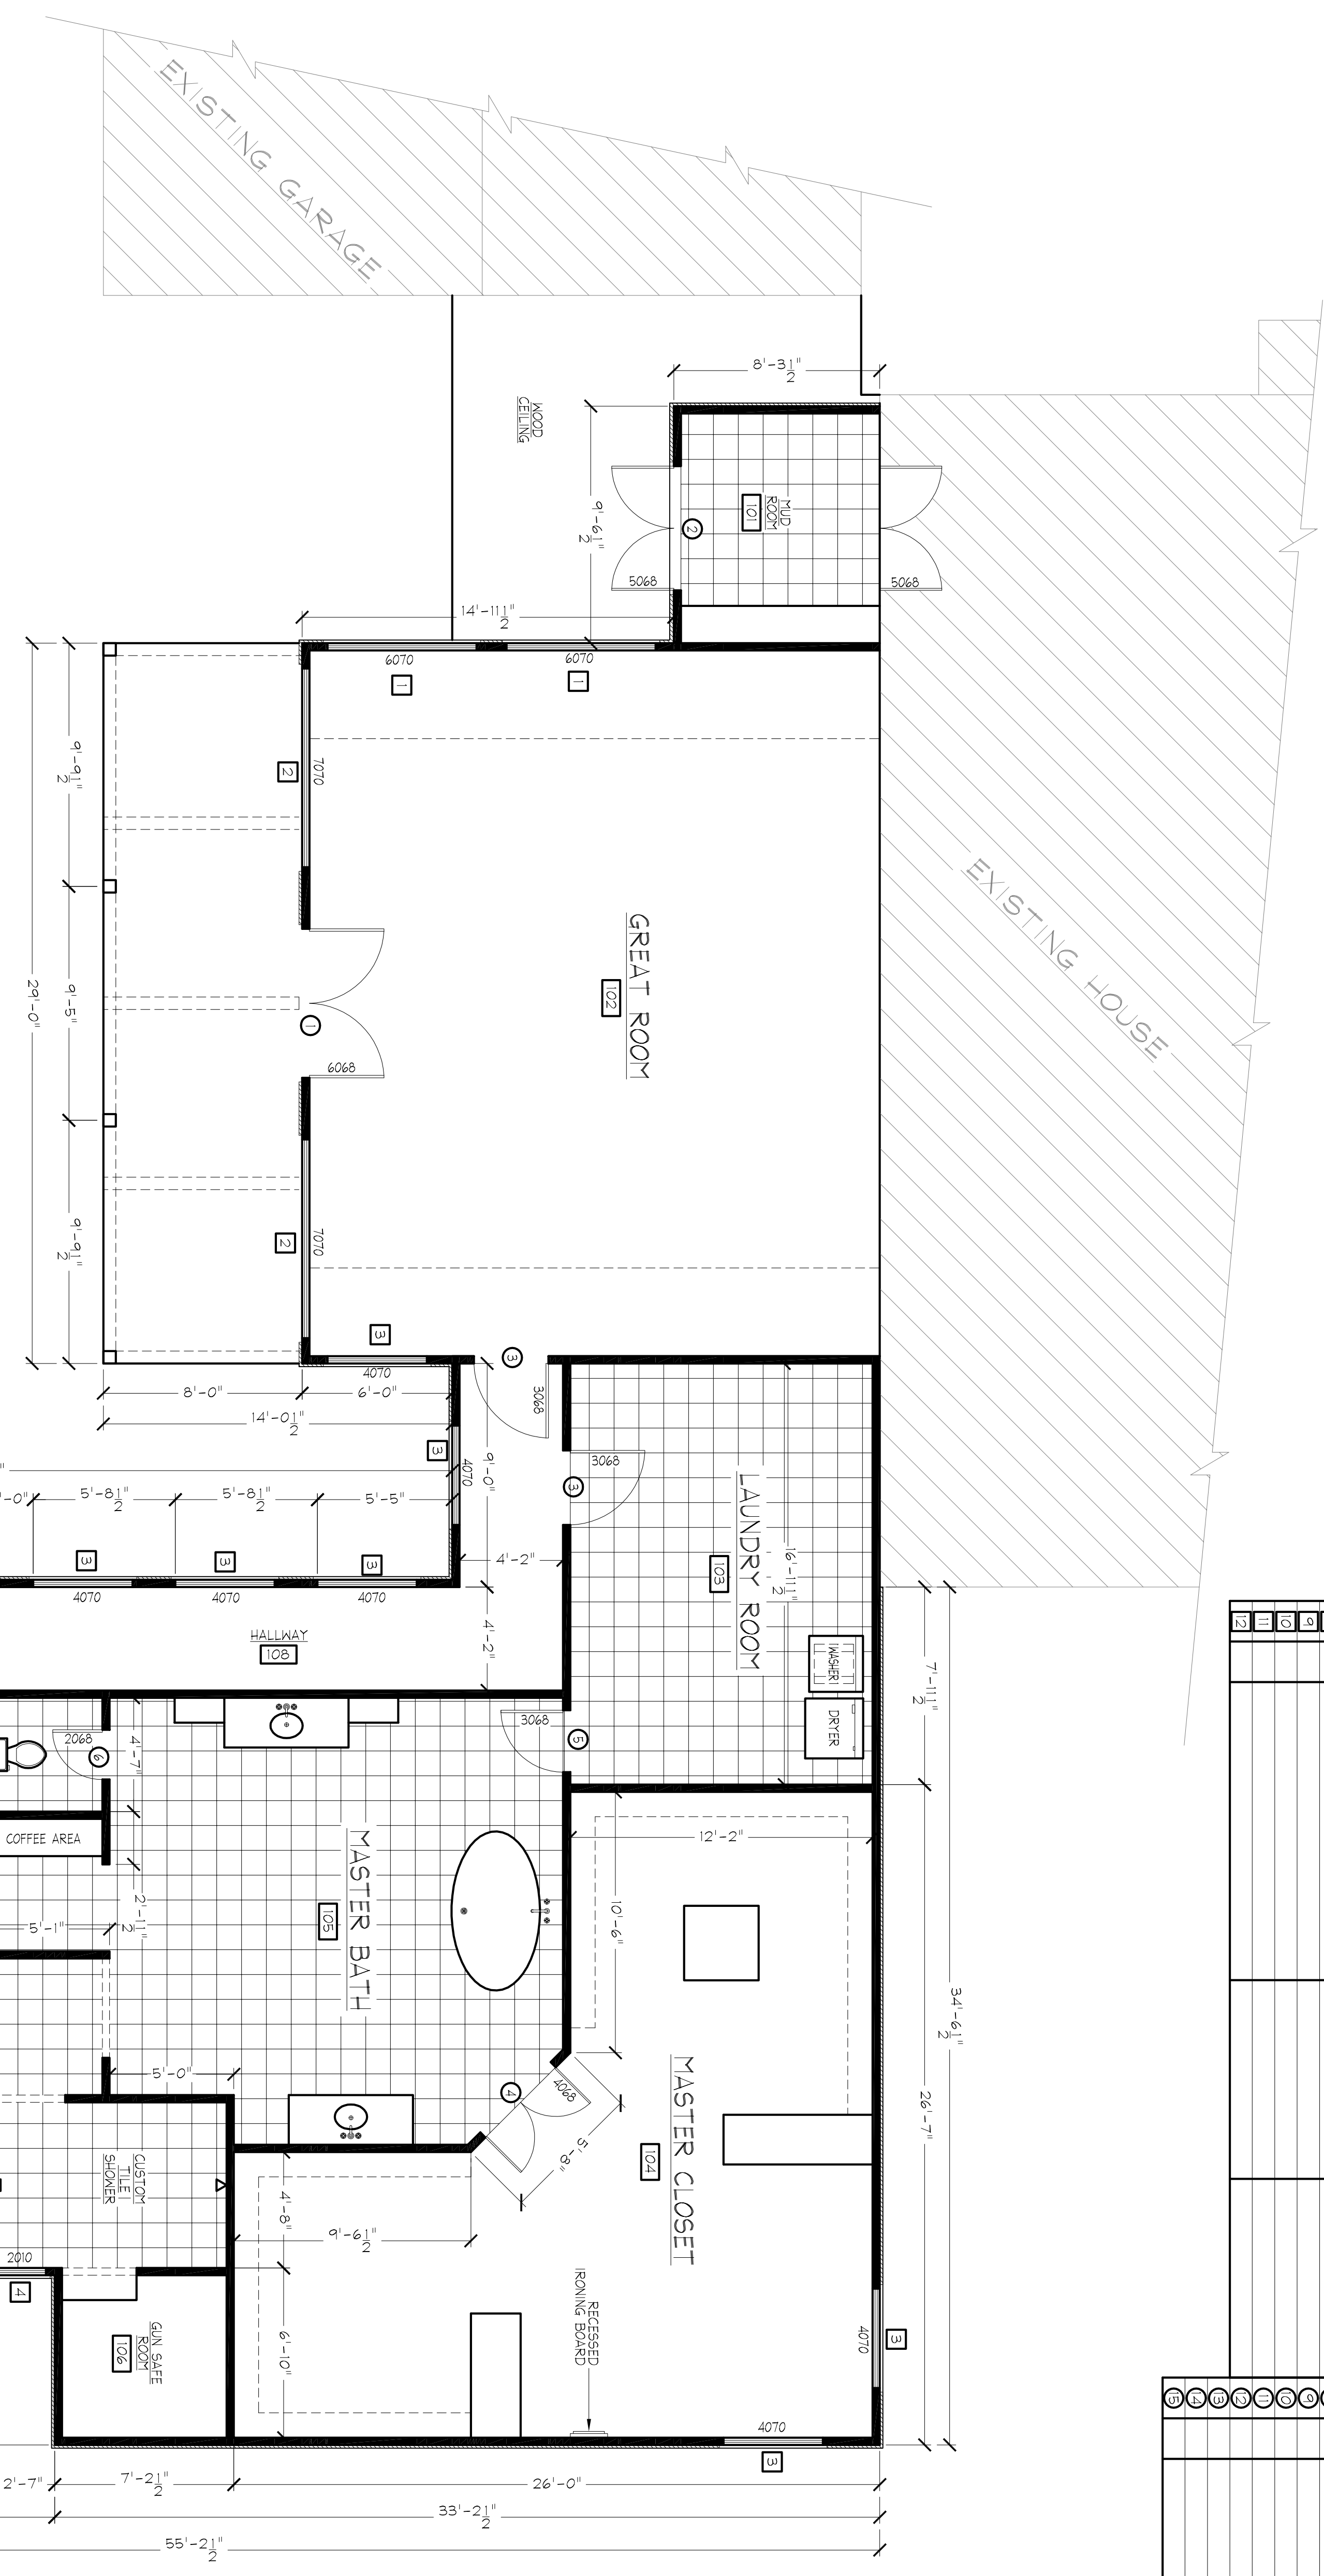

WINDOW SCHEDULE				DOOR SCHEDULE			
SYM QTY	TYPE	WINDOW SIZE	HEADER SIZE	SYM QTY	TYPE	DOOR SIZE	HEADER SIZE
1	FIXED GLASS	6'-0" x 7'-0"	2" x 12"	1	EXTERIOR FRENCH DOOR SOLID WOOD W/ GLASS	6'-0" x 6'-8"	2" x 12"
2	FIXED GLASS	7'-0" x 7'-0"	2" x 12"	2	EXTERIOR FRENCH DOOR SOLID WOOD W/ GLASS	5'-0" x 6'-8"	2" x 12"
3	FIXED GLASS	4'-0" x 7'-0"	2" x 12"	3	INTERIOR COLONIAL STYLE 6-PANEL DOOR	3'-0" x 6'-8" L.H. I.S.	2" x 6"
4	FIXED GLASS	2'-0" x 1'-0"	2" x 12"	1	INTERIOR GLASS FRENCH DOOR	4'-0" x 6'-8"	2" x 6"
5				1	INTERIOR COLONIAL STYLE 6-PANEL DOOR	3'-0" x 6'-8" R.H. I.S.	2" x 6"
6				1	INTERIOR COLONIAL STYLE 6-PANEL DOOR	2'-0" x 6'-8" R.H. I.S.	2" x 6"
7				1	BARN STYLE SLIDING DOOR	3'-6" x 8'-0"	2" x 12"
8							
9							
10							
11							
12							
13							
14							
15							
16							
17							
18							
19							
20							

THE OWNER AND CONTRACTOR ARE REQUIRED TO REVIEW AND VERIFY THE DESIGN AND DIMENSIONS, REFLECTED ON THE PLANS AND/OR DOCUMENTS, BEFORE PURCHASING MATERIALS OR COMMENCEMENT OF CONSTRUCTION.

I HEREBY DO NOT WARRANT THESE PLANS AND/OR DOOR SCHEDULES FOR ENGINEERING OR ARCHITECTURAL APPLICATIONS. ANY USE THEREOF IS STRICTLY PROHIBITED. RESPONSIBILITY OF THOSE PURPOSES IS ASSUMED BY THE OWNER AND/OR CONTRACTOR OF THE FACILITY.


THE DRAWING AND DIMENSIONS SHOWN HEREON ARE FOR VISUAL PURPOSES ONLY AND MAY NOT BE TO ANY SCALE.

SIGNATURE/DATE: _____


DRAWN BY:	DATE DRAWN: 05/2015
APPROVED BY:	DATE APPROVED:
	JOB#:
LAKE CHARLES, LOUISIANA 0	

"FLOOR PLAN"
THANK YOU FOR YOUR BUSINESS
MAY GOD BLESS YOU
"HIS REST MATTHEW 11:28-30"

SHEET
A.2

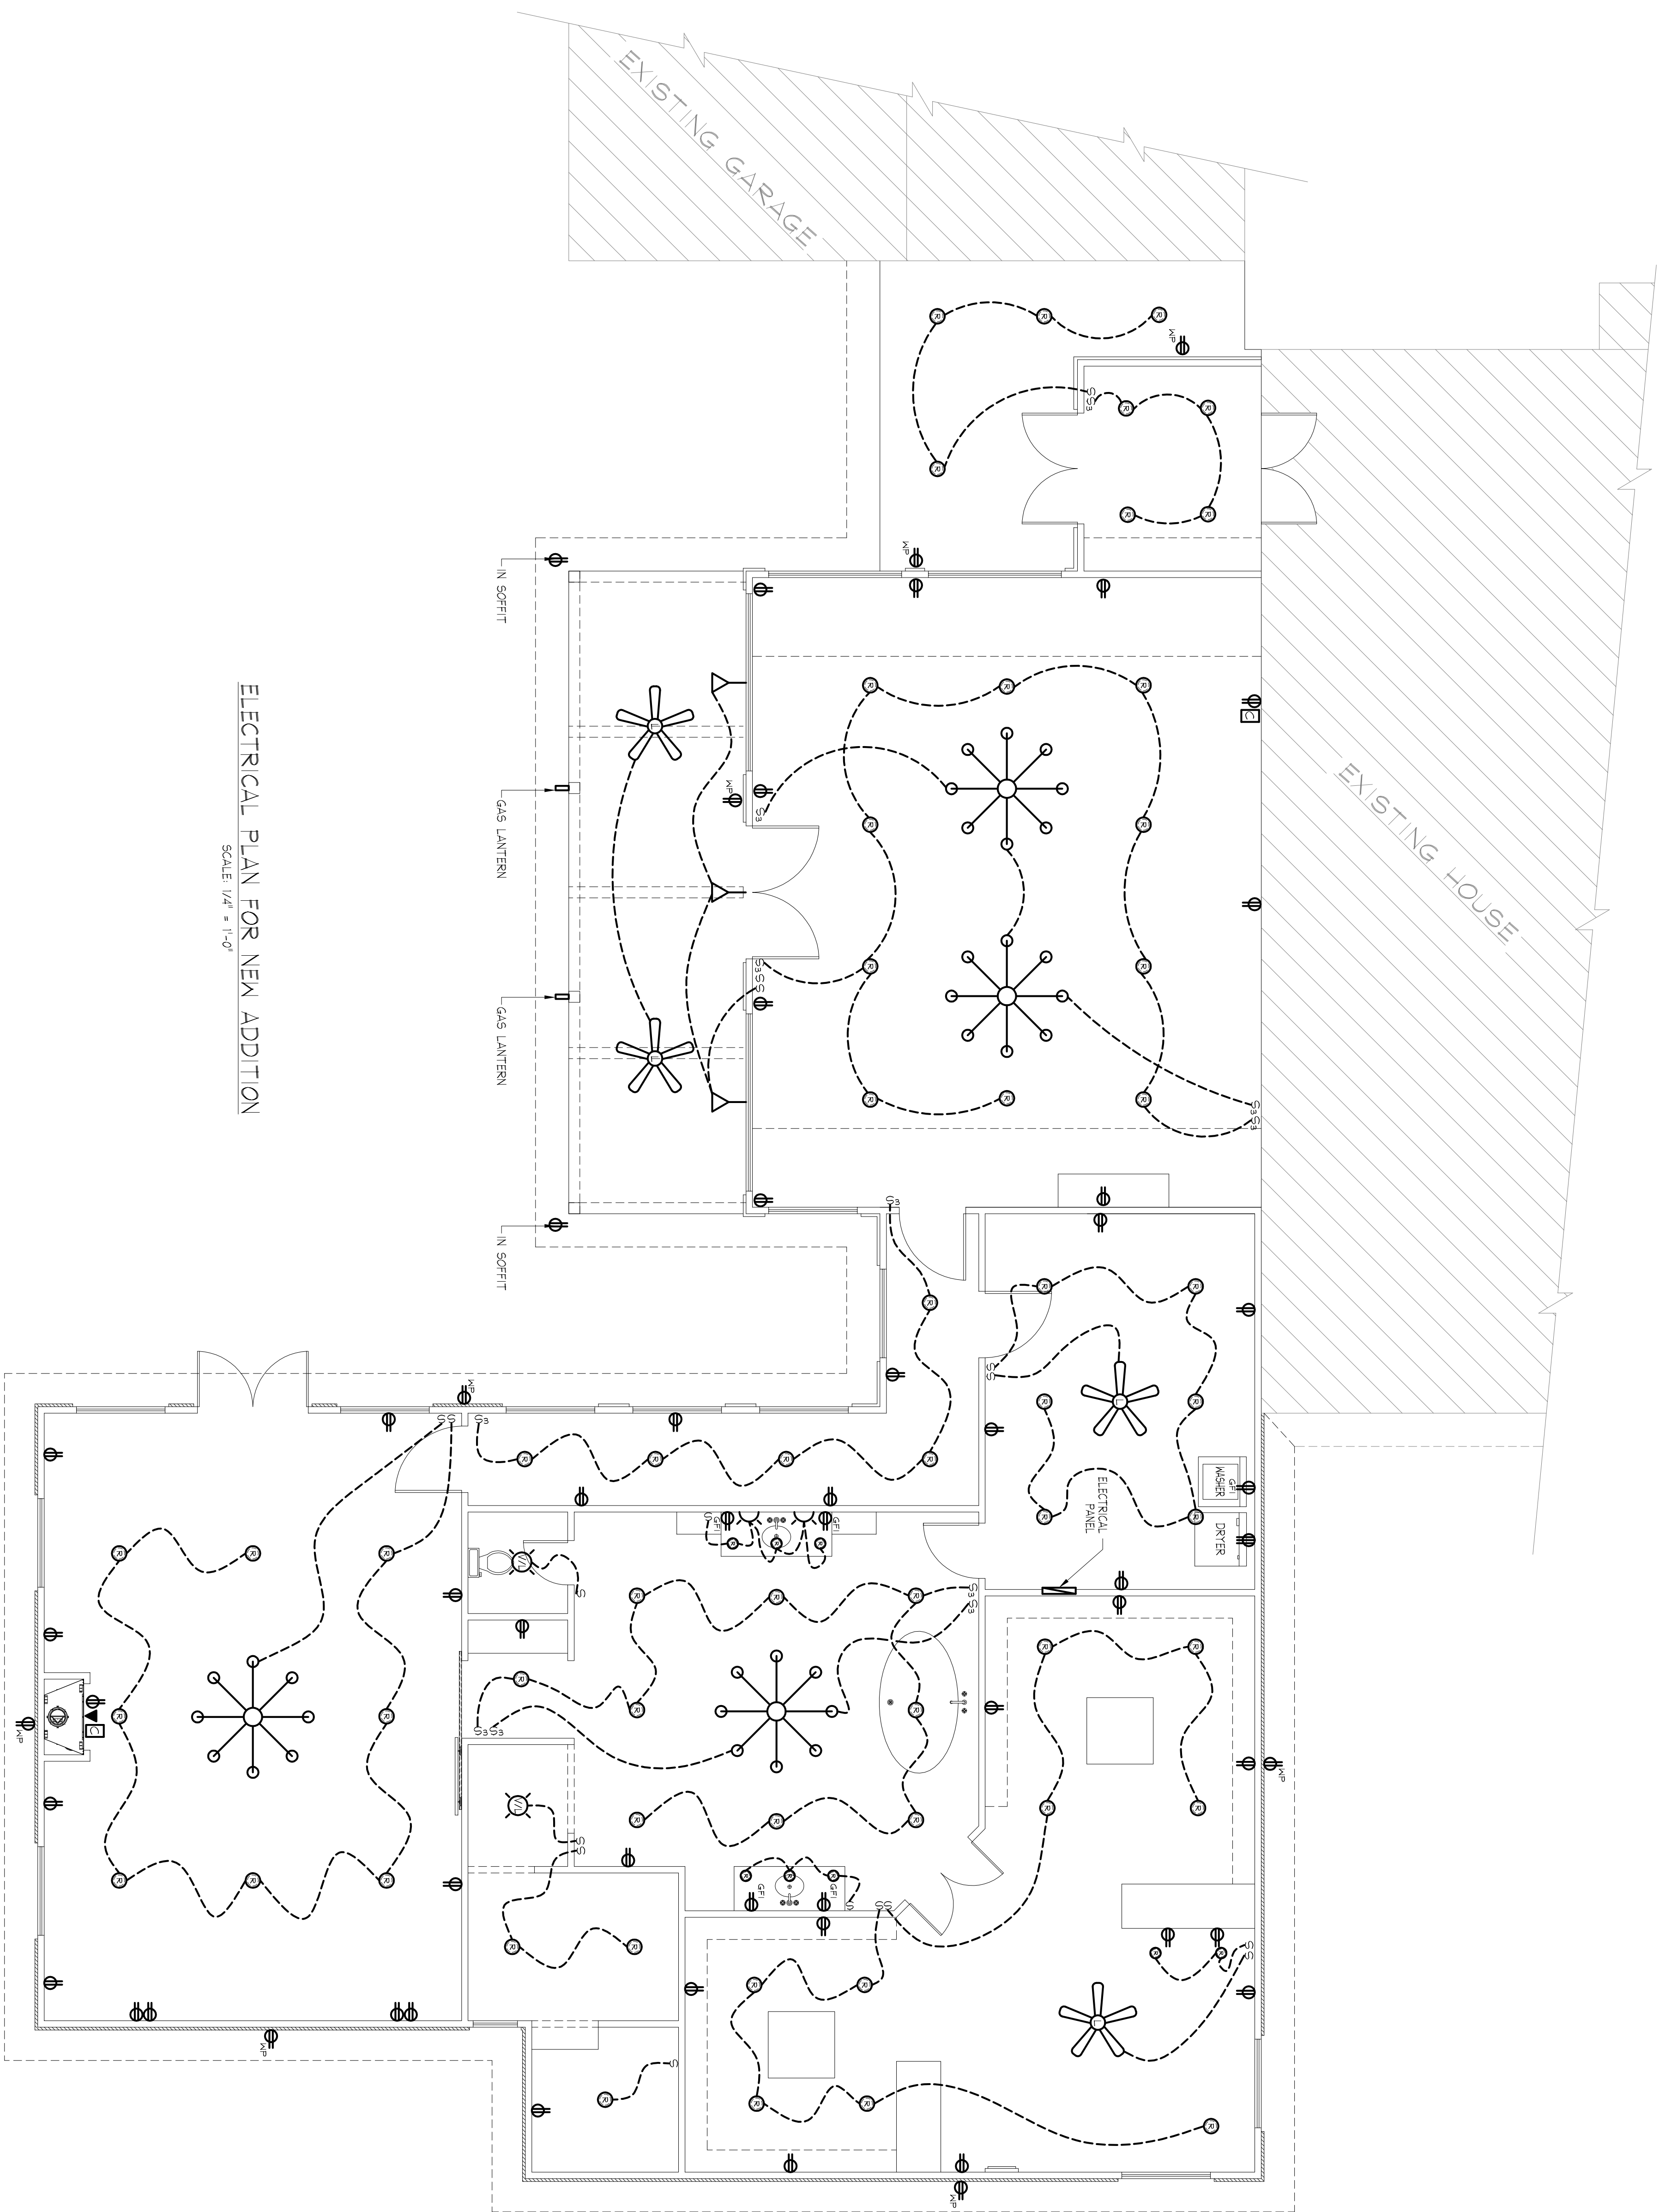

ELECTRICAL PLAN FOR NEW ADDITION
SCALE: 1/4" = 1'-0"

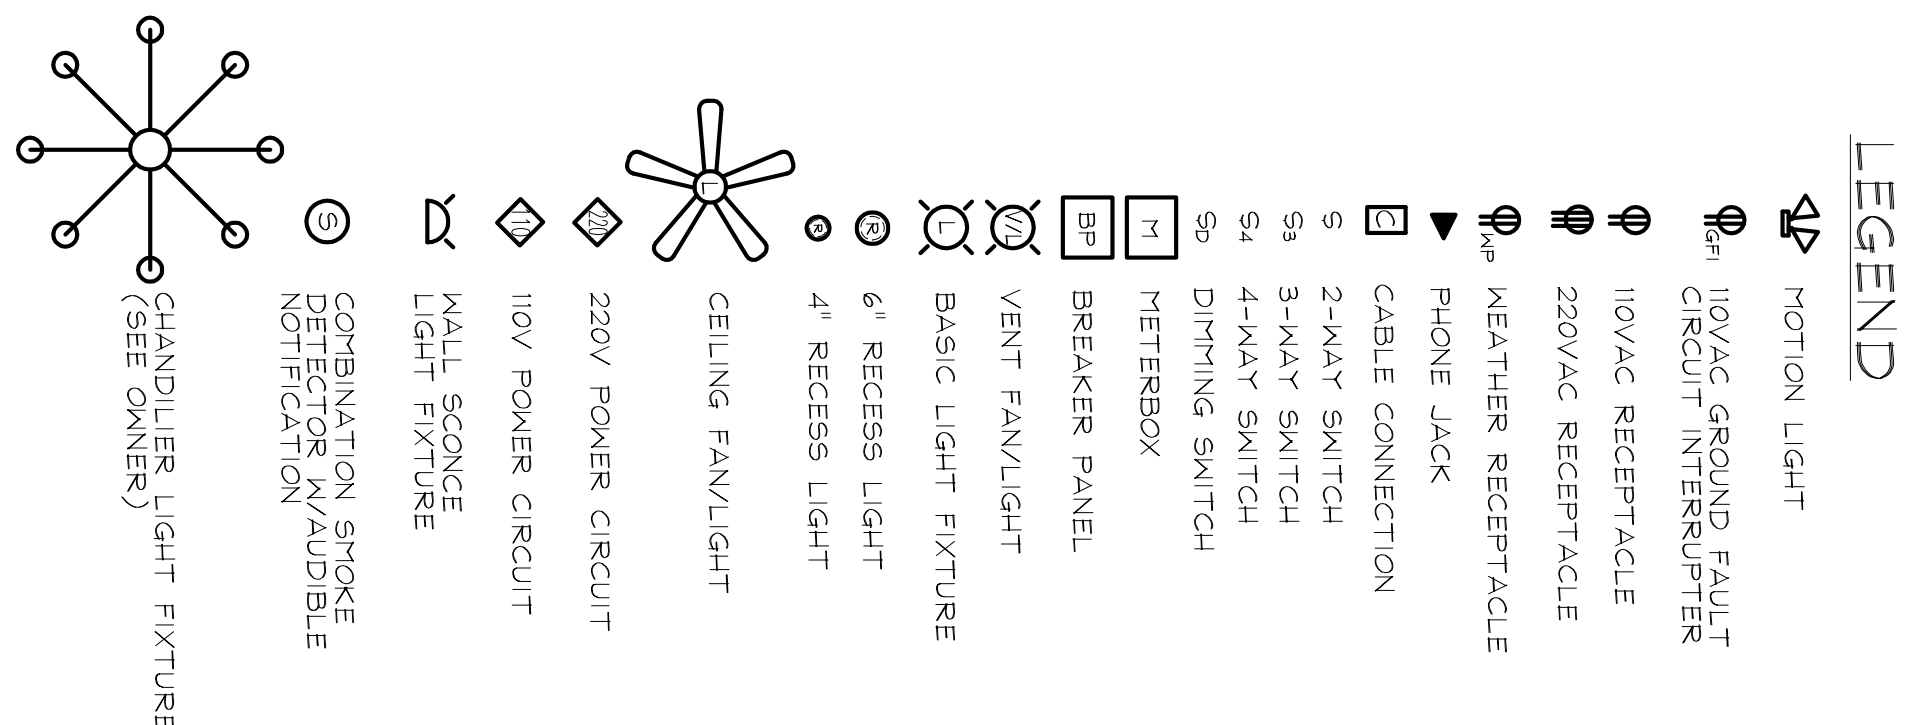

THE OWNER AND CONTRACTOR ARE REQUIRED TO REVIEW AND VERIFY THE DESIGN AND DIMENSIONS, REFLECTED ON THE PLANS AND/OR DOCUMENTS, BEFORE PURCHASING MATERIALS OR COMMENCEMENT OF CONSTRUCTION.

I HEREBY DO NOT WARRANT THESE PLANS AND/OR DOCUMENTS FOR ENGINEERING OR ARCHITECTURAL PURPOSES. ANY USE THEREOF IS STRICTLY PROHIBITED. RESPONSIBILITY OF THOSE PURPOSES IS ASSUMED BY THE OWNER AND/OR CONTRACTOR OF THE FACILITY.

THE DRAWING AND DIMENSIONS SHOWN HEREON ARE FOR VISUAL PURPOSES ONLY AND MAY NOT BE TO ANY SCALE.

SIGNATURE/DATE: _____

"ELECTRICAL PLAN"
THANK YOU FOR YOUR BUSINESS
MAY GOD BLESS YOU
"HIS REST MATTHEW 11:28-30"

DRAWN BY:	DATE DRAWN: 05/2015
APPROVED BY:	DATE APPROVED:
	JOB#: 0
LAKE CHARLES, LOUISIANA	

SHEET
E.1