

LITTIN, LITTLE & ASSOCIATES

ARCHITECTURE & INTERIOR DESIGN

The Little Design Company Ltd - PO Box 104 009, Auckland 1230
295 Lincoln Road, Waitakere City, Auckland, New Zealand
Phone: 09-836-6744 Fax: 09-836-6755 Mobile: 0274-144-657
Email - rexlittledesign@gmail.com

CONTENTS

Architectural Drawings

Sheet 1.	Site Plan
2.	Elevations
3.	Ground Floor Sketch
4.	Basement Floor Sketch
5.	Ground Floor Plan
6.	Basement Floor Plan
7.	Foundation Plan
8.	Ground Floor Framing Plan
9.	Lower Roof Framing
10.	Upper Roof Framing
11.	Roof Plan
12.	Sections
13.	Details
14.	Details
15.	Pergola Details
16.	Joinery Elevation
17.	Joinery Elevation
18.	Joinery Elevation
19.	Joinery Details
20.	Basement Joinery Details
21.	Cladding Details
22.	Staircase Details
23.	Drainage Plan
24.	Basement Electrical Plan
25.	Ground Floor Electrical Plan
26.	Kitchen & Bath Room Details
27.	Extra Details

Engineering Drawings

Sheet S01	Construction Notes
S02	Construction Details
S1	Details
S2	Details
S3	Details

PROPOSED NEW RESIDENCE FOR MR & MRS M GOLDSMITH AT 193 CULLEN ROAD WAIPU

NOTES:

1. All work is to comply with NZS 3604, The N.Z. Building Code, regulations and associated documents.
2. Contractor to check all dimensions, heights, structure set outs, drains and levels prior to start on site, before and during construction.
3. All materials specified or selected to be fixed in strict accordance with manufacturers specifications warranties and BRANZ appraisals and by licensed applicators.
4. All work to be carried out to best trade practice.

© COPYRIGHT of The Little Design Company Ltd
AMENDMENTS:





LITTIN, LITTLE & ASSOCIATES
ARCHITECTURE & INTERIOR DESIGN

The Little Design Company Ltd
PO Box 104 009, Auckland 1230
295 Lincoln Road, Waitakere City, Auckland
P: 09-836-6744, F: 09-836-6755, M: 0274-144-657
Email: rex@littledesign.co.nz

PROJECT:
**PROPOSED
NEW RESIDENCE
FOR
MR & MRS M GOLDSMITH
AT
193 CULLEN RD
WAIPU**

DRAWING TITLE:
ELEVATIONS

DATE: NOVEMBER 2014
SCALES: 1:100 A1 1:200 A3
JOB NO.: 119
DRAWING NO. OF

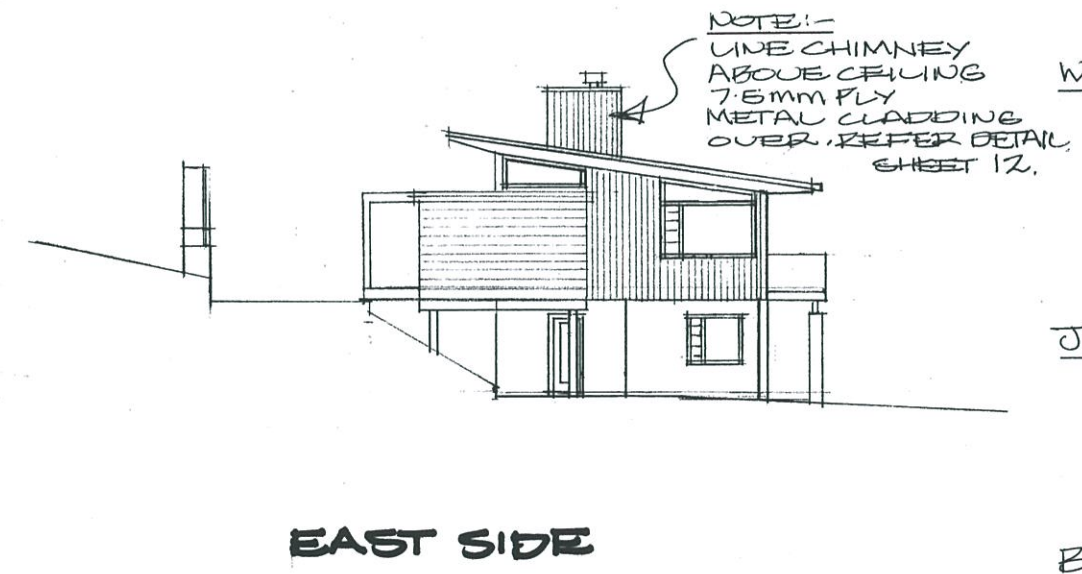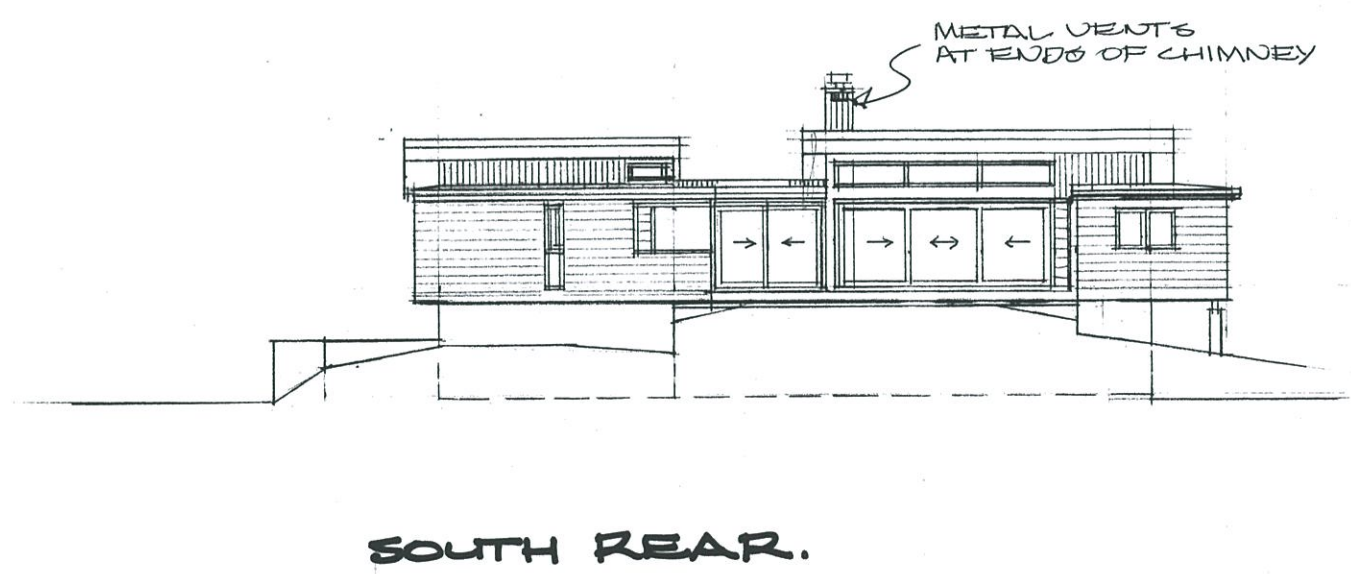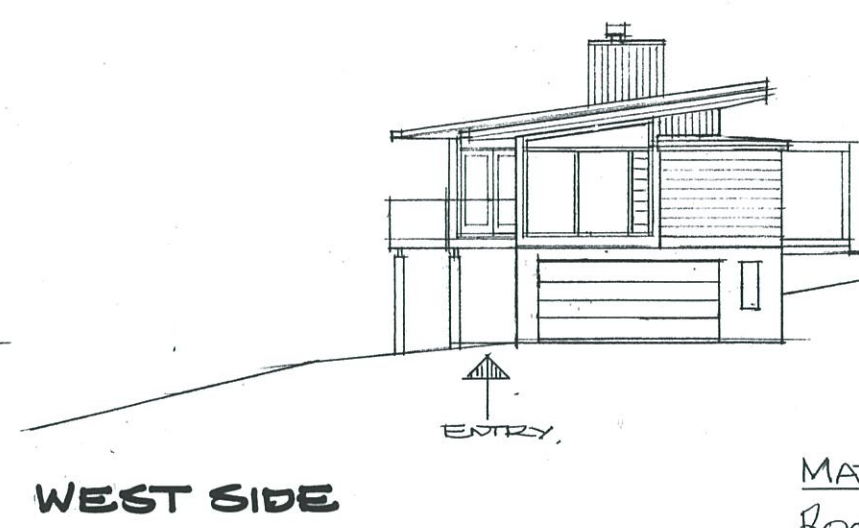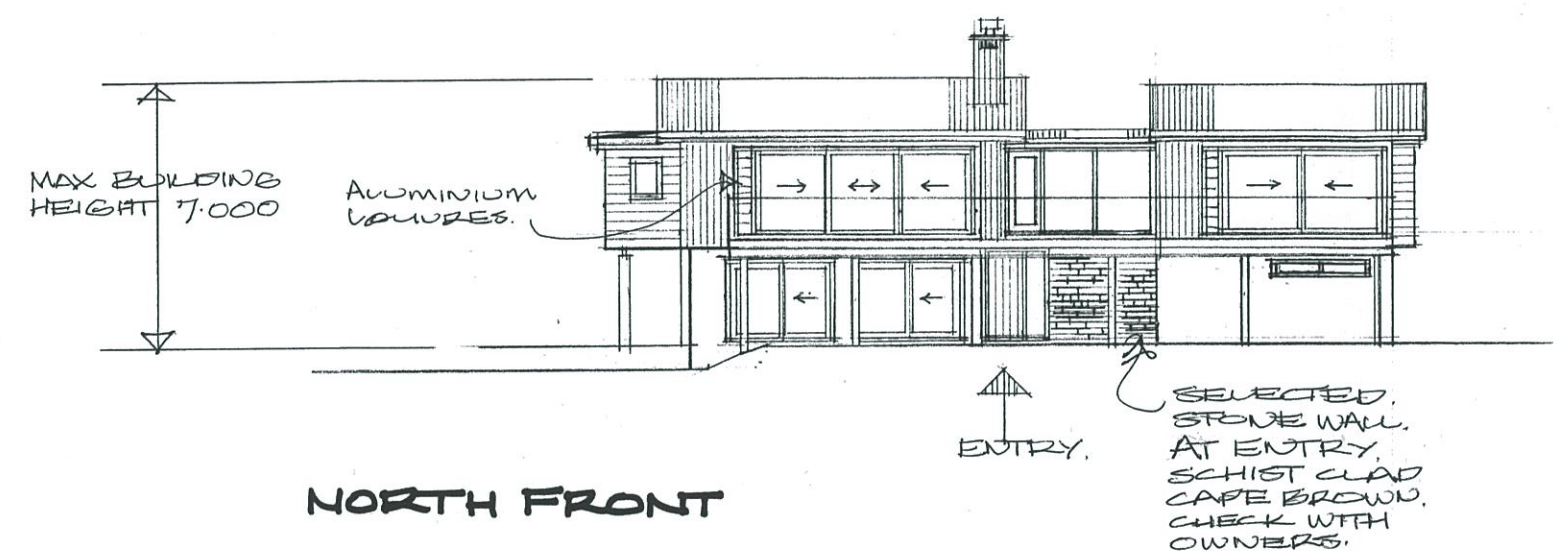

MATERIALS.

ROOF:- DIAMOND STYLELINE ZINCALUME LEFT NATURAL OR. COLOURSTEEL MAX COLOUR SMOKEY.


WALLS:- DIAMOND RIB 20 COLOUR STEEL MAX COLOUR. LIGHTITE OR BLACK & CEDAR 200x20 RUSTICATED W/BROS. STAIN DARK BROWN

JOINERY: ALUMINIUM. ALUTHERM OR NULOOK ARCHITECTURAL SERIES. ANOTECH MID BRONZE OR SATIN BLACK.

BASE:- PLASTERED PAINT RESENE CONCRETE.

SPROUTING DIAMOND 175. & D.P.'s COLOUR SMOKEY, OR STAINLESS STEEL.

ELEVATIONS	1:100 A1.
	1:200 A3.

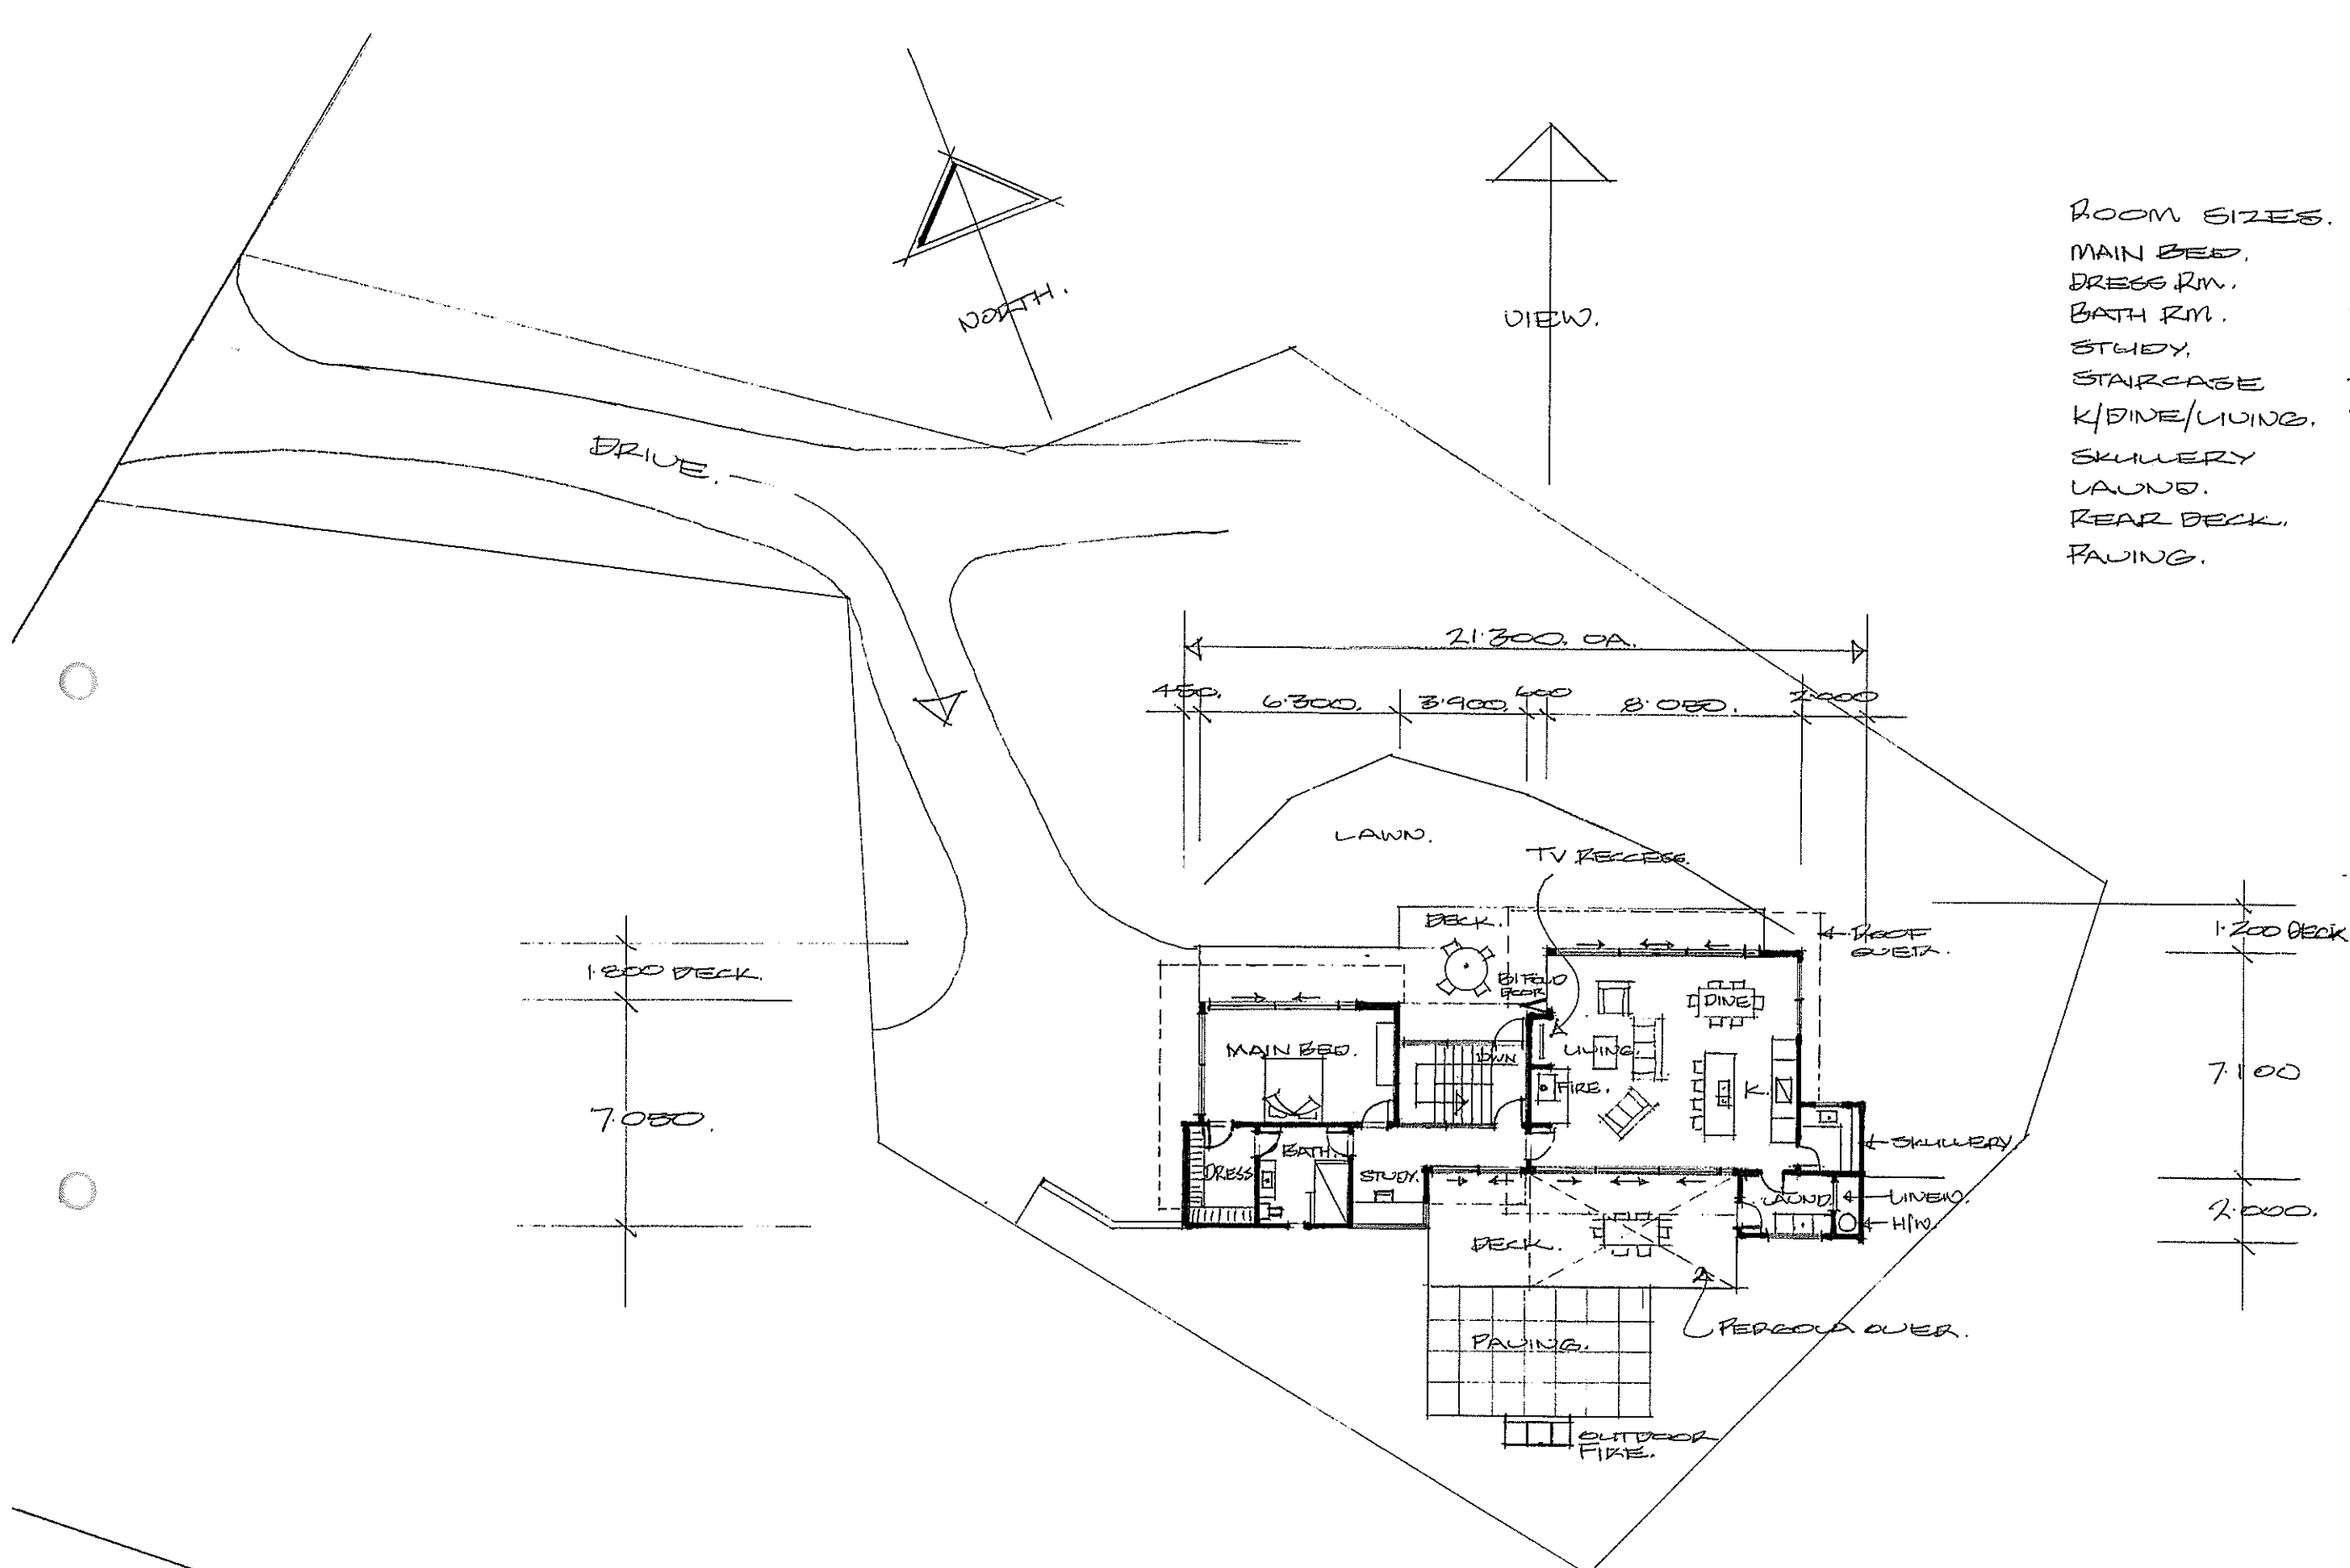

ROOM SIZES.	
MAIN BED.	6.0 x 3.6.
DRESS RM.	2.1 x 3.0
BATH RM.	2.8 x 3.0
STUDY.	2.7 x 2.0 + PASSAGE
STAIRCASE	2.4 x 4.0.
K/DINE/LIVING.	7.8 x 6.7
SKULLERY	1.9 x 2.0
LAUND.	2.8 x 1.9 + LINEN
REAR DECK.	9.6 x 3.6.
PAVING.	7.0 x 4.0

- NOTES:**
1. All work is to comply with NZS 3604, The N.Z. Building Code, regulations and associated documents.
 2. Contractor to check all dimensions, heights, structure set outs, drains and levels prior to site on site, before and during construction.
 3. All materials specified or selected to be fixed in strict accordance with manufacturers specifications warranties and BRANZ appraise and by licensed applicators.
 4. All work to be carried out to best trade practice

© COPYRIGHT of The Little Design Company Ltd
AMENDMENTS:

LITTIN, LITTLE & ASSOCIATE
ARCHITECTURE & INTERIOR DESIGN

The Little Design Company Ltd
PO Box 104 009, Auckland 1230
205 Lincoln Road, Waiakare City, Auckland
P: 09-836-6744, F: 09-836-6755, M: 0274-144-857
Email: real.littledesign@gmail.com

PROJECT:

**PROPOSED
NEW RESIDENCE
FOR
MR & MRS M GOLDSMITH
AT
193 CULLEN RD
WAIPU**

DRAWING TITLE:

**GROUND FLOOR
SKETCH**


DATE: NOVEMBER 2014

SCALES: 1:100A1 1:200A3

JOB NO.: 119

DRAWING NO. OF

GROUND FLOOR PLAN	1:100A1
REFER SHEET. 5.	1:200A3.

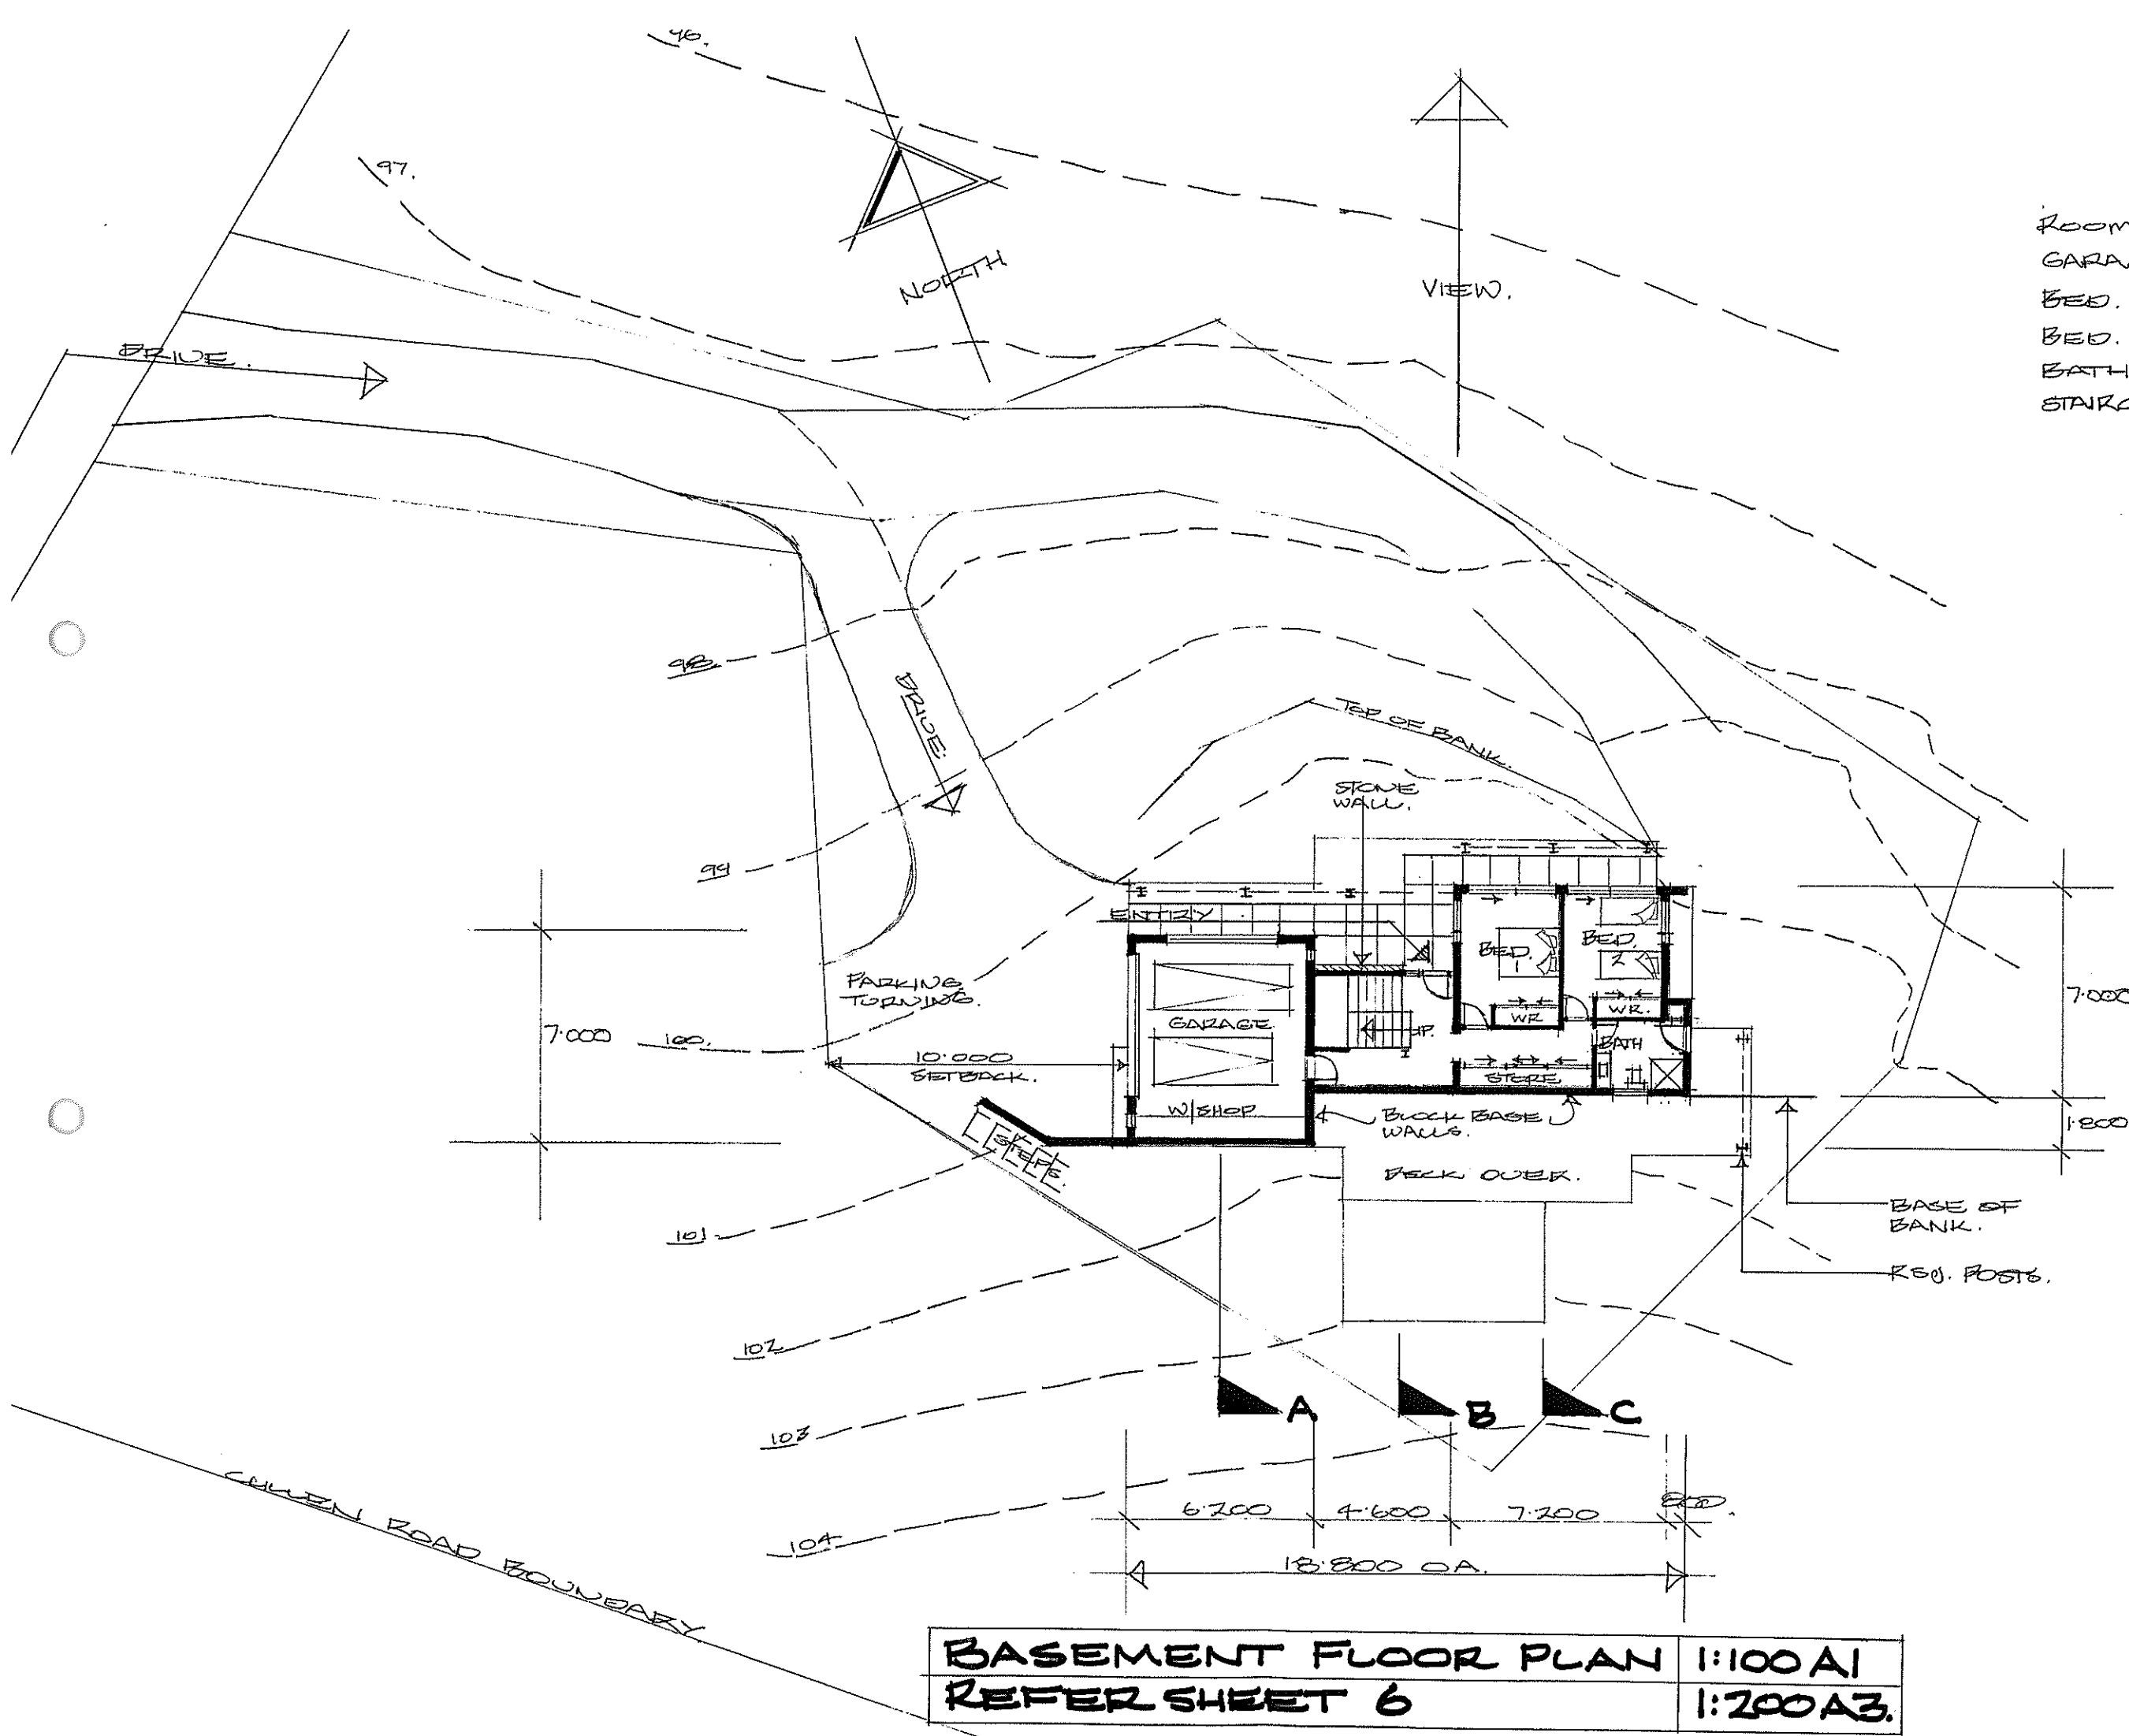

ROOM SIZES.
 GARAGE W/SHOP. 5.8 x 6.6.
 BED. 1. 3.3 x 3.8 + W.
 BED. 2. 3.3 x 3.4 + W.
 BATH. 2.2 x 2.2.
 STAIRCASE/FOYER. 4.6 x 3.6.

- NOTES:
1. All work is to comply with NZS 3604, The N.Z. Building Code, regulations and associated documents.
 2. Contractor to check all dimensions, heights, structure set outs, drains and levels prior to sit on site, before and during construction.
 3. All materials specified or selected to be fixed in strict accordance with manufacturers specifications warranties and BRANZ appraisal and by licensed applicators.
 4. All work to be carried out to best trade practice.

© COPYRIGHT of The Little Design Company L
 AMENDMENTS:

LITTIN, LITTLE & ASSOCIATE
 ARCHITECTURE & INTERIOR DESIGN

The Little Design Company Ltd
 PO Box 104 009, Auckland 1230
 295 Lincoln Road, Waitakere City, Auckland
 P: 09-836-6744, F: 09-836-6755, M: 0274-144-657
 Email: roz@littledesign.co.nz

PROJECT:

**PROPOSED
 NEW RESIDENCE
 FOR
 MR & MRS M GOLDSMITH
 AT
 193 CULLEN RD
 WAIPU**

DRAWING TITLE:

**BASEMENT FLOOR
 SKETCH.**

DATE: NOVEMBER 2014


SCALE: 1:100 A1 1:200 A3

JOB NO. 119


DRAWING NO. OF

BASEMENT FLOOR PLAN	1:100 A1
REFER SHEET 6	1:200 A3.

4

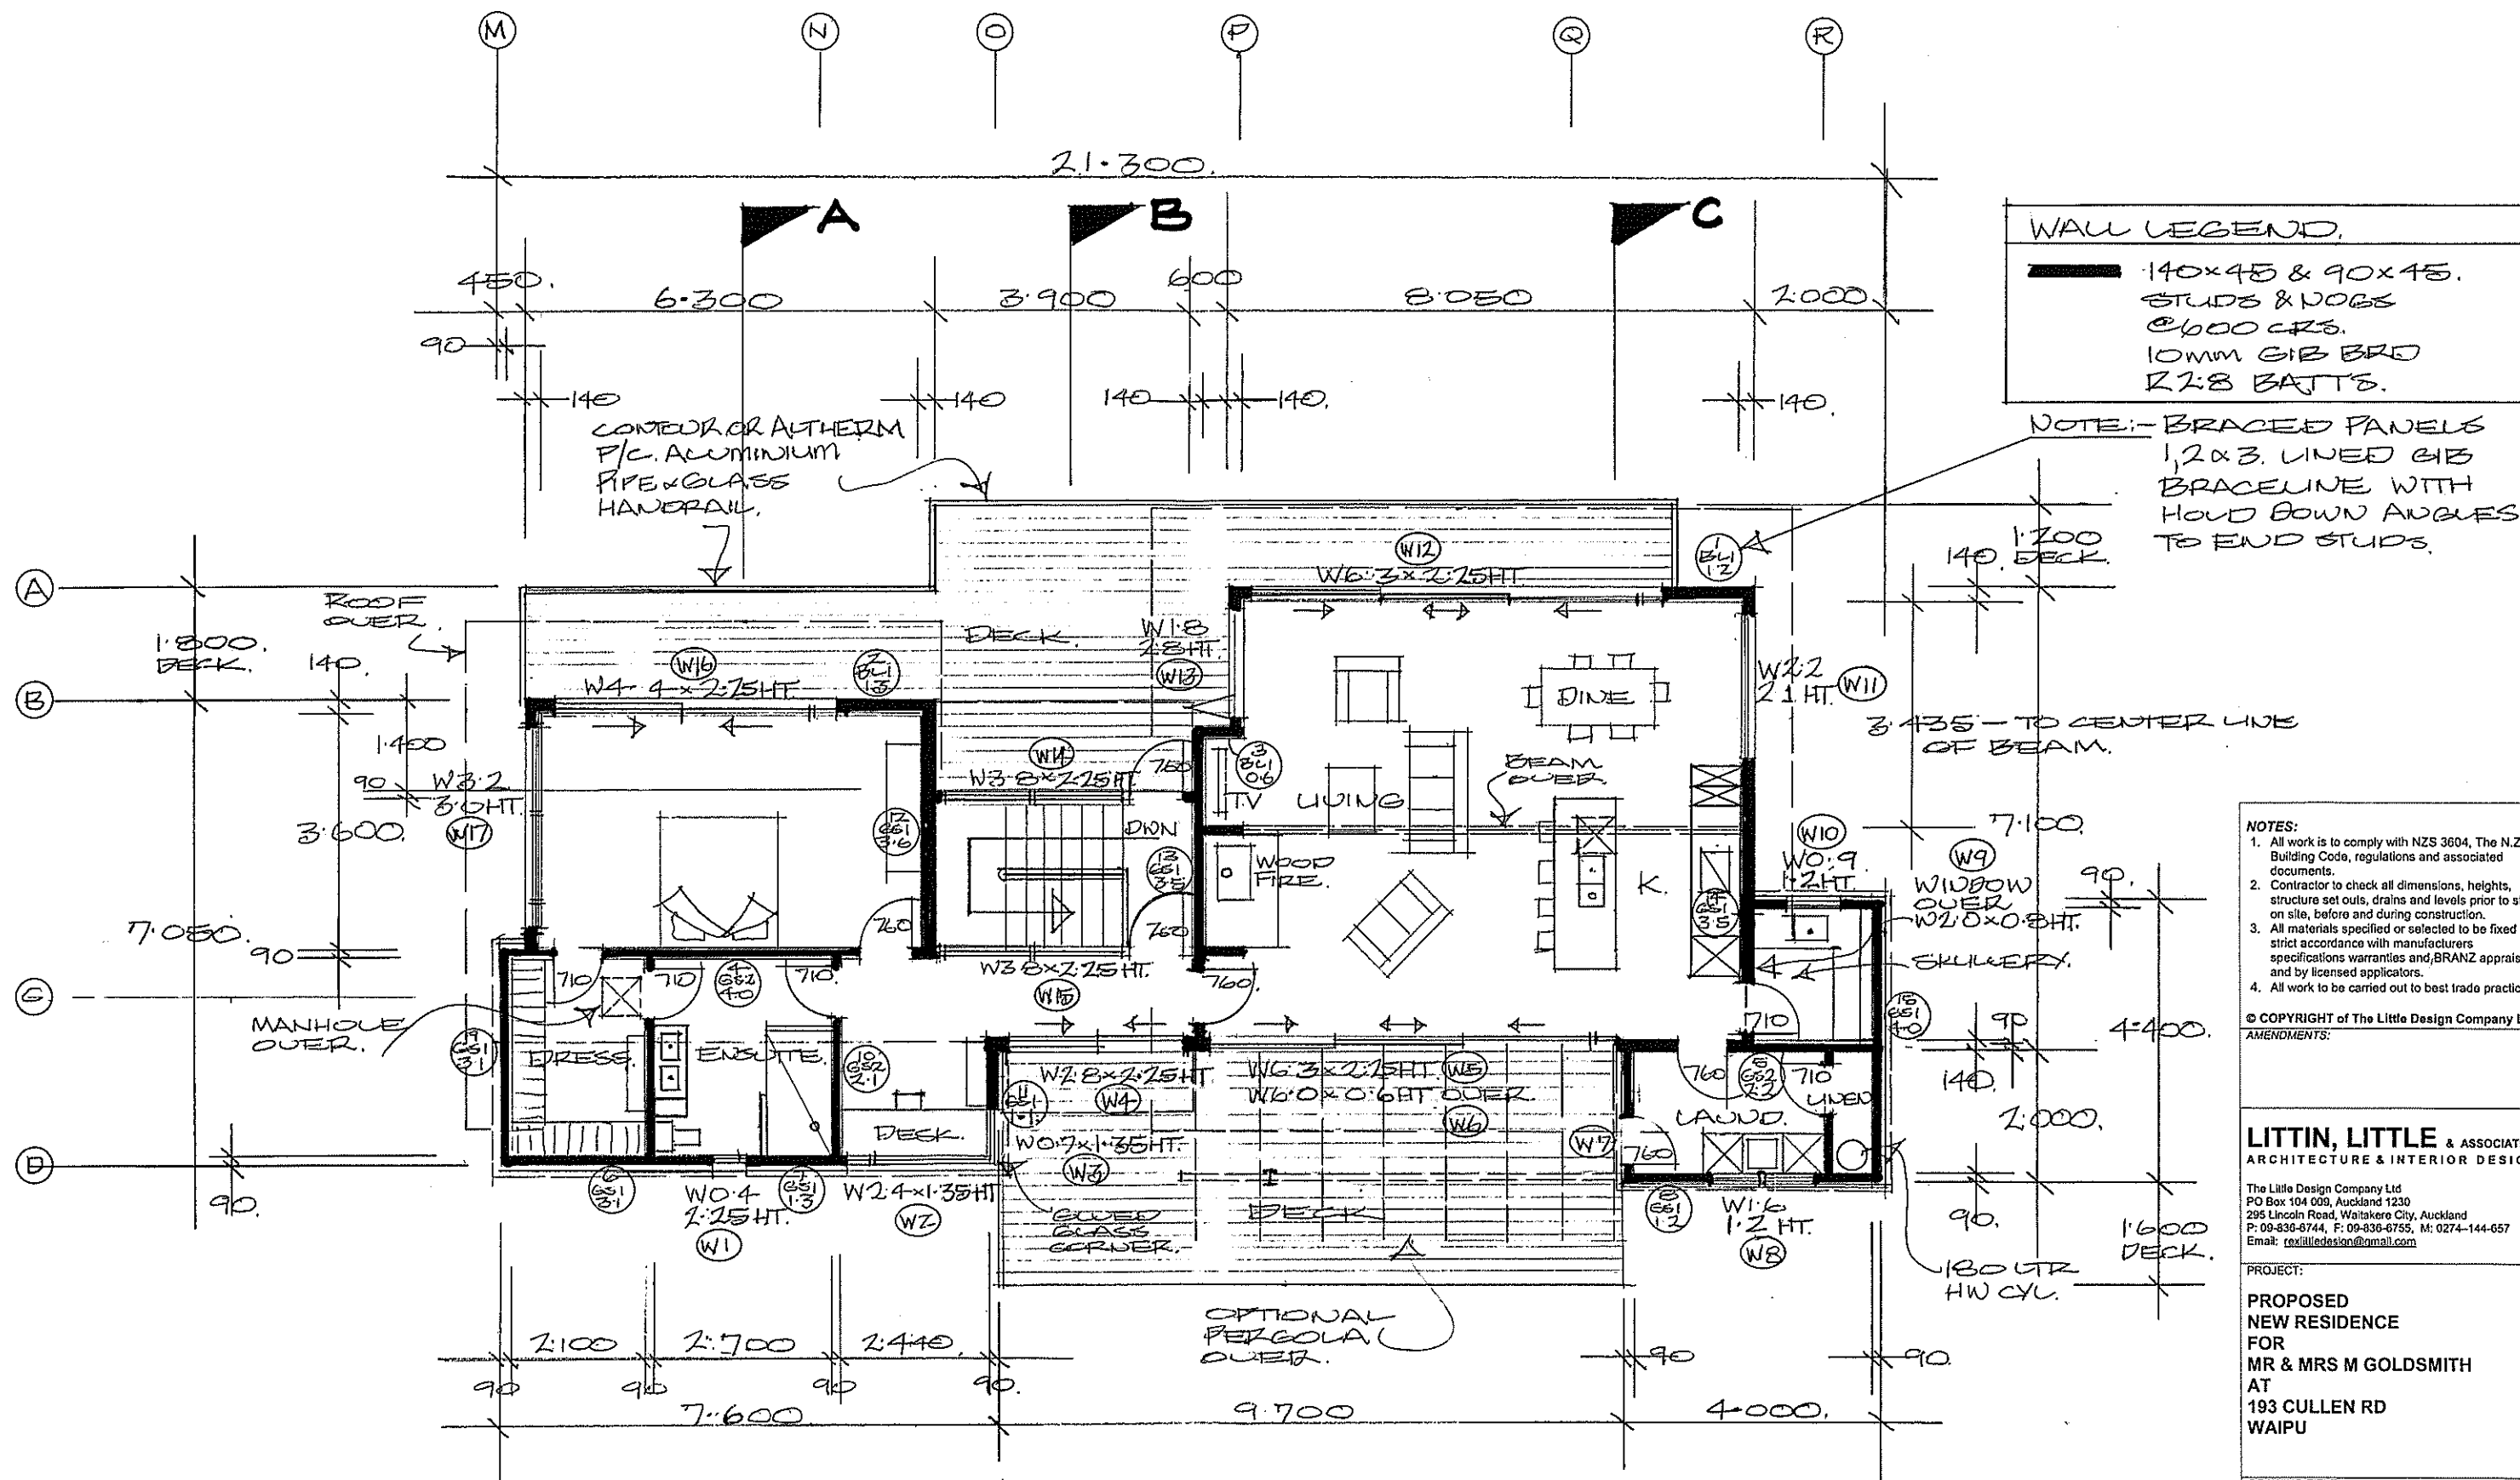

INTERIOR DOORS
AW 1980 HEIGHT WIDTHS
AS SHOWN ON PLANS.
100 GROOVED PLY FACES.
DOOR HANDLES.
SCHLAGE ACCENT. SERIES
SATIN NICKLE
MOUNT. "UPSIDE/DOWN"

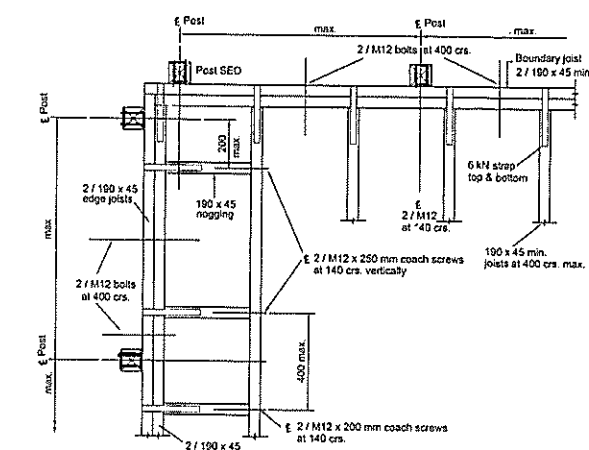

SECTION VIEW AT NOGGING



- © COPYRIGHT of The Little Design Company Ltd
AMENDMENTS:

The Little Design Company Ltd
PO Box 104 009, Auckland 1230
295 Lincoln Road, Waitakere City, Auckland
P: 09-836-6744, F: 09-836-6755, M: 0274-144-657
Email: roxitlitedesign@gmail.com

DRAWING TITLE:

GROUND FLOOR
FRAMING PLAN.

DATE: NOVEMBER 2014
 SCALES: 1:50 A 1:100 A3
 JOB NO.: 119
 DRAWING NO. OF

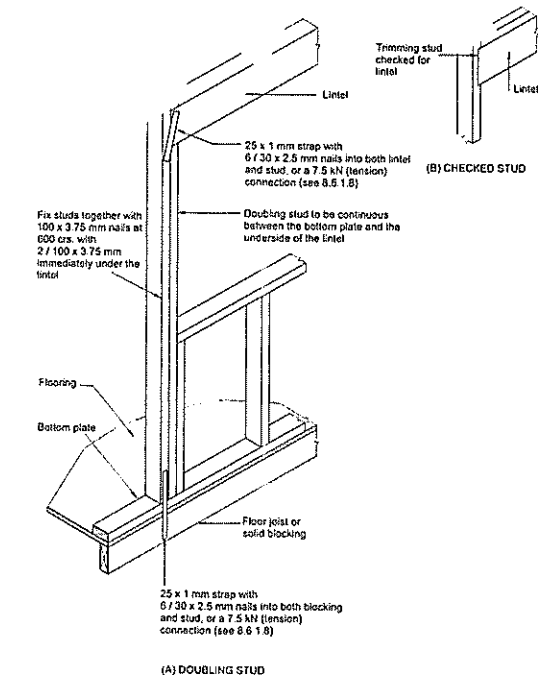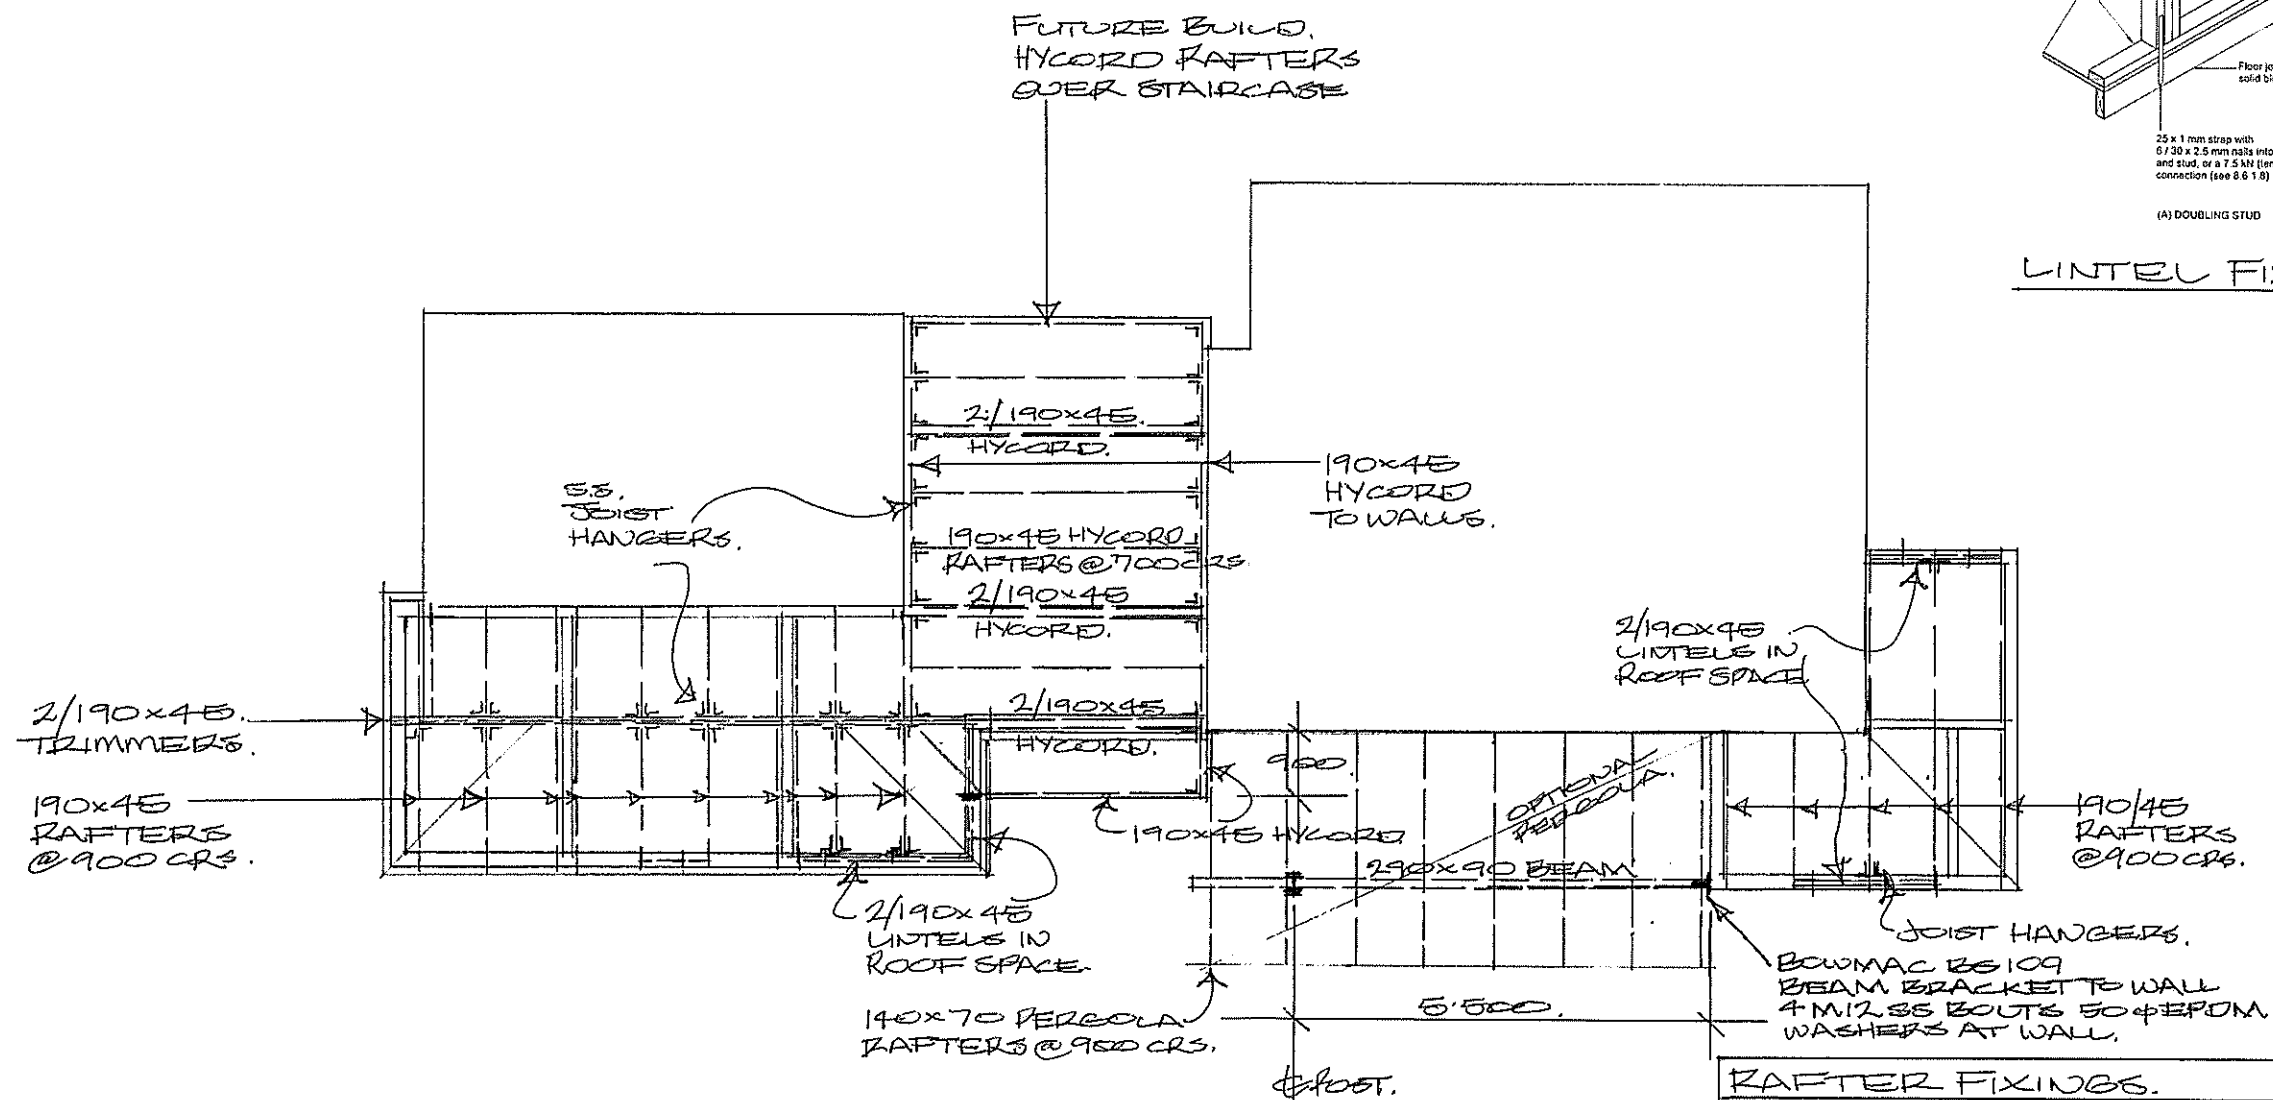

LINTEL FIXING DETAIL.

NOTES:

1. All work is to comply with NZS 3604, The N.Z. Building Code, regulations and associated documents.
2. Contractor to check all dimensions, heights, structure set outs, drains and levels prior to start on site, before and during construction.
3. All materials specified or selected to be fixed in strict accordance with manufacturers specifications warranties and BRANZ appraisals and by licensed applicators.
4. All work to be carried out to best trade practice.

© COPYRIGHT of The Little Design Company Ltd
AMENDMENTS:

LITTIN, LITTLE & ASSOCIATES ARCHITECTURE & INTERIOR DESIGN

The Little Design Company Ltd
PO Box 104 009, Auckland 1230
265 Lincoln Road, Waiakare City, Auckland
P: 09-836-6744, F: 09-836-6755, M: 0274-144-657
Email: rex@littledesign.co.nz

PROJECT:

PROPOSED
NEW RESIDENCE
FOR
MR & MRS M GOLDSMITH
AT
193 CULLEN RD
WAIPIU

DRAWING TITLE:











LOWER ROOF
FRAMING.

DATE: NOVEMBER 2014

SCALES: 1:50 A1 1:100 A3

JOB NO.: 119

DRAWING NO. OF

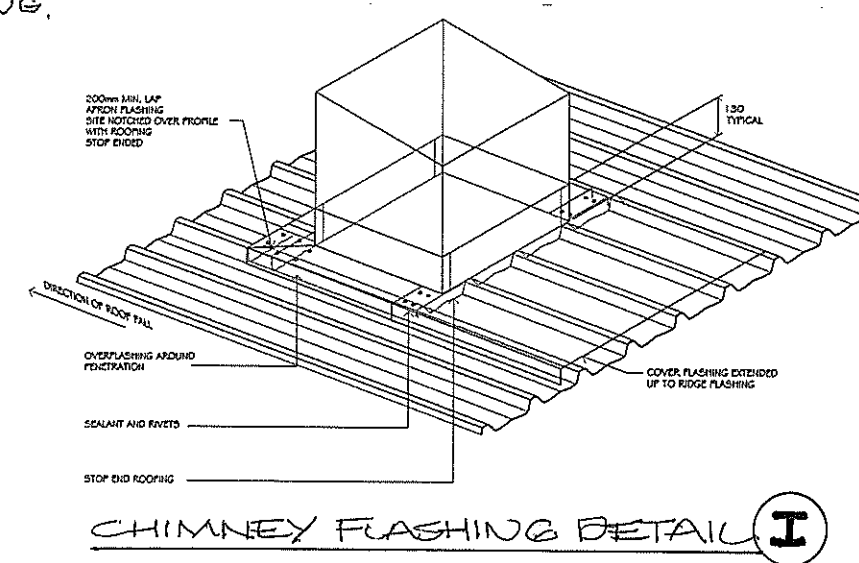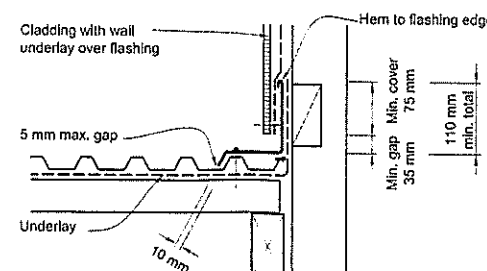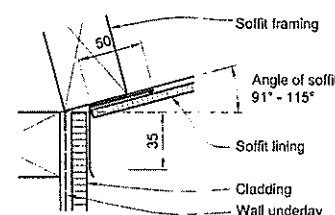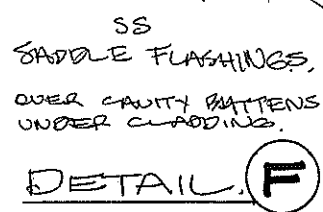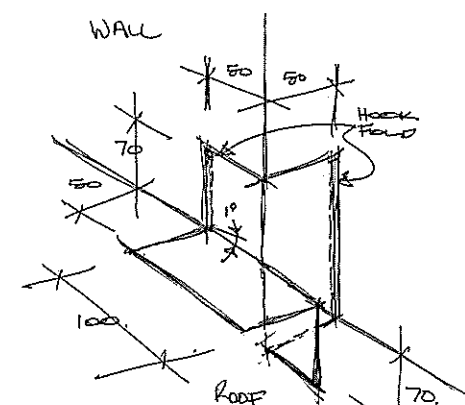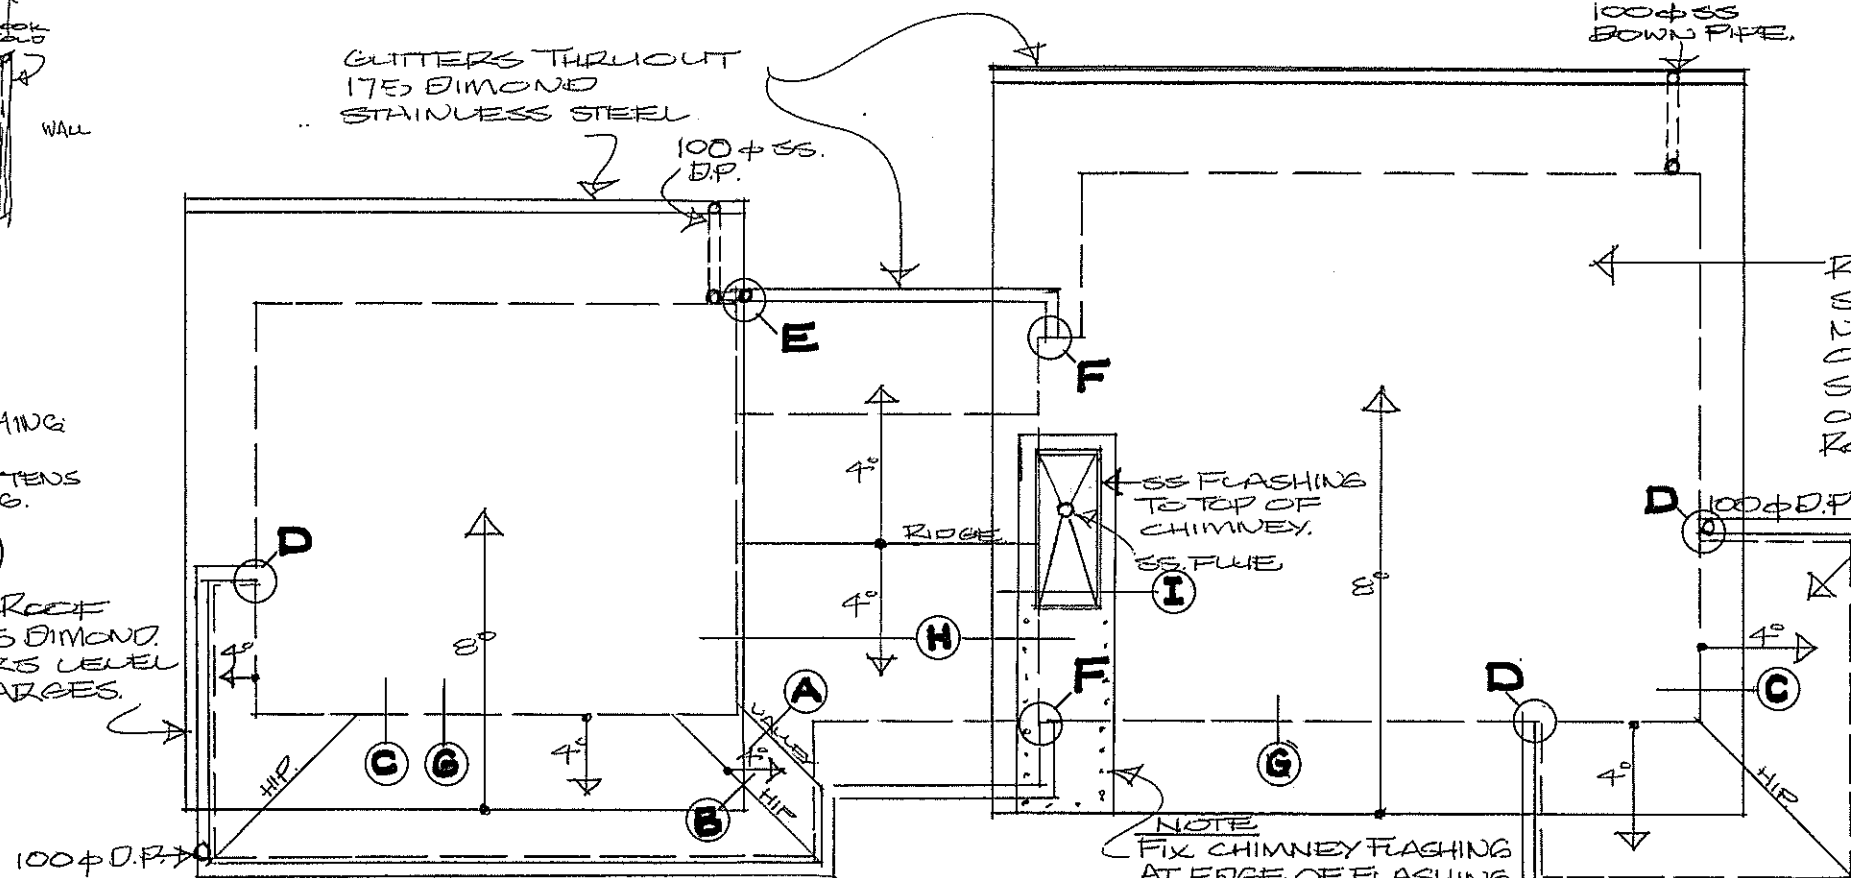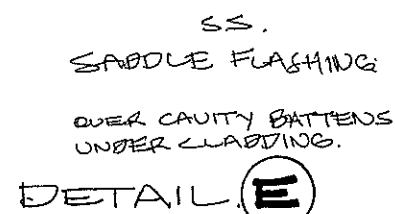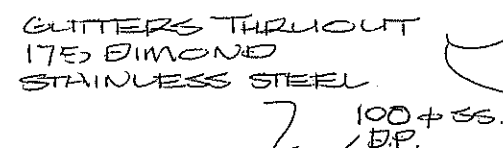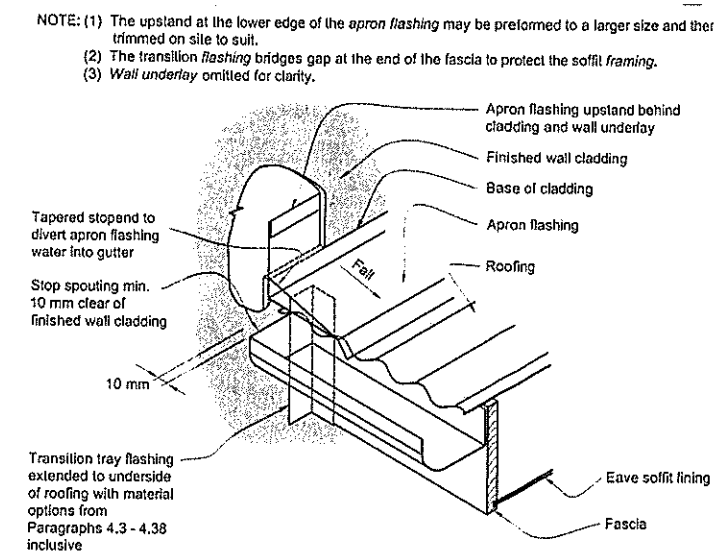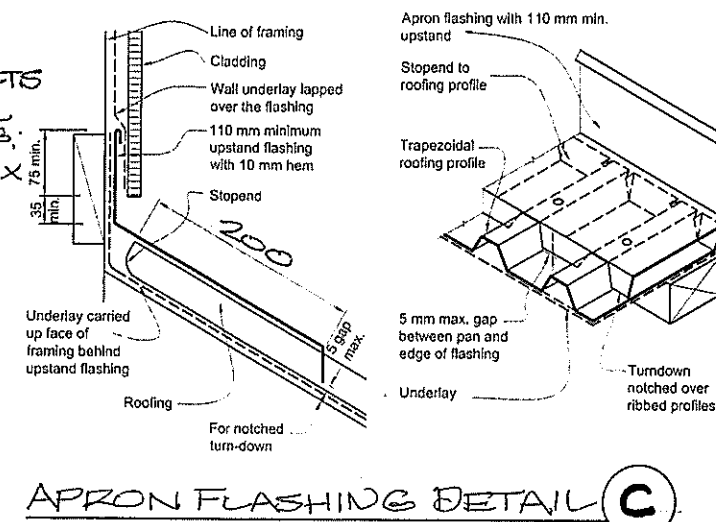

NOTE: (1) The upland at the lower edge of the *apron flashing* may be preformed to a larger size and then trimmed on site to suit.
(2) The transition *flashing* bridges gap at the end of the fascia to protect the soffit *framing*.
(3) *Wall underlay* omitted for clarity.

NOTES:

1. All work is to comply with NZS 3604, The N.Z. Building Code, regulations and associated documents.
2. Contractor to check all dimensions, heights, structure set outs, drains and levels prior to site on site, before and during construction.
3. All materials specified or selected to be fixed in strict accordance with manufacturers specifications warranties and BRANZ appraisal and by licensed applicators.
4. All work to be carried out to best trade practice.

© COPYRIGHT of The Little Design Company Ltd
AMENDMENTS:

LITTIN, LITTLE & ASSOCIATES
ARCHITECTURE & INTERIOR DESIGN

The Little Design Company Ltd
PO Box 104 009, Auckland 1230
295 Lincoln Road, Waitakere City, Auckland
P: 09-836-6744, F: 09-836-8755, M: 0274-144-657
Email: texlittledesign@gmail.com

PROJECT:

PROPOSED
NEW RESIDENCE
FOR
MR & MRS M GOLDSMITH
AT
193 CULLEN RD
WAIPU

DRAWING TITLE:


ROOF PLAN & DETAILS.

DATE: NOVEMBER 2014

SCALES: 1:50A1 1:100A3.

JOB NO.:119

DRAWING NO. OF

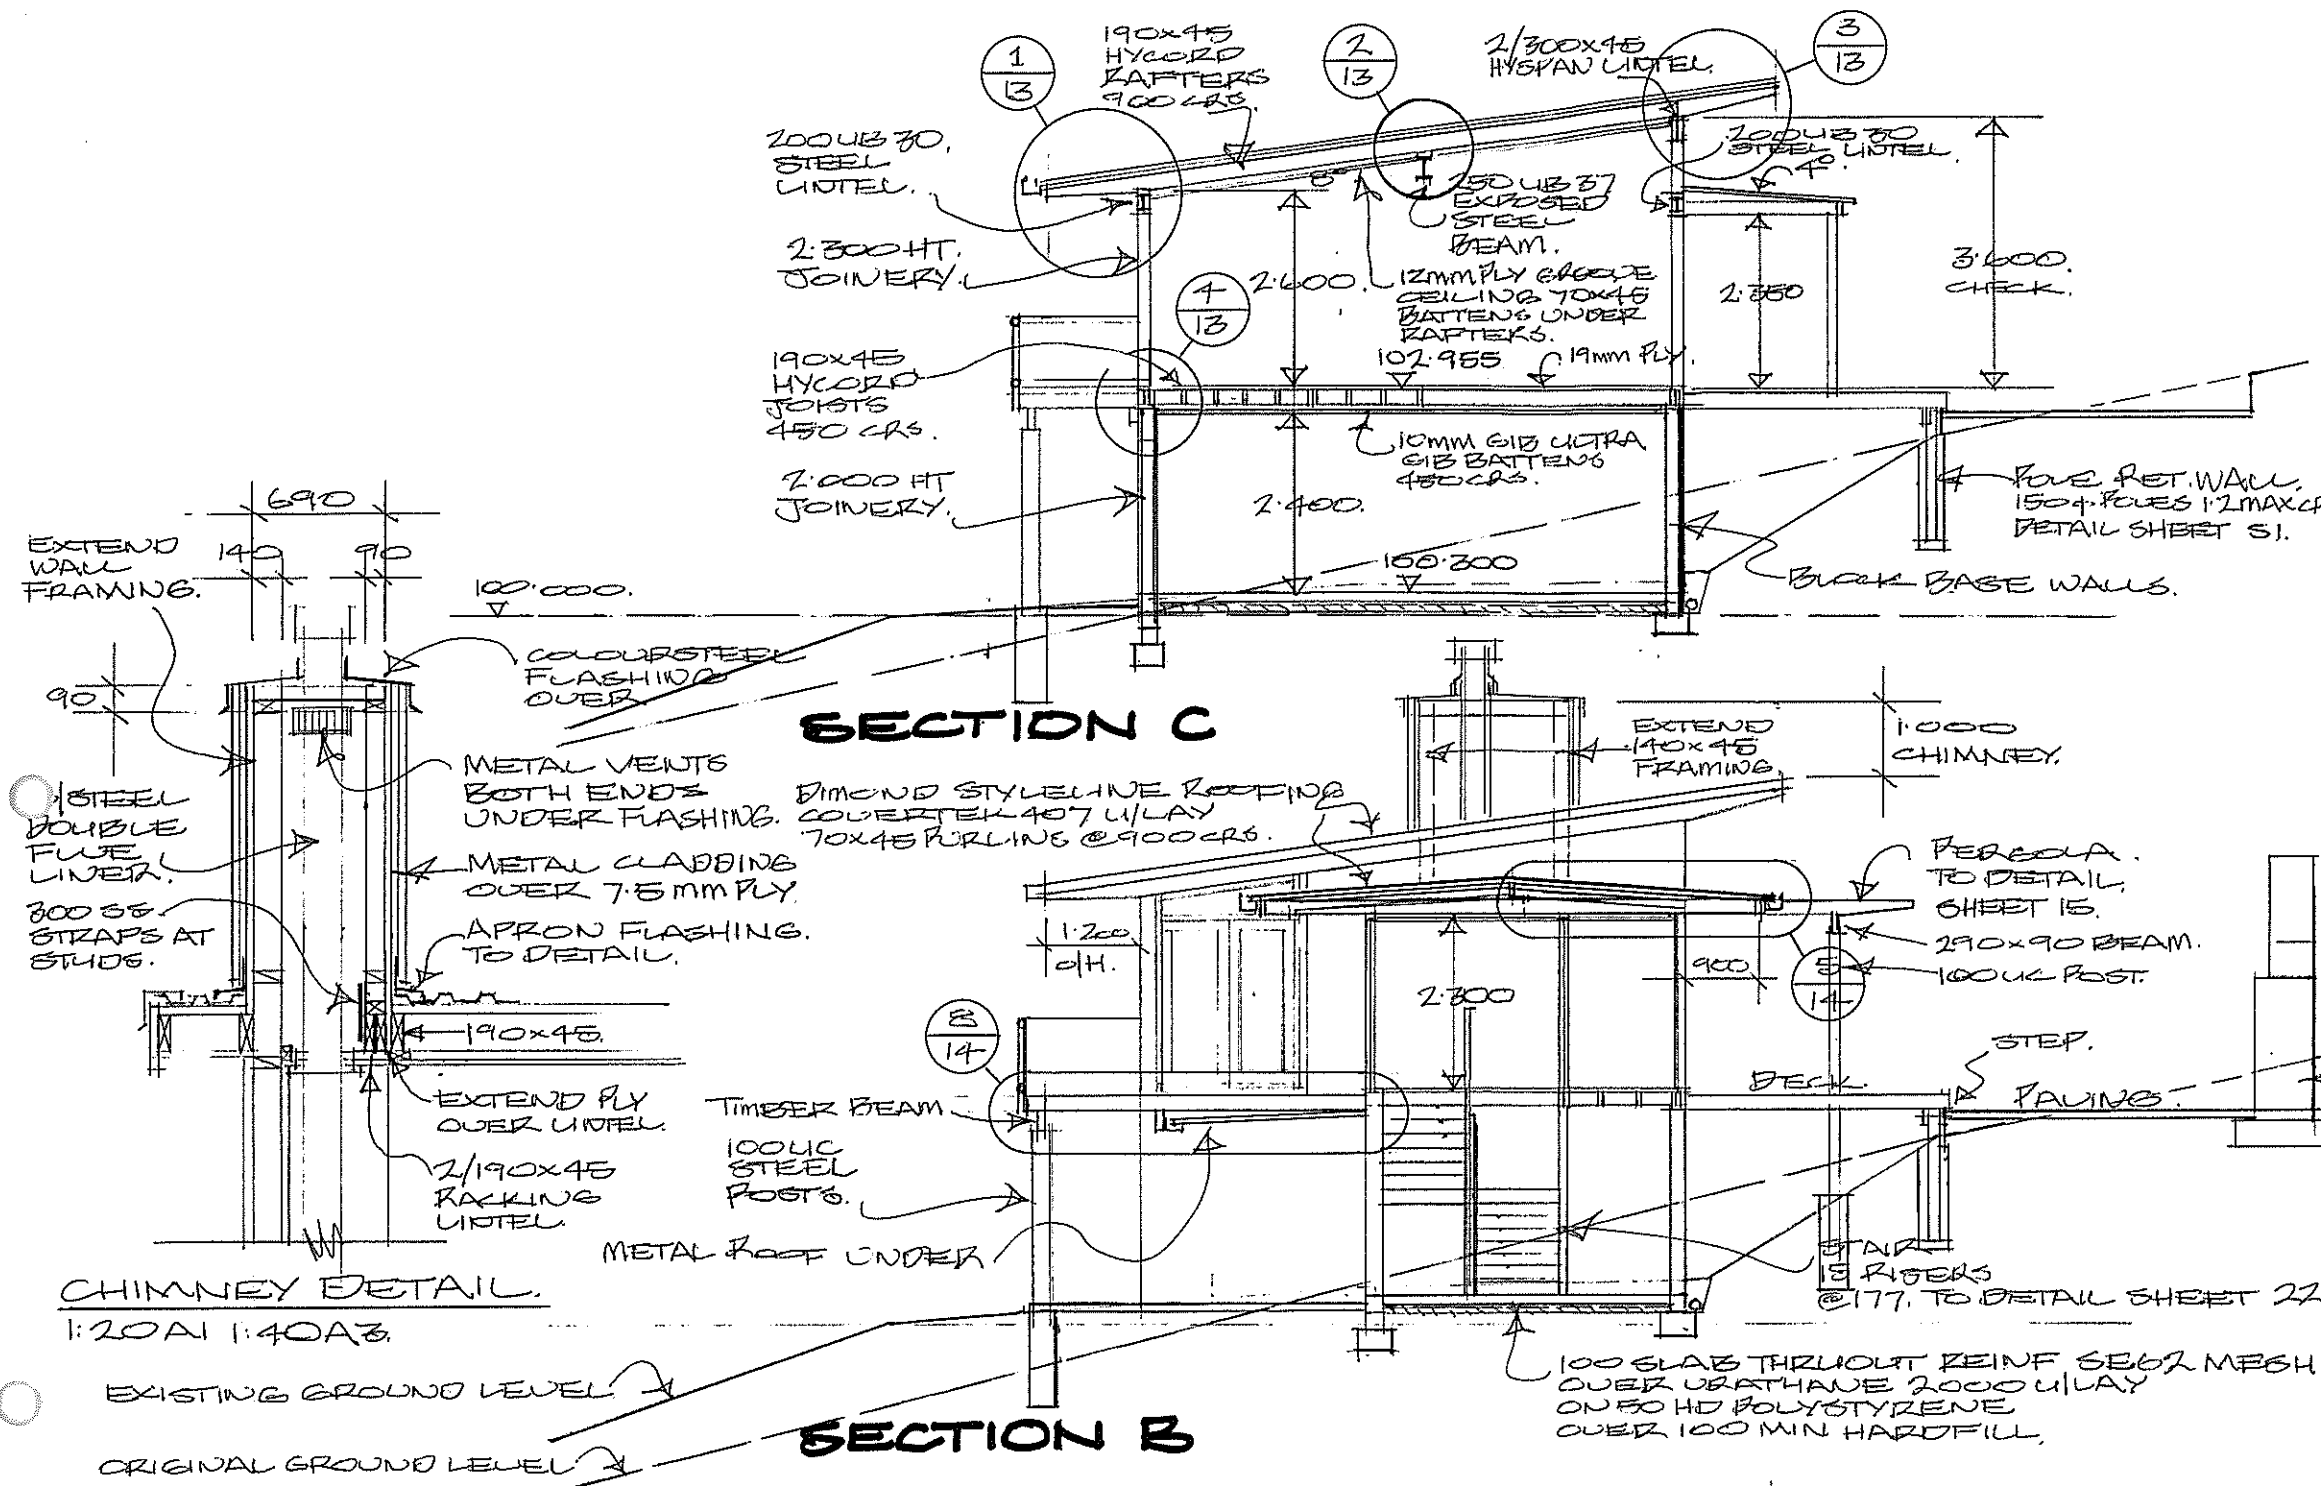

NOTES.

TIMBER TREATMENT

TIMBER IN GROUND — H5
TIMBER IN GROUND CONTACT — H4
EXTERIOR EXPOSED TIMBER — H3/2
& ROOF FRAMING — H3/2
INTERIOR ENCLOSED TIMBER — H1/2.

TIMBER STRENGTH — SGB.

FINISHING TIMBERS.

SKIRTINGS — 140x12 ALL F/JOIN
ARCHITRAVES — 65x12 RADIATA
CORNICE — 90x12 ABSOLUTLY
NO MDF.

INSULATION

CEILING — R4.0 BATTs.
TIMBER WALLS — R2.8 BATTs.
BLOCK WALLS — R2.0 FORMALINE
TIMBER FLOORS — R2.6 NOISE BATTs.
CONCRETE FLOOR 50 HD POLYSTYRENE
WALL LININGS
10MM GIB BRD & GIB BRACE LINE
10MM GIB AQUATO BATHS & LAUNE

NOTES:

- All work is to comply with NZS 3604, The N.Z. Building Code, regulations and associated documents.
- Contractor to check all dimensions, heights, structure set outs, drains and levels prior to set on site, before and during construction.
- All materials specified or selected to be fixed in strict accordance with manufacturers specifications warranties and BRANZ appraisals and by licensed applicators.
- All work to be carried out to best trade practice.

© COPYRIGHT of The Little Design Company Ltd
AMENDMENTS:

LITTIN, LITTLE & ASSOCIATES
ARCHITECTURE & INTERIOR DESIGN

The Little Design Company Ltd
PO Box 104 009, Auckland 1230
295 Lincoln Road, Waitakere City, Auckland
P: 09-836-6744, F: 09-836-6755, M: 0274-144-657
Email: rexlittledesign@gmail.com

PROJECT:

**PROPOSED
NEW RESIDENCE
FOR
MR & MRS M GOLDSMITH
AT
193 CULLEN RD
WAIPU**

DRAWING TITLE:

SECTIONS

DATE: NOVEMBER 2014


SCALE: 1:50 A1 1:100 A3

JOB NO. 119



DRAWING NO. OF

12

DETAILS	1:10 A1.
	1:20 A3.

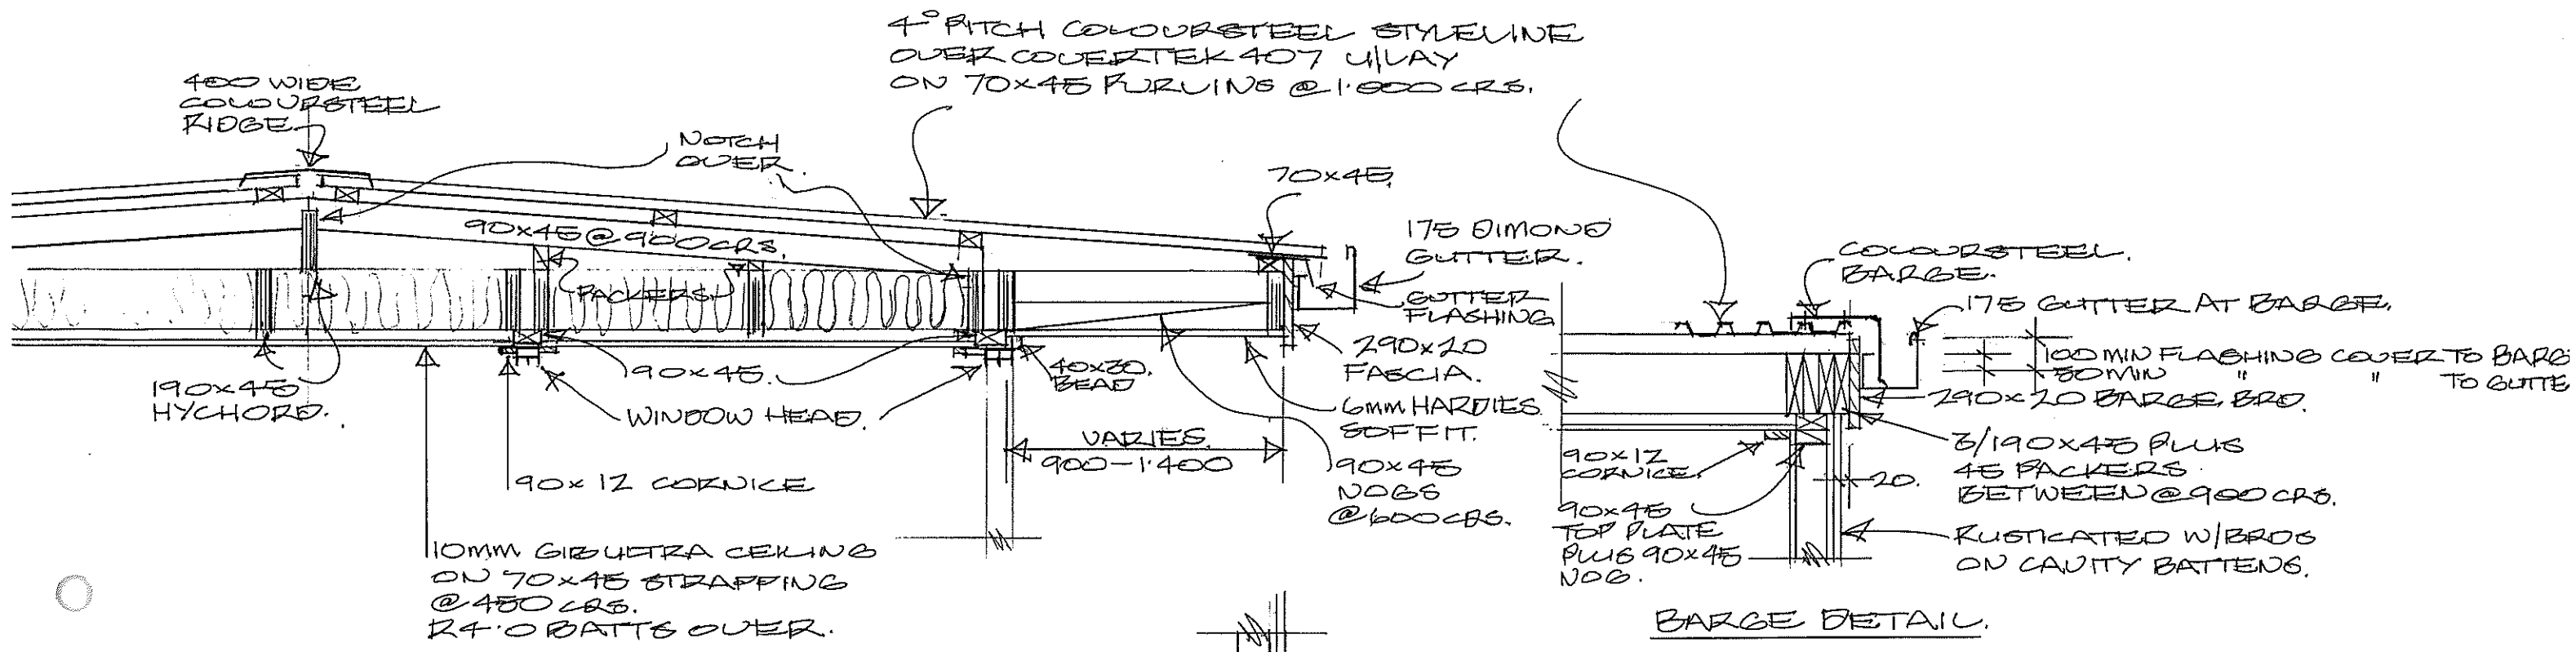

STAIRCASE ROOF DETAIL. (5/12)

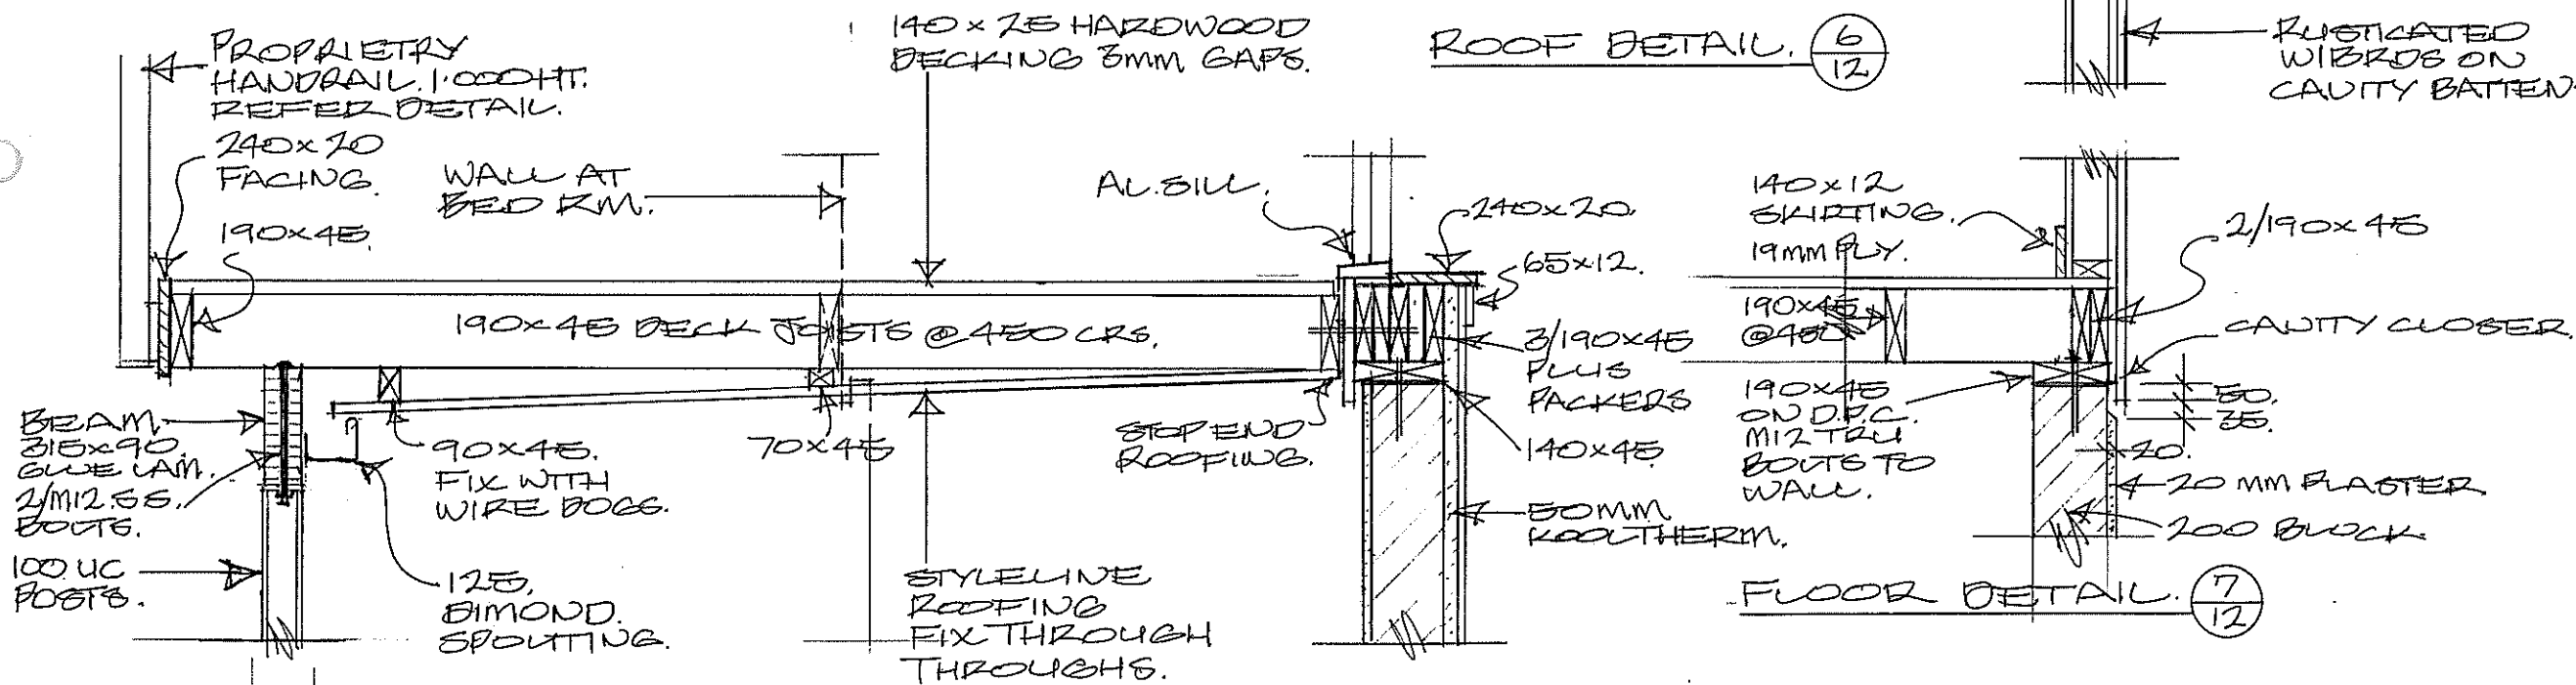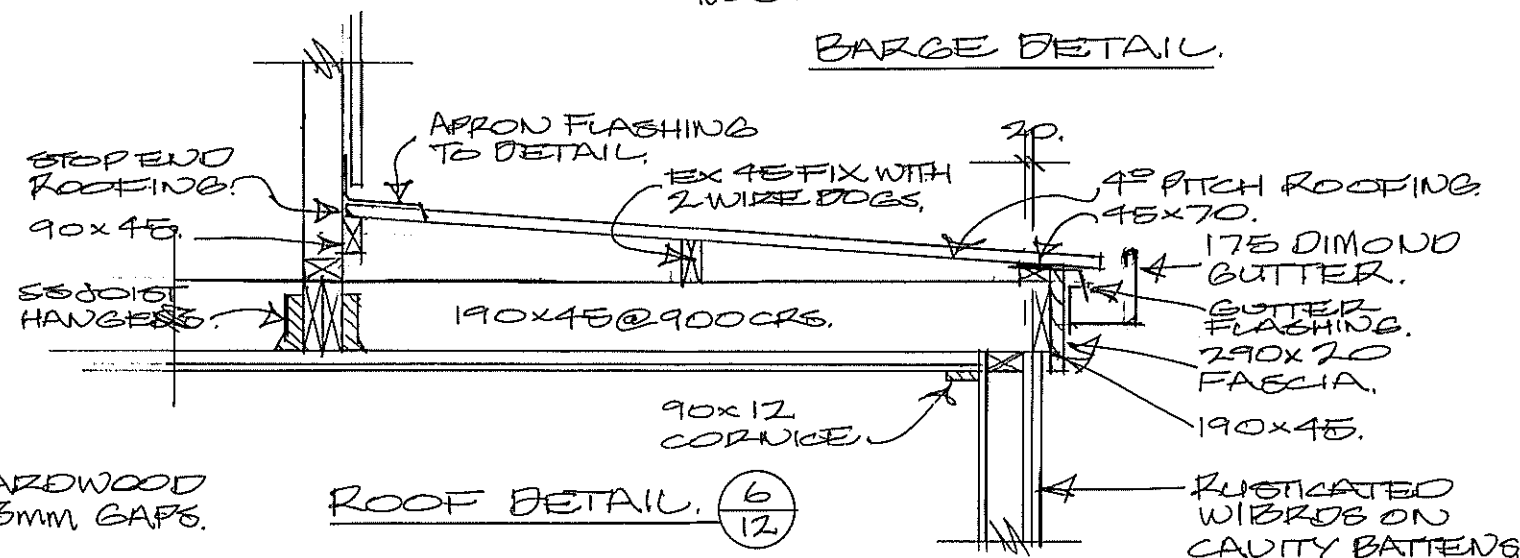

ROOFING UNDER DECKING. (8/12)

DETAILS	1:10 A1.
	1:20 A3.

- NOTES:
- All work is to comply with NZS 3604, The N.Z. Building Code, regulations and associated documents.
 - Contractor to check all dimensions, heights, structure set outs, drains and levels prior to start on site, before and during construction.
 - All materials specified or selected to be fixed in strict accordance with manufacturers specifications warranties and BRANZ appraisals and by licensed applicators.
 - All work to be carried out to best trade practice.

© COPYRIGHT of The Little Design Company Ltd
AMENDMENTS:

LITTIN, LITTLE & ASSOCIATES
ARCHITECTURE & INTERIOR DESIGN

The Little Design Company Ltd
PO Box 104 009, Auckland 1230
295 Lincoln Road, Waitakere City, Auckland
P: 09-838-8744, F: 09-838-8755, M: 0274-144-657
Email: roxi@littledesign.com







PROJECT:
**PROPOSED
NEW RESIDENCE
FOR
MR & MRS M GOLDSMITH
AT
193 CULLEN RD
WAIPU**

DRAWING TITLE:

DETAILS.

DATE: NOVEMBER 2014
SCALE: 1:10 A1 1:20 A3
JOB NO.: 119
DRAWING NO. OF

14

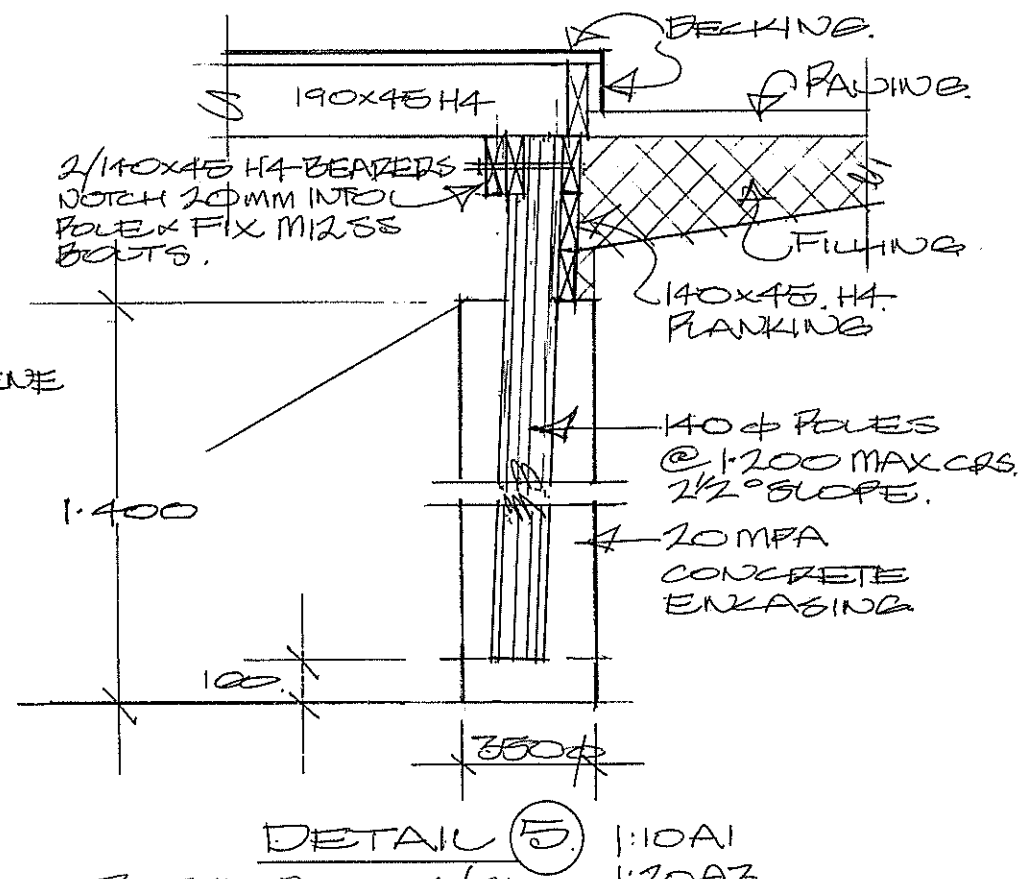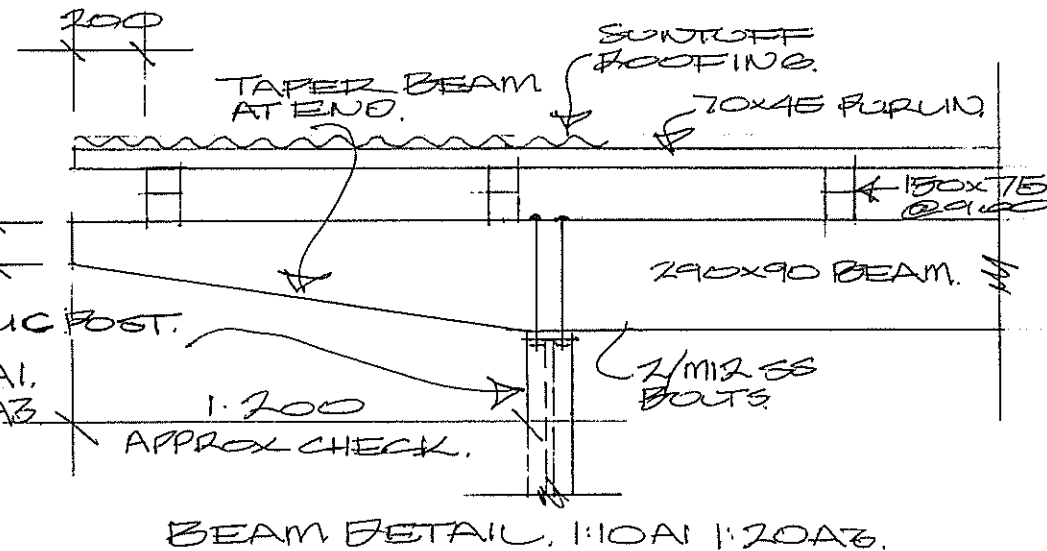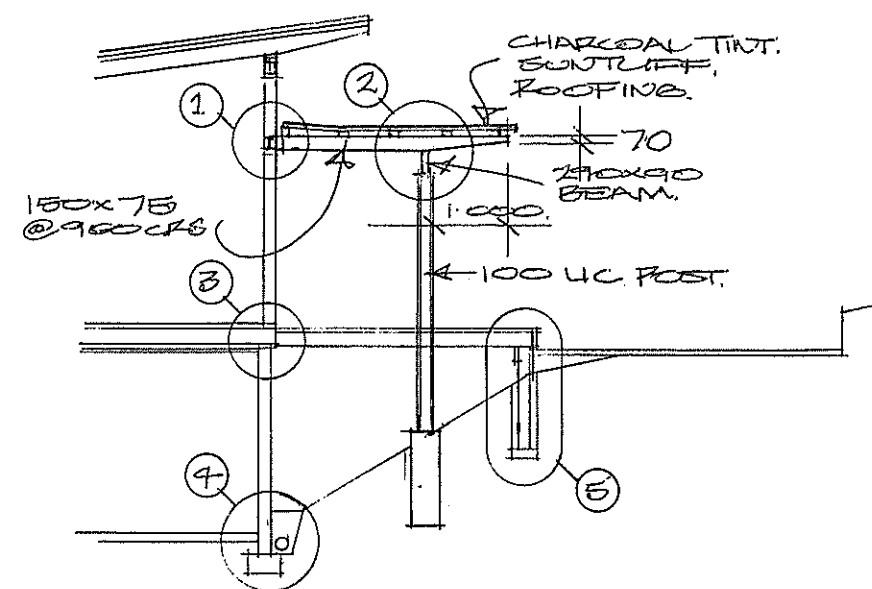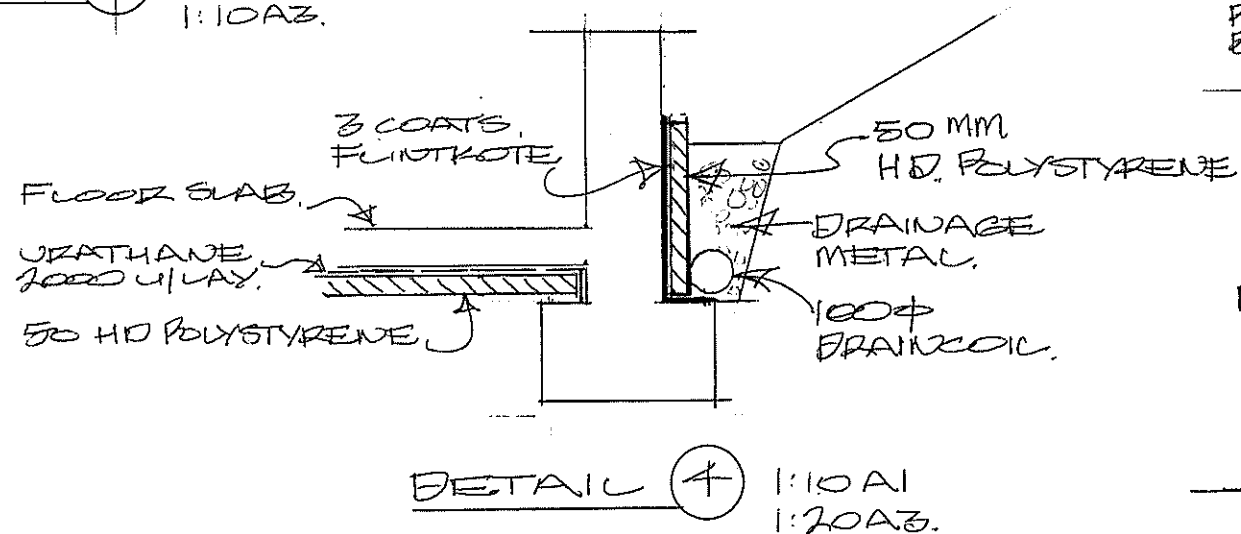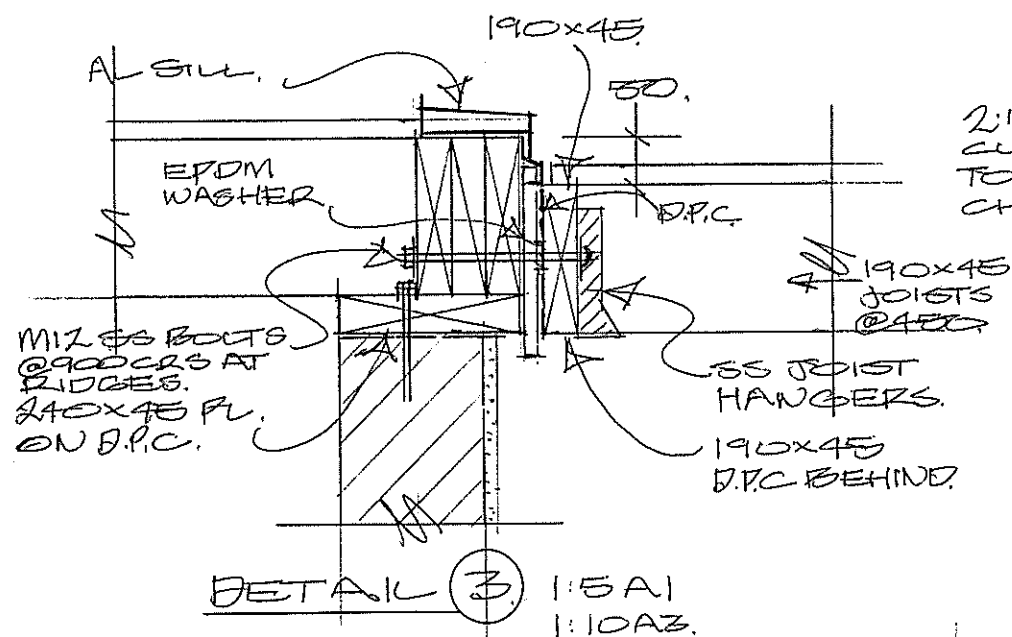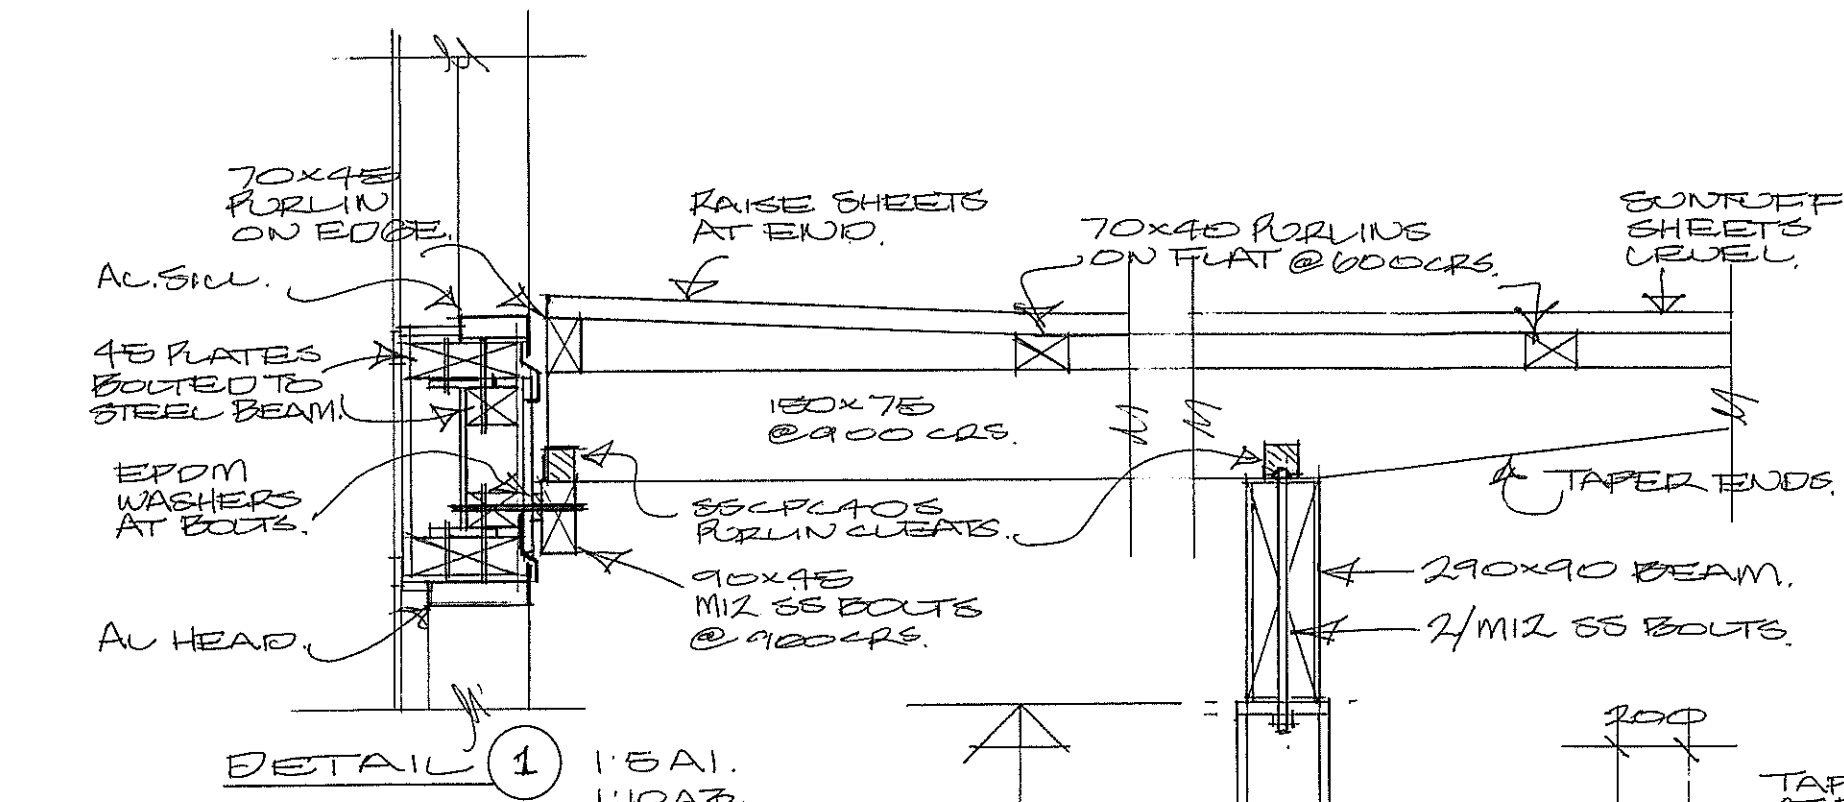

NOTE: ALL FIXINGS AND BOLTS TO BE STAINLESS STEEL WITH 50mm WASHER TO TIMBER.

- NOTES:
1. All work to comply with NZS 3604, The N.Z. Building Code, regulations and associated documents.
 2. Contractor to check all dimensions, heights, structure set outs, drains and levels prior to start on site, before and during construction.
 3. All materials specified or selected to be fixed in strict accordance with manufacturers specifications warranties and BRANZ appraisals and by licensed applicators.
 4. All work to be carried out to best trade practice.

© COPYRIGHT of The Little Design Company Ltd
AMENDMENTS:


LITTIN, LITTLE & ASSOCIATES
ARCHITECTURE & INTERIOR DESIGN

The Little Design Company Ltd
PO Box 104 009, Auckland 1230
295 Lincoln Road, Waitakere City, Auckland
P: 09-836-6744, F: 09-836-6755, M: 0274-144-657
Email: lexlittleddesign@gmail.com


PROJECT:
PROPOSED
NEW RESIDENCE
FOR
MR & MRS M GOLDSMITH
AT
193 CULLEN RD
WAIPU

DRAWING TITLE:
PERGOLA
DETAILS.

DATE: NOVEMBER 2014
SCALES: 1:5 1:10 1:50 AI 1:10 1:20 AZ
JOB NO.: 119
DRAWING NO. OF

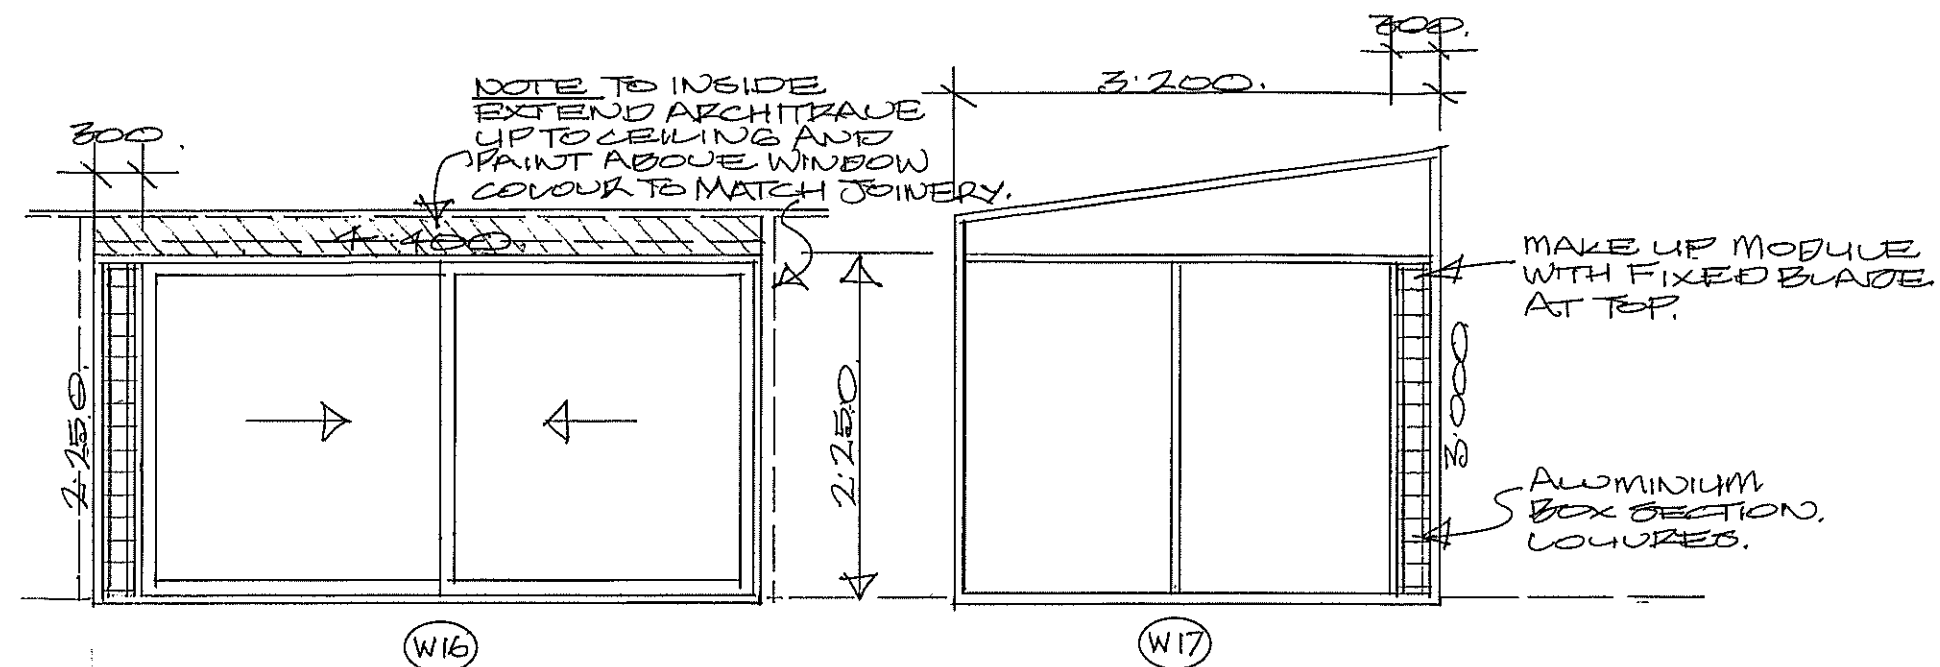

GROUND FLOOR JOINERY.

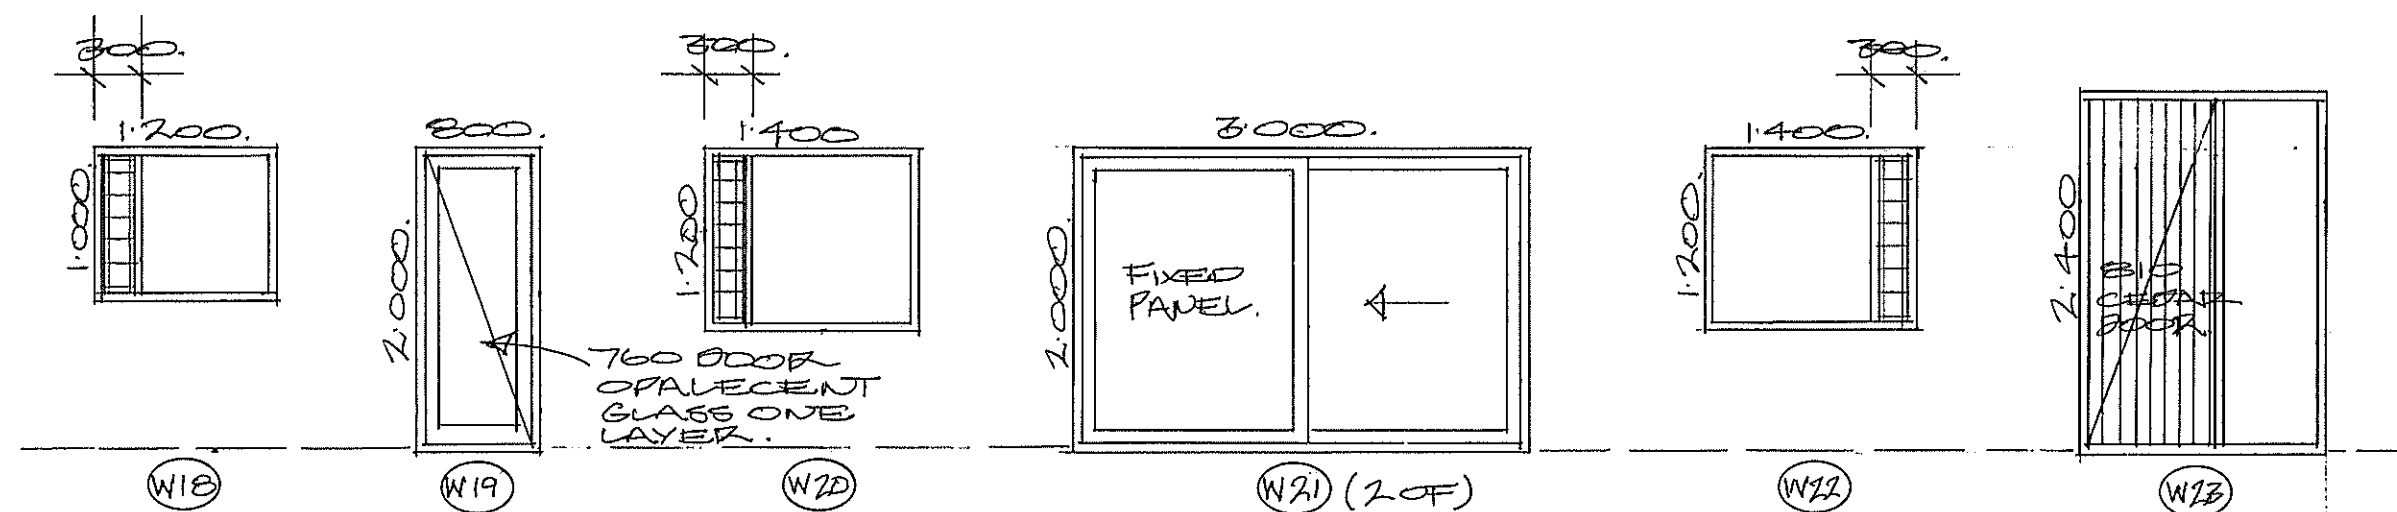

- NOTES:
1. All work is to comply with NZS 3604, The N.Z. Building Code, regulations and associated documents.
 2. Contractor to check all dimensions, heights, structure set outs, drains and levels prior to start on site, before and during construction.
 3. All materials specified or selected to be fixed in strict accordance with manufacturers specifications warranties and BRANZ appraisals and by licensed applicators.
 4. All work to be carried out to best trade practice.

© COPYRIGHT of The Little Design Company Ltd
AMENDMENTS:

LITTIN, LITTLE & ASSOCIATES
ARCHITECTURE & INTERIOR DESIGN

The Little Design Company Ltd
PO Box 104 009, Auckland 1230
295 Lincoln Road, Waitakere City, Auckland
P: 09-836-6744, F: 09-836-6755, M: 0274-144-657
Email: rex@littlidesign.com

PROJECT:

PROPOSED
NEW RESIDENCE
FOR
MR & MRS M GOLDSMITH
AT
193 CULLEN RD
WAIPU

DRAWING TITLE:

JOINERY
ELEVATIONS.

DATE: NOVEMBER 2014


SCALES: 1:25 A1, 1:50 A3.

JOB NO.: 119

DRAWING NO. OF






JOINERY ELEVATIONS	1:25 A1.
	1:50 A3.

17

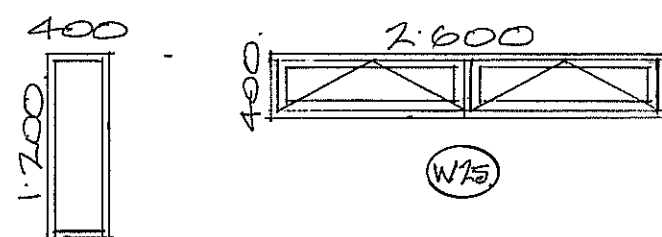

W74 (2 OF)

     BASEMENT JOINERY.



WINDOWS.

JOINERY DETAILS	1:2 A1.
METAL CLADDING	1:4 A3.

NOTES:

1. All work is to comply with NZS 3604, The N.Z. Building Code, regulations and associated documents.
2. Contractor to check all dimensions, heights, structure set outs, drains and levels prior to start on site, before and during construction.
3. All materials specified or selected to be fixed in strict accordance with manufacturers specifications warranties and BRANZ appraisals and by licensed applicators.
4. All work to be carried out to best trade practice.

© COPYRIGHT of The Little Design Company Ltd
AMENDMENTS:

LITTIN, LITTLE & ASSOCIATES
ARCHITECTURE & INTERIOR DESIGN

The Little Design Company Ltd
PO Box 104 009, Auckland 1230
295 Lincoln Road, Waitakere City, Auckland
P: 09-836-6744, F: 09-836-6755, M: 0274-144-657
Email: rextilliedesign@gmail.com

PROJECT:

PROPOSED
NEW RESIDENCE
FOR
MR & MRS M GOLDSMITH
AT
193 CULLEN RD
WAIPU

DRAWING TITLE:


JOINERY DETAILS

DATE: NOVEMBER 2014


SCALES: 1:2 A1 1:4 A3

JOB NO.: 119


DRAWING NO. OF

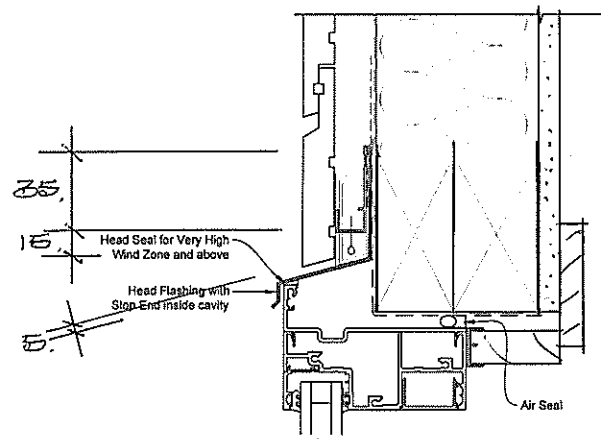


HEAD DETAIL.

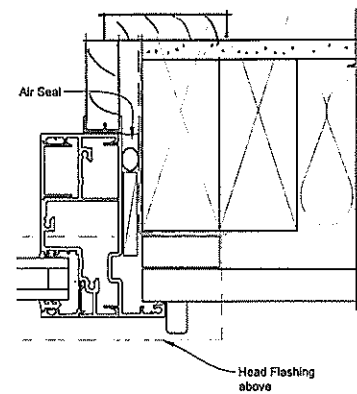

JAMB DETAIL.

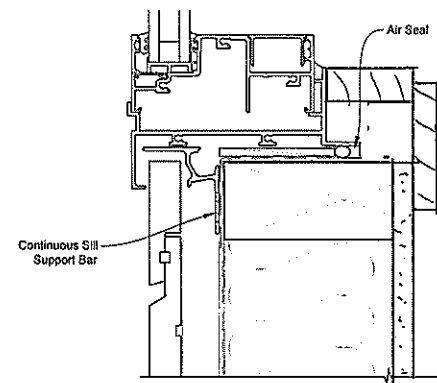

SILL DETAIL.

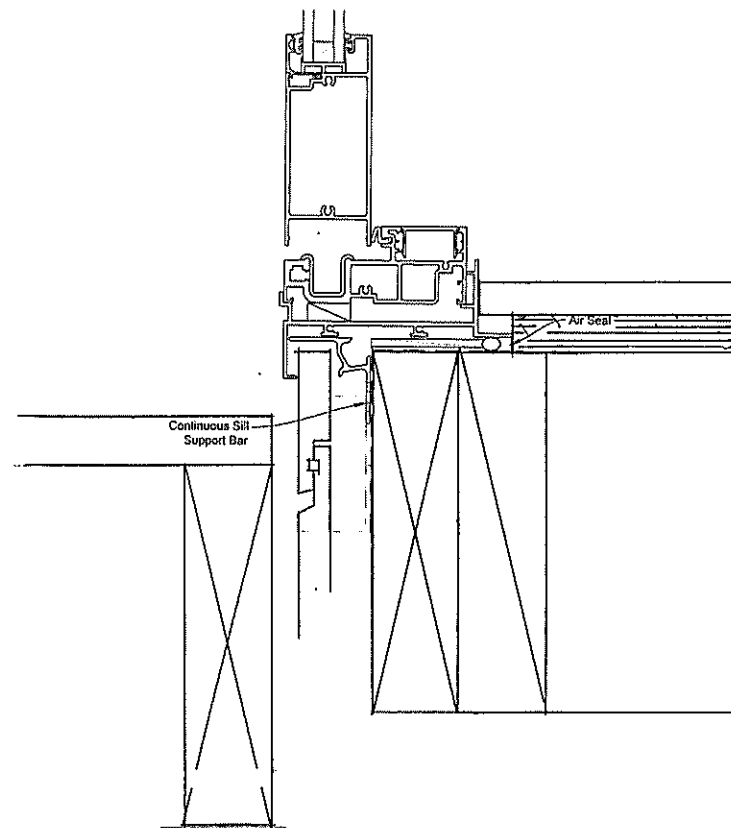

DOOR SILL DETAIL.

JOINERY DETAILS	1:2 A1.
TIMBER CLADDING.	1:3 A3.

NOTES:

1. All work is to comply with NZS 3604, The N.Z. Building Code, regulations and associated documents.
2. Contractor to check all dimensions, heights, structure set outs, drains and levels prior to start on site, before and during construction.
3. All materials specified or selected to be fixed in strict accordance with manufacturers specifications warranties and BRANZ appraisals and by licensed applicators.
4. All work to be carried out to best trade practice.

© COPYRIGHT of The Little Design Company Ltd
AMENDMENTS:

LITTIN, LITTLE & ASSOCIATES
ARCHITECTURE & INTERIOR DESIGN

The Little Design Company Ltd
PO Box 104 009, Auckland 1230
295 Lincoln Road, Waitakere City, Auckland
P: 09-836-6744, F: 09-836-6755, M: 0274-144-657
Email: rex@littledesign.co.nz

PROJECT:

**PROPOSED
NEW RESIDENCE
FOR
MR & MRS M GOLDSMITH
AT
193 CULLEN RD
WAIPU**

DRAWING TITLE:


**JOINERY
DETAILS.**

DATE: NOVEMBER 2014


SCALE: 1:2 A1 1:4 A3

JOB NO.: 119


DRAWING NO. OF

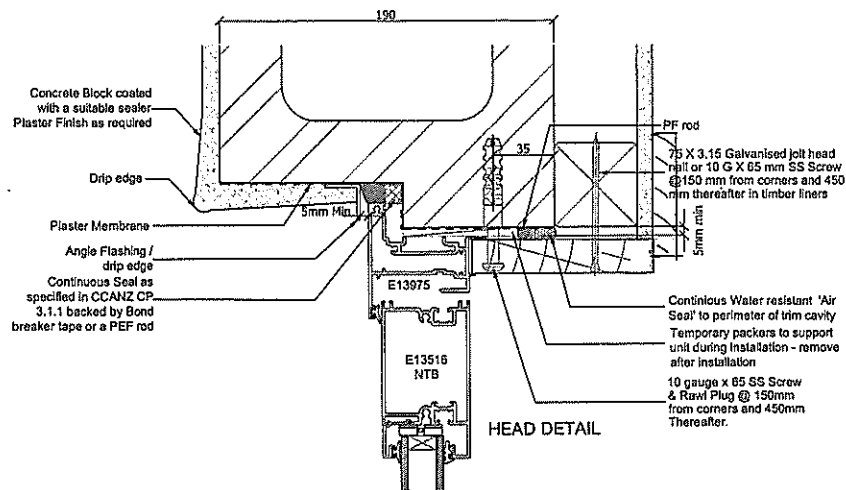


HEAD DETAIL.

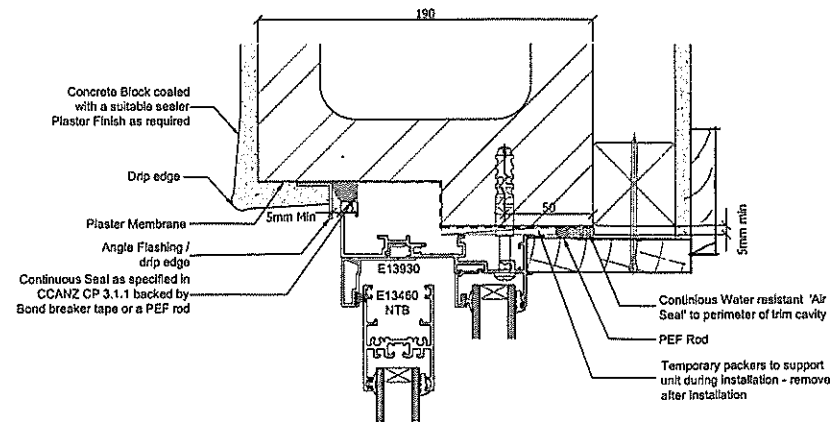


HEAD DETAIL.

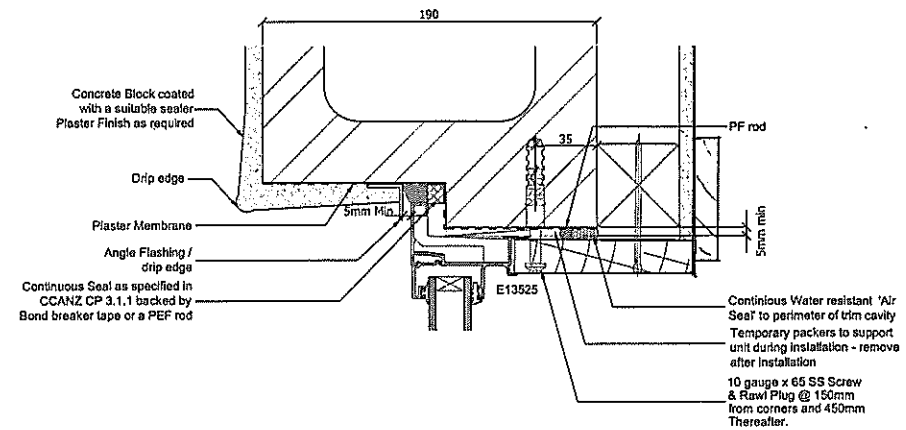


HEAD DETAIL.

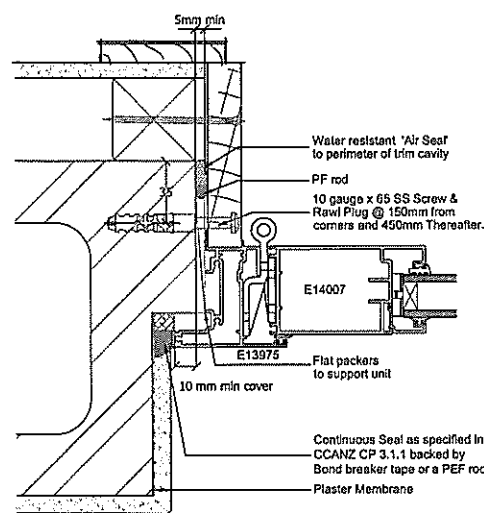


JAMB DETAIL.

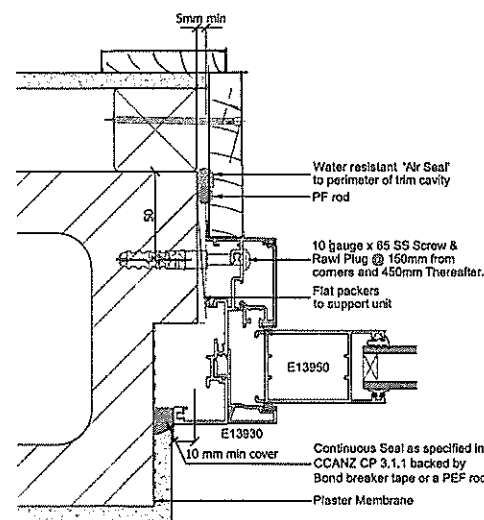

JAMB DETAIL.

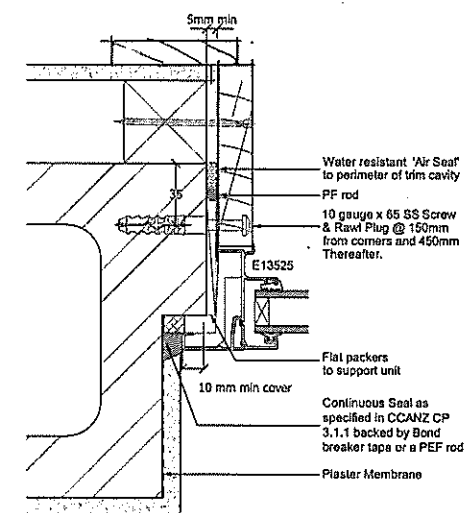


JAMB DETAIL.

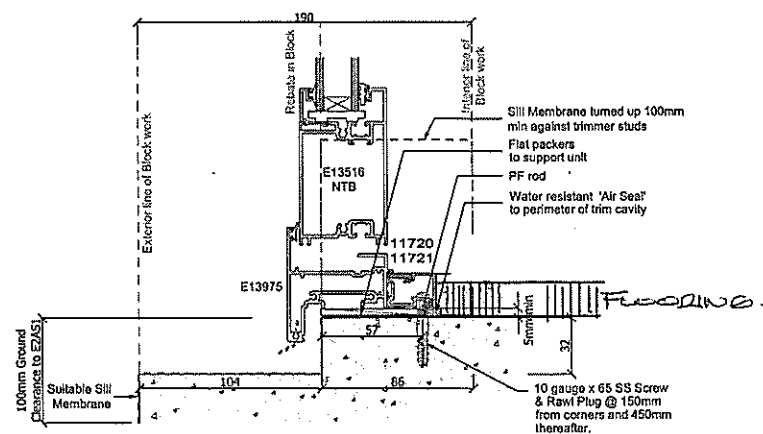


SILL DETAIL.

DOORS.

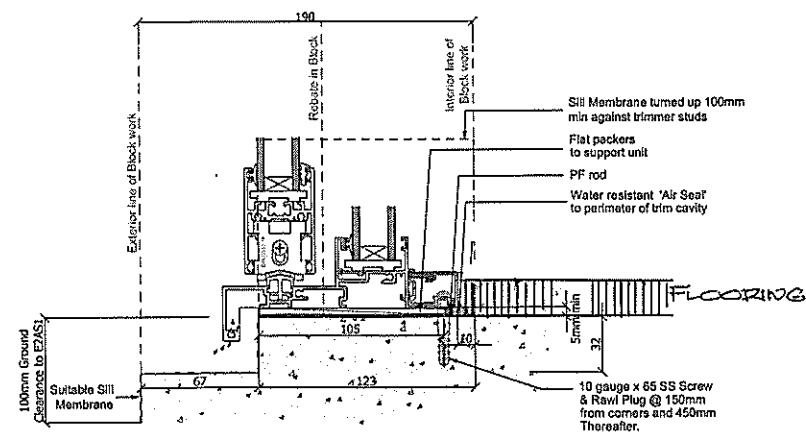

SILL DETAIL.

SLIDING DOORS

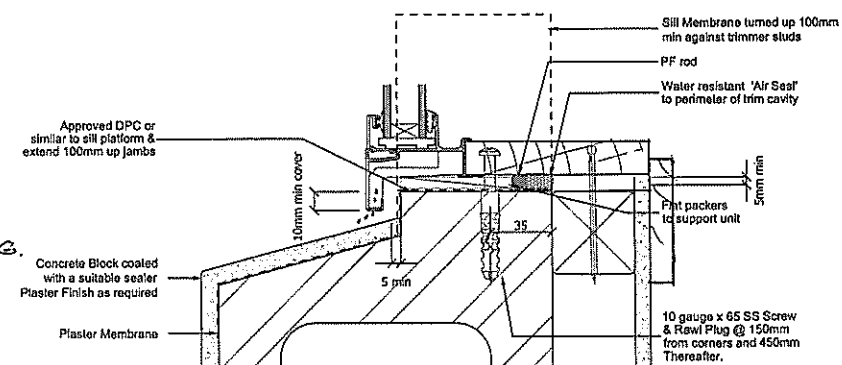

SILL DETAIL.

WINDOWS

- NOTES:**
1. All work is to comply with NZS 3604, The N.Z. Building Code, regulations and associated documents.
 2. Contractor to check all dimensions, heights, structure set outs, drains and levels prior to start on site, before and during construction.
 3. All materials specified or selected to be fixed in strict accordance with manufacturers specifications warranties and BRANZ appraisals and by licensed applicators.
 4. All work to be carried out to best trade practice.

© COPYRIGHT of The Little Design Company Ltd
AMENDMENTS:

LITTIN, LITTLE & ASSOCIATES
ARCHITECTURE & INTERIOR DESIGN

The Little Design Company Ltd
PO Box 104 009, Auckland 1230
295 Lincoln Road, Waiakera City, Auckland
P: 09-836-6744, F: 09-836-6755, M: 0274-144-657
Email: rexlittledesign@gmail.com

PROJECT:
**PROPOSED
NEW RESIDENCE
FOR
MR & MRS M GOLDSMITH
AT
193 CULLEN RD
WAIPU**


 











DRAWING TITLE:
**BASEMENT
JOINERY
DETAILS.**

DATE: NOVEMBER 2014
SCALE: 1:2 A1, 1:4 A3.
JOB NO.: 119
DRAWING NO. OF

BASEMENT JOINERY DETAILS
TO BLOCK WALLS.

1:2 A1.
1:4 A3.

20

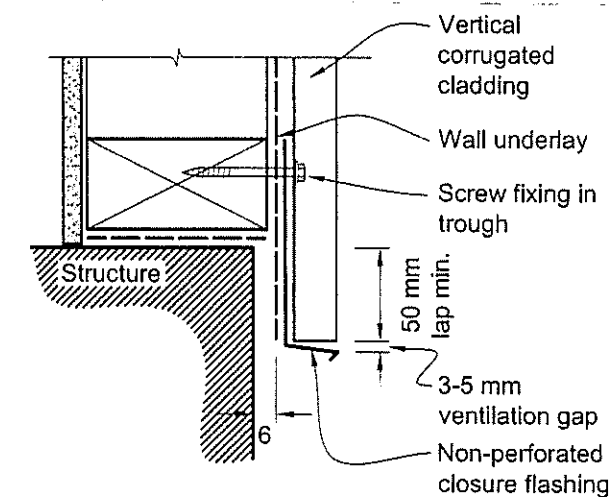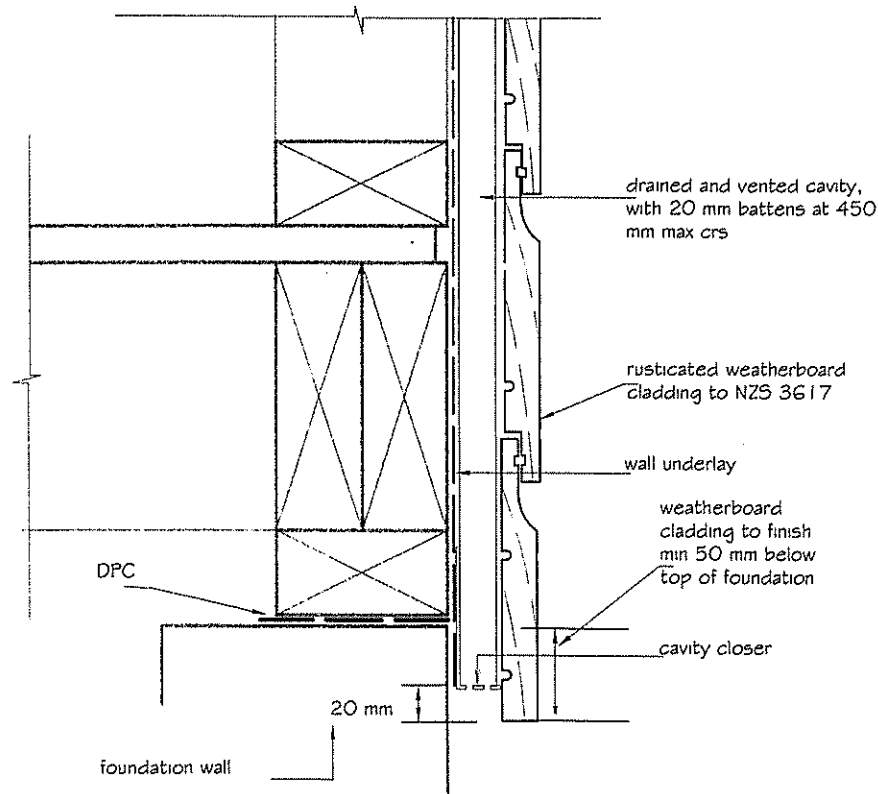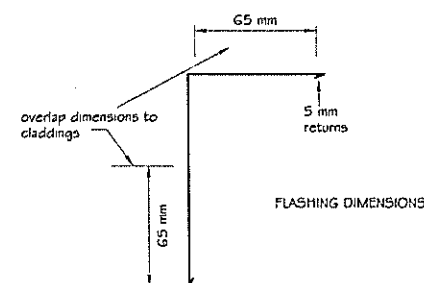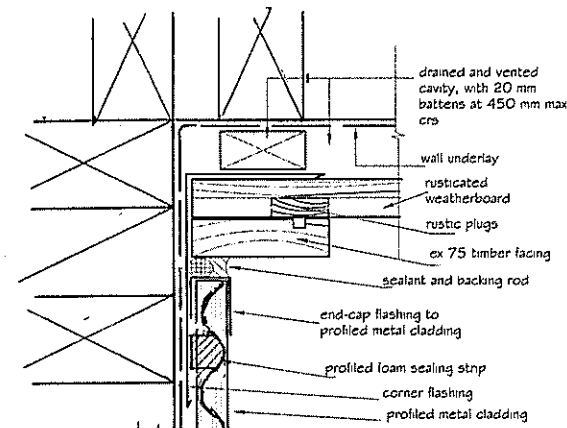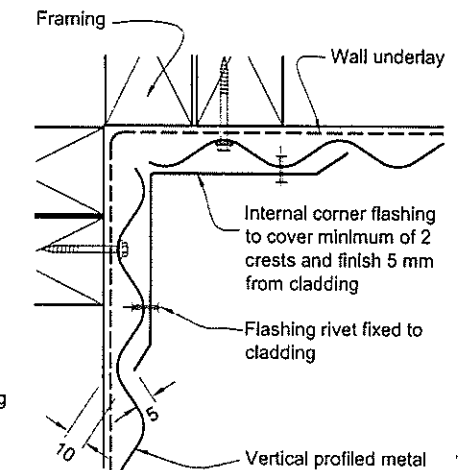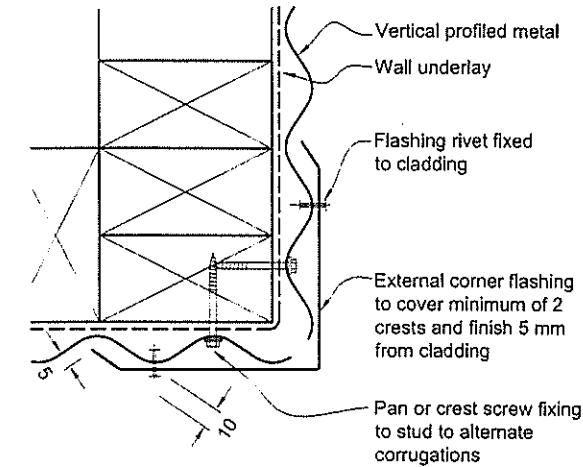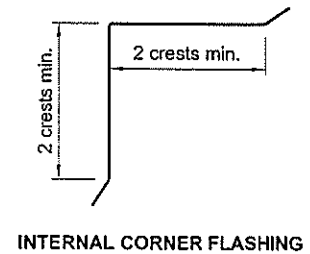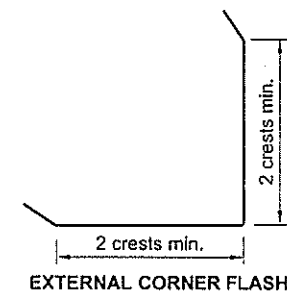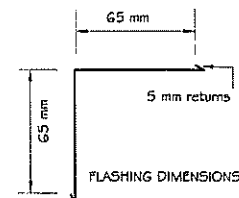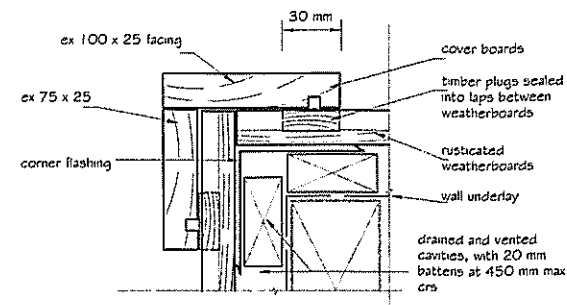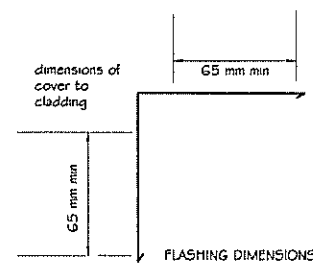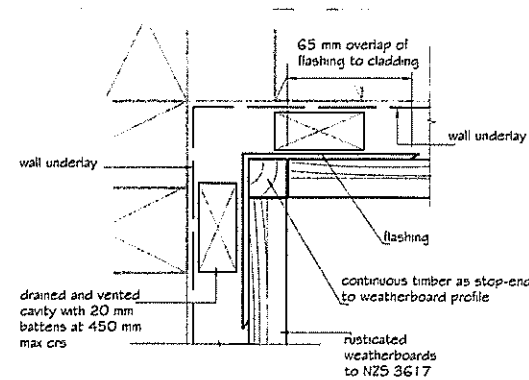

- NOTES:**
1. All work is to comply with NZS 3604, The N.Z. Building Code, regulations and associated documents.
 2. Contractor to check all dimensions, heights, structure set outs, drains and levels prior to start on site, before and during construction.
 3. All materials specified or selected to be fixed in strict accordance with manufacturers specifications warranties and BRANZ appraisals and by licensed applicators.
 4. All work to be carried out to best trade practice.

© COPYRIGHT of The Little Design Company Ltd
AMENDMENTS:

LITTIN, LITTLE & ASSOCIATES
ARCHITECTURE & INTERIOR DESIGN

The Little Design Company Ltd
PO Box 104 009, Auckland 1230
295 Lincoln Road, Waitakere City, Auckland
P: 09-836-6744, F: 09-836-6755, M: 0274-144-657
Email: rexlifedesign@gmail.com

PROJECT: _____

PROPOSED
NEW RESIDENCE
FOR
MR & MRS M GOLDSMITH
AT
193 CULLEN RD
WAIPU

DRAWING TITLE:

CLADDING DETAILS.


DATE: NOVEMBER 2014

SCALES: 1:ZA 1:4-A3.

JOB NO.: 119

DRAWING NO. OF

21

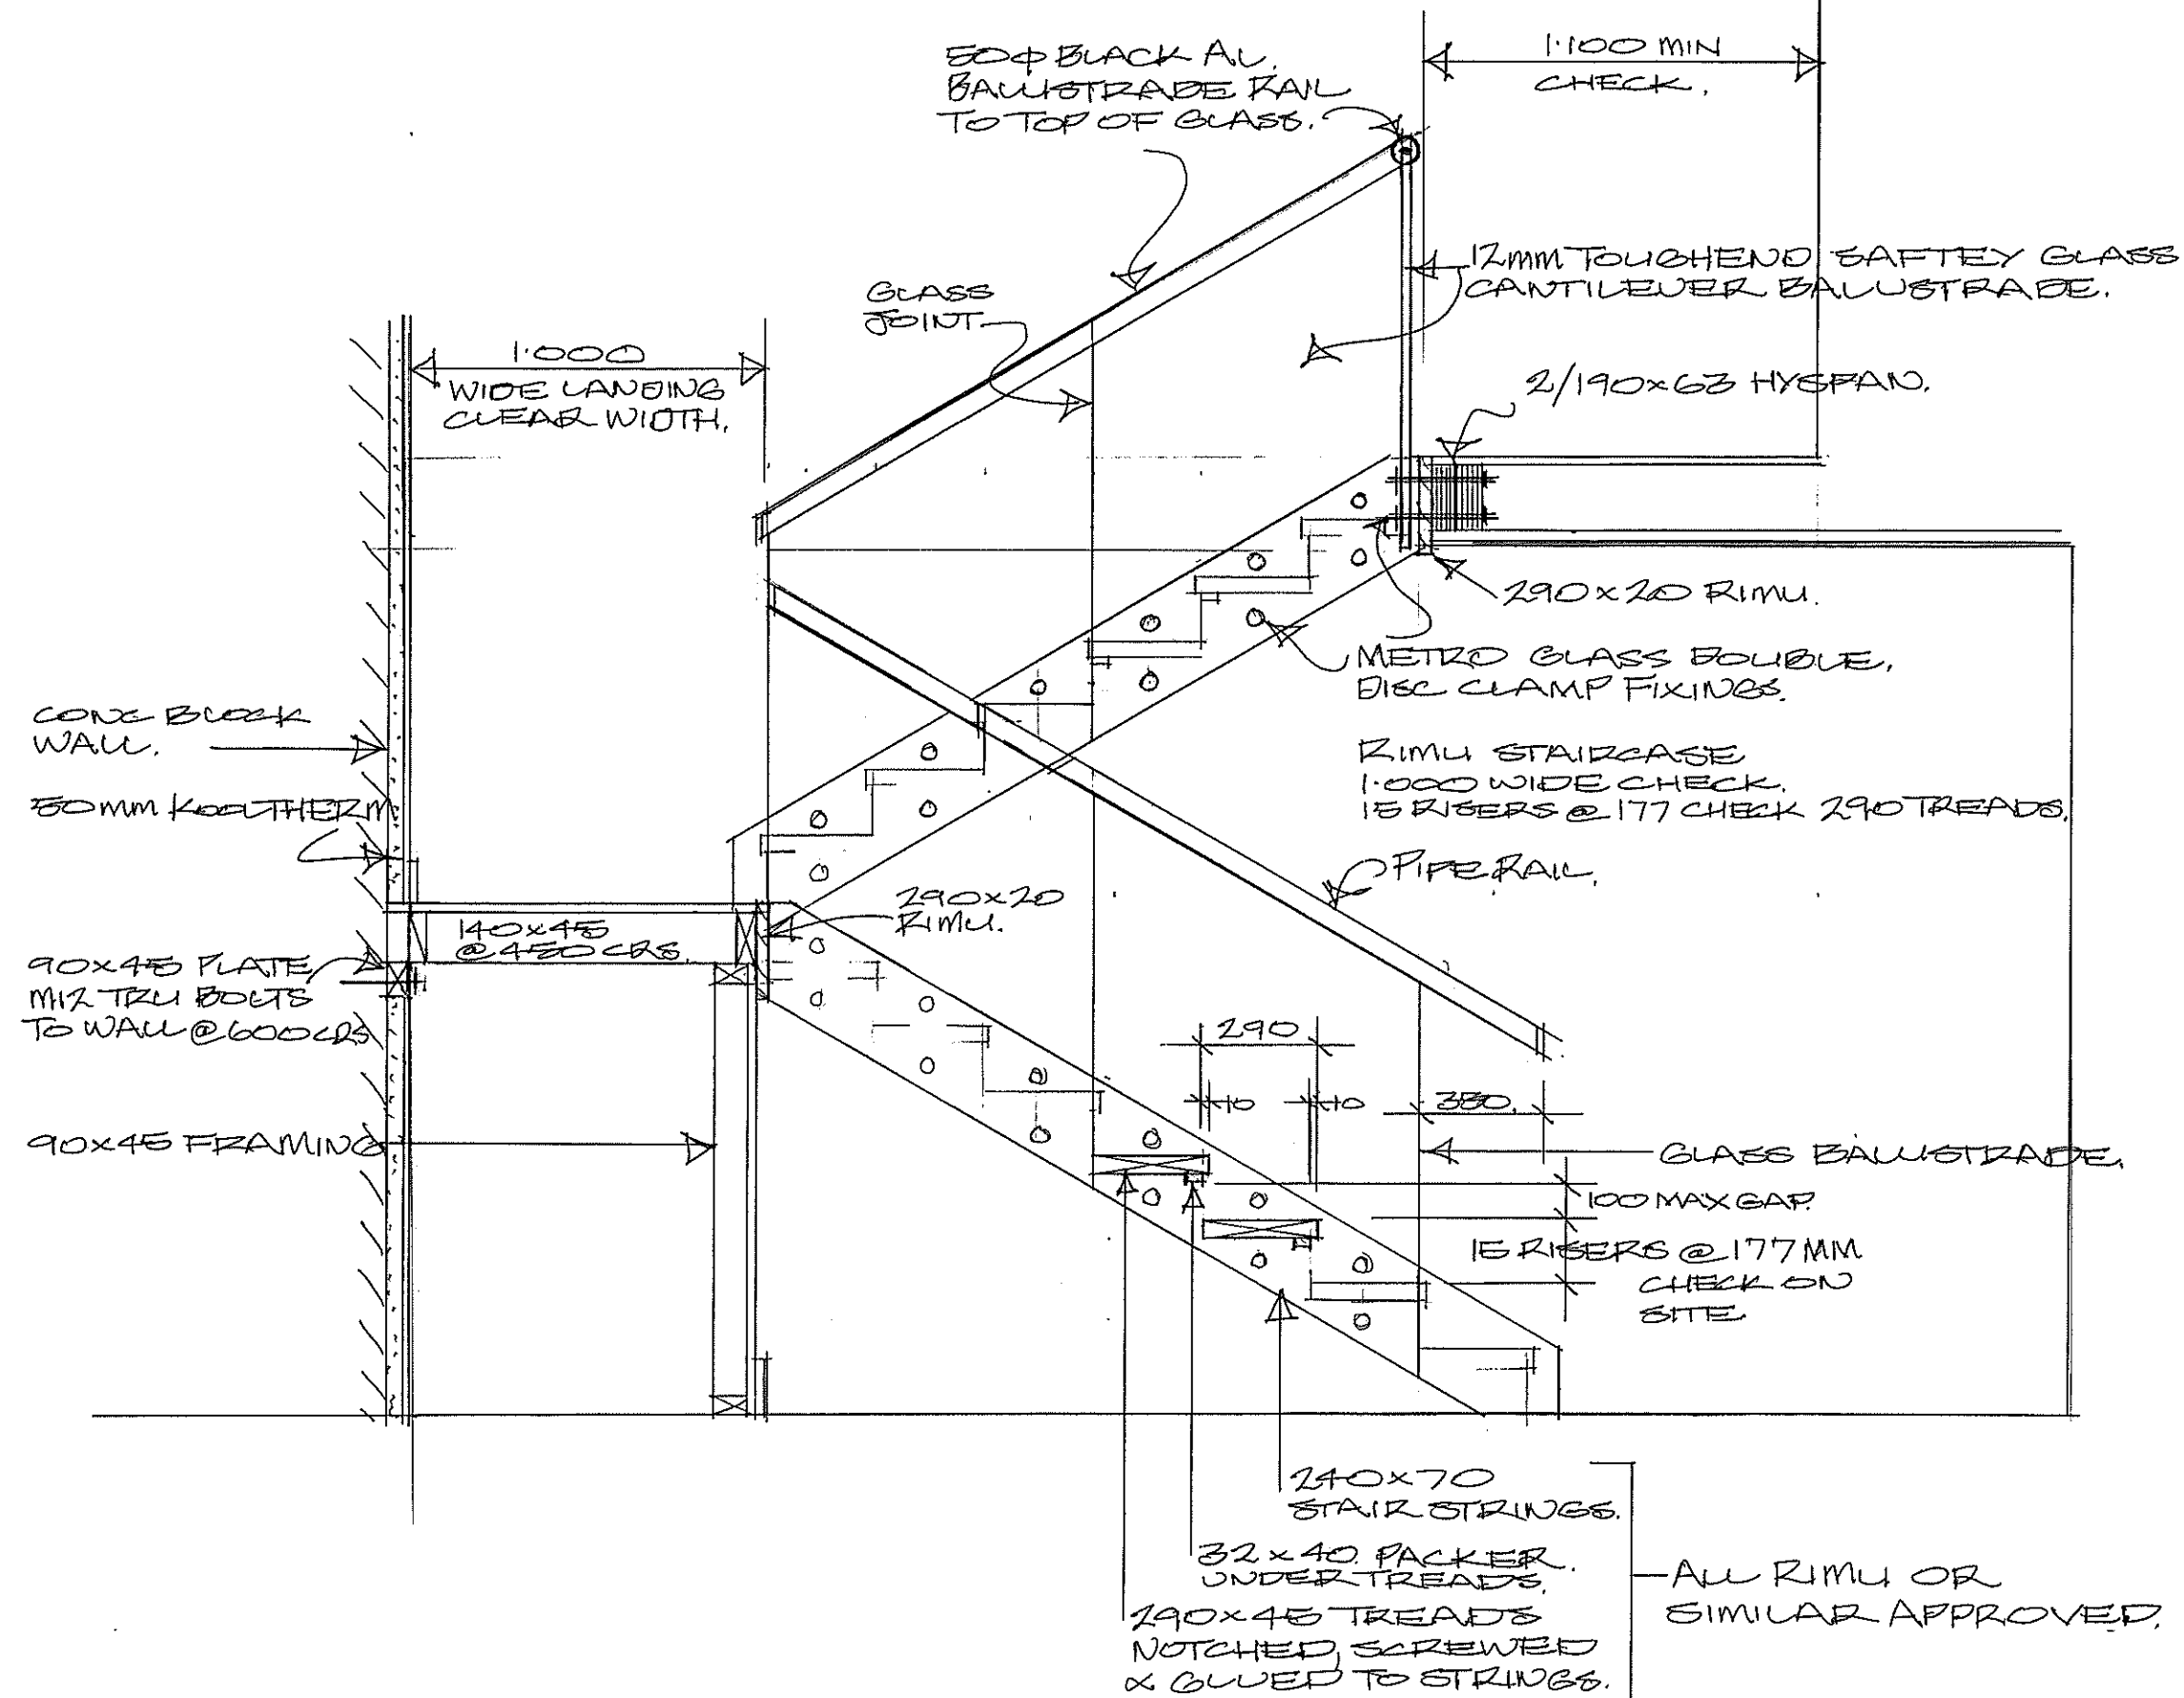

STAIRCASE DETAIL 1:10 A1
1:20 A3.

NOTES:

1. All work is to comply with NZS 3604, The N.Z. Building Code, regulations and associated documents.
2. Contractor to check all dimensions, heights, structure set outs, drains and levels prior to site on site, before and during construction.
3. All materials specified or selected to be fixed in strict accordance with manufacturers specifications warranties and BRANZ appraisal and by licensed applicators.
4. All work to be carried out to best trade practice

© COPYRIGHT of The Little Design Company Ltd
AMENDMENTS:

LITTIN, LITTLE & ASSOCIATES
ARCHITECTURE & INTERIOR DESIGN

The Little Design Company Ltd
PO Box 104 009, Auckland 1230
295 Lincoln Road, Waitakere City, Auckland
P: 09-836-6744, F: 09-836-6755, M: 0274-144-657
Email: rodlittledesigns@gmail.com

PROJECT:

PROPOSED
NEW RESIDENCE
FOR
MR & MRS M GOLDSMITH
AT
193 CULLEN RD
WAIPU

DRAWING TITLE:

STAIRCASE
DETAIL.

DATE: NOVEMBER 2014

SCALE: 1:10 A1 1:20 A3

JOB NO. 119

DRAWING NO. OF

ELECTRICAL LEGEND,

No OF

SYMBOLS	
X	SWITCHES
XD	LIGHT SWITCH - - - - -
XD	DIMMER SWITCH - - - - -
XF	FAN SWITCH - REVERSABLE - - - - -
	- SUPERLUX FITTINGS WITH THERMAL CUT OFF FOR FIRE PROTECTION.
⊗	RECESSED INTERIOR LIGHT
⊗	RECESSED EXTERIOR LIGHT
⊗	RECESSED SPOT LIGHT
⊗	SUSPENDED INCANDESCENT LIGHT
⊗	WALL LIGHT - - - - -
⊗	UP LIGHTER - - - - -
⊗	STAIR TREAD LIGHT - SENSOR SWITCHED
⊗	DOUBLE SPOT LIGHT - - - - -
⊗	LIGHT SENSOR - - - - -
⊗	SUSPENDED TRACK LIGHTING
▽	POWER OUTLETS
▽	SINGLE POWER OUTLET
▽	DOUBLE POWER OUTLET
▽	EARTH LEAKAGE OUTLET
▽	HEATED TOWEL RAIL - - - - -
▽	PHONE OUTLET - - - - -
⊗	MISCELLANEOUS
⊗	3 IN 1 HEAT LIGHT FAN - EXTERIOR
⊗	AUTO DOOR OPENER - - - - -
⊗	CEILING FAN - - - - -
⊗	SMOKE DETECTOR - - - - -
⊗	ALARM KEY PAD - - - - -
⊗	ALARM SENSOR - - - - -
⊗	HEAT PUMP - - - - -

NOTES:

1. All work is to comply with NZS 3604, The N.Z. Building Code, regulations and associated documents.
2. Contractor to check all dimensions, heights, structure set outs, drains and levels prior to start on site, before and during construction.
3. All materials specified or selected to be fixed in strict accordance with manufacturers specifications warranties and BRANZ appraisals and by licensed applicators.
4. All work to be carried out to best trade practice.

© COPYRIGHT of The Little Design Company Ltd

AMENDMENTS:

LITTIN, LITTLE & ASSOCIATES
ARCHITECTURE & INTERIOR DESIGN

The Little Design Company Ltd
PO Box 104 009, Auckland 1230
295 Lincoln Road, Waiakere City, Auckland
P: 09-836-6744, F: 09-836-6755, M: 0274-144-657
Email: rexlittledesign@gmail.com

PROJECT:

PROPOSED
NEW RESIDENCE
FOR
MR & MRS M GOLDSMITH
AT
193 CULLEN RD
WAIPU

DRAWING TITLE:


GROUND FLOOR
ELECTRICAL
LAYOUT PLAN.

DATE: NOVEMBER 2014


SCALES: 1:50 A1 1:100 A3.

JOB NO.: 119



DRAWING NO. OF

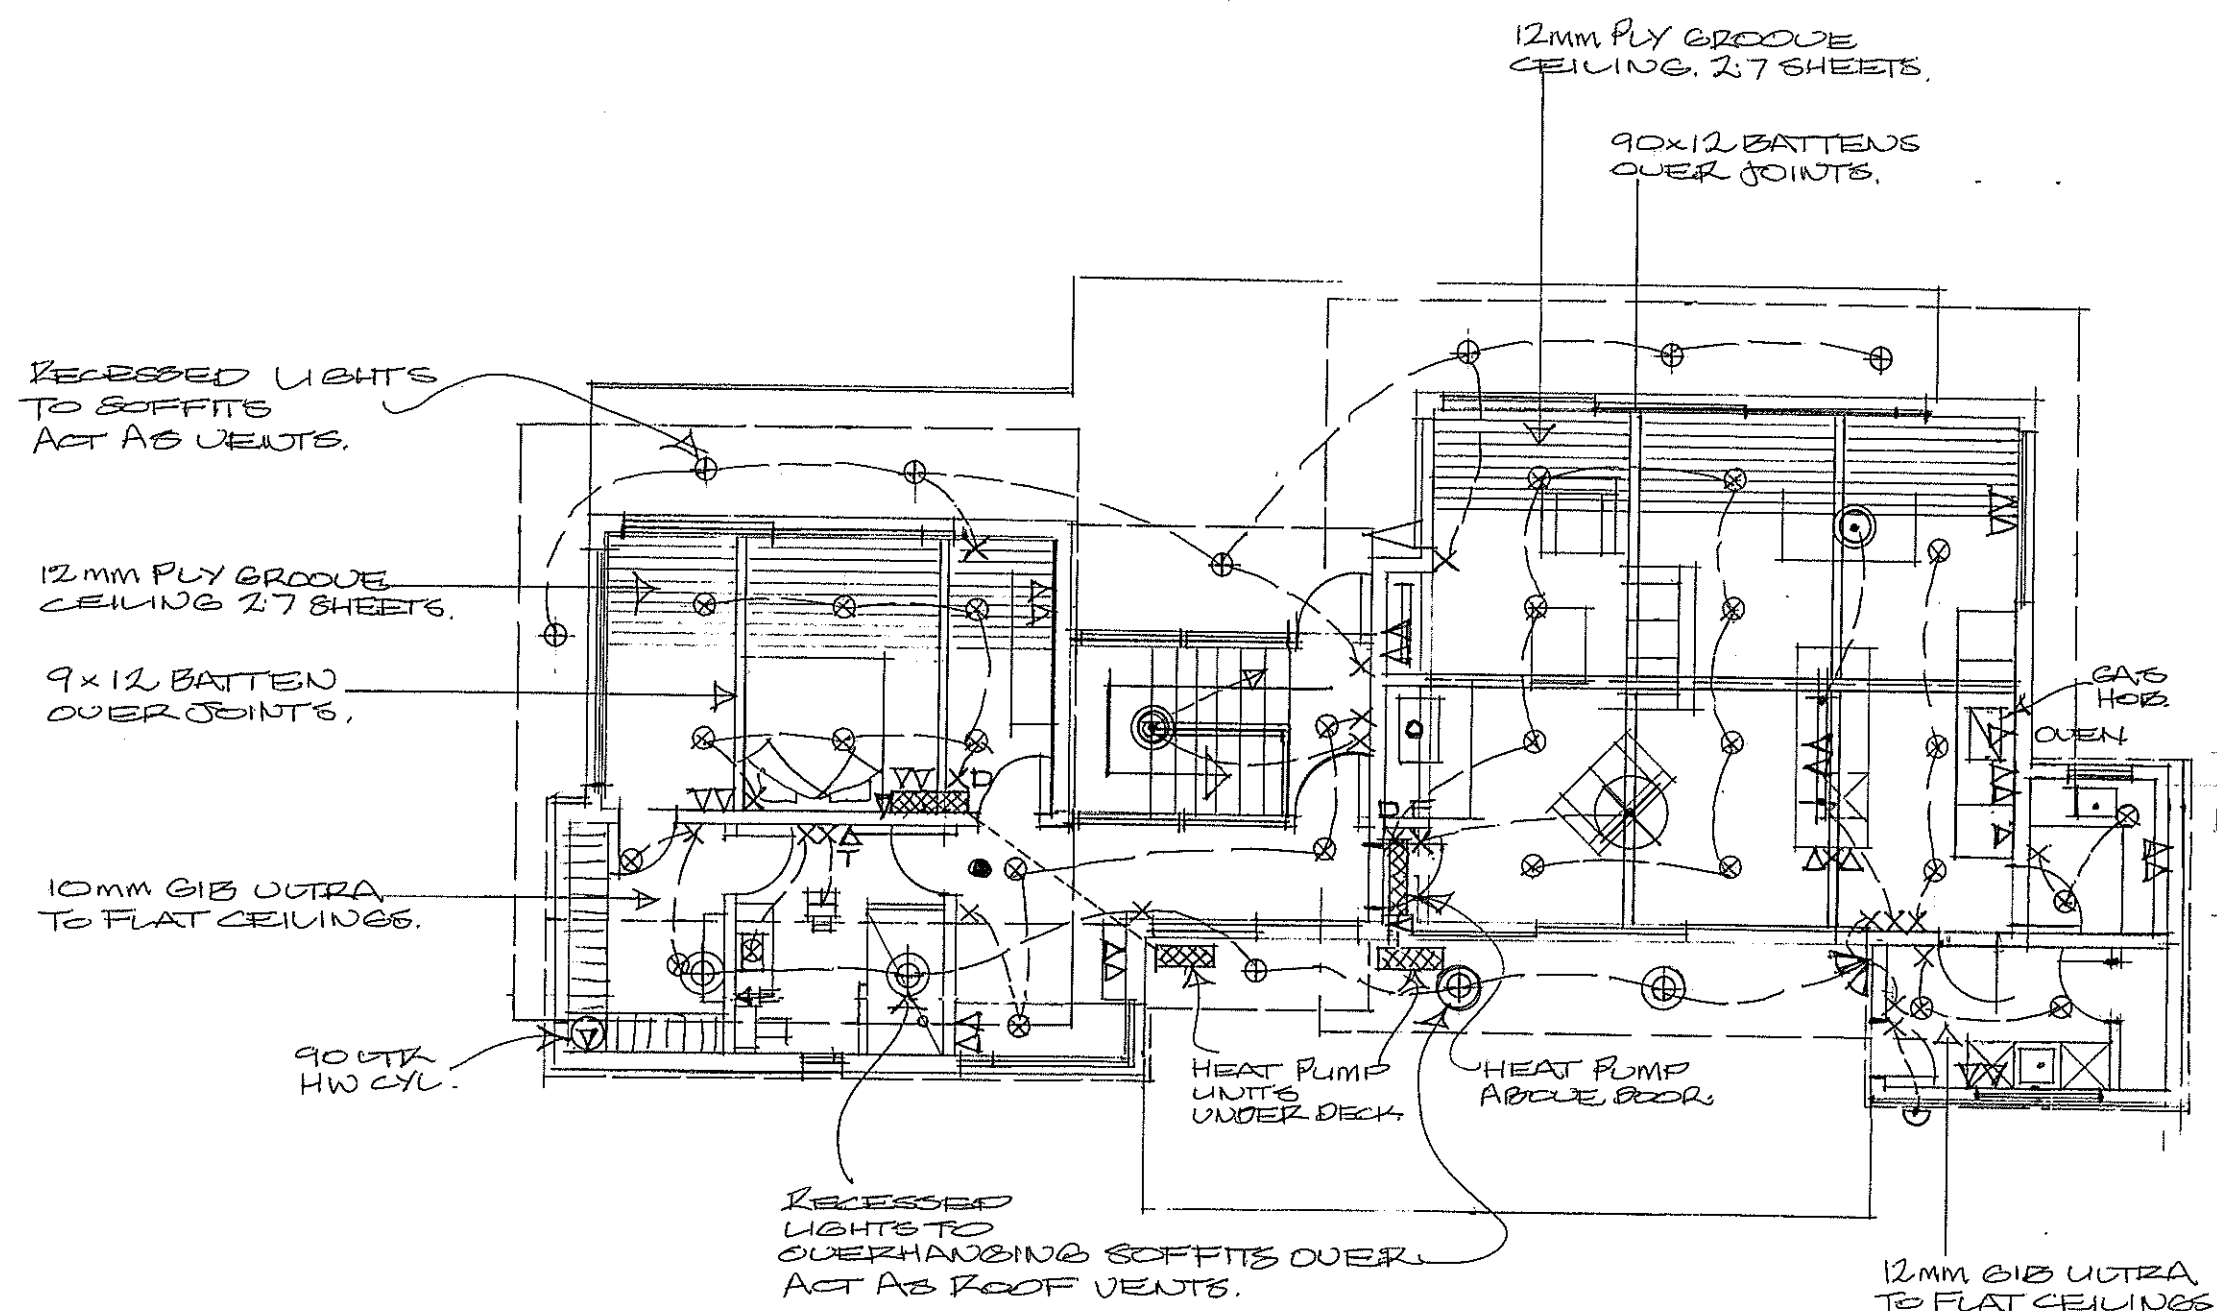


GROUND FLOOR PLAN	1:50 A1.
ELECTRICAL LAYOUT.	1:100 A3.

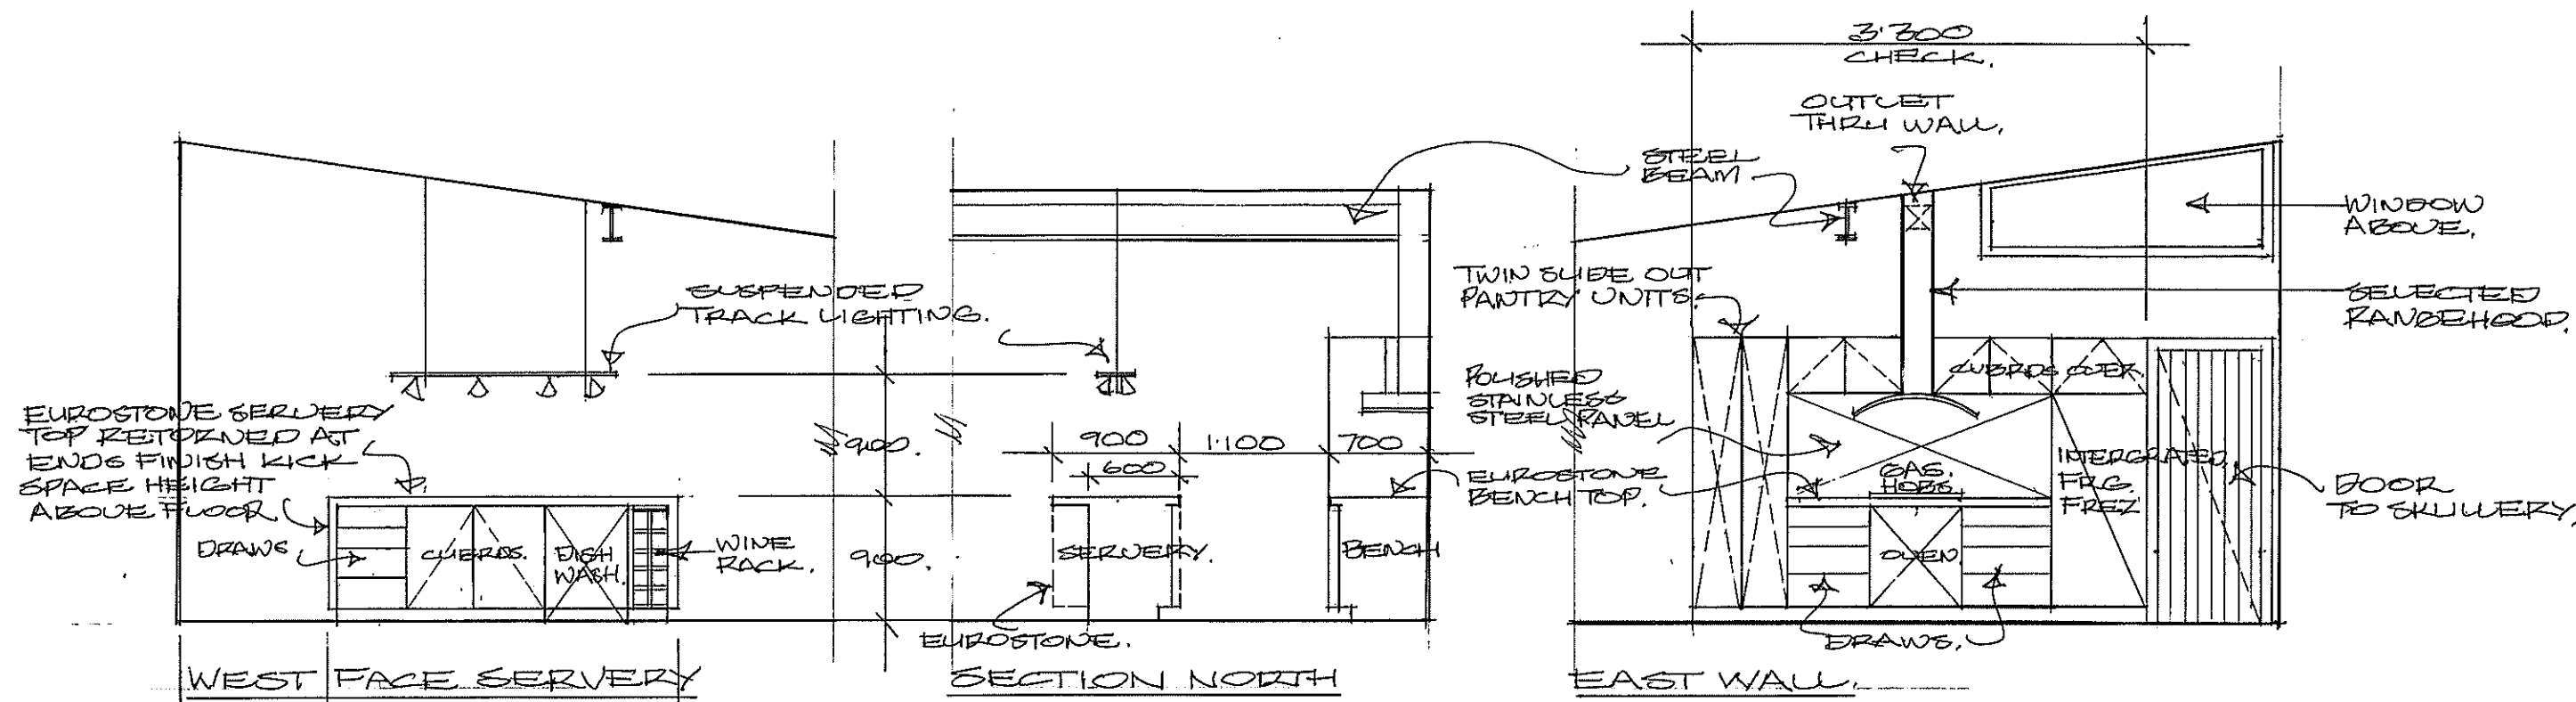

KITCHEN DETAILS.

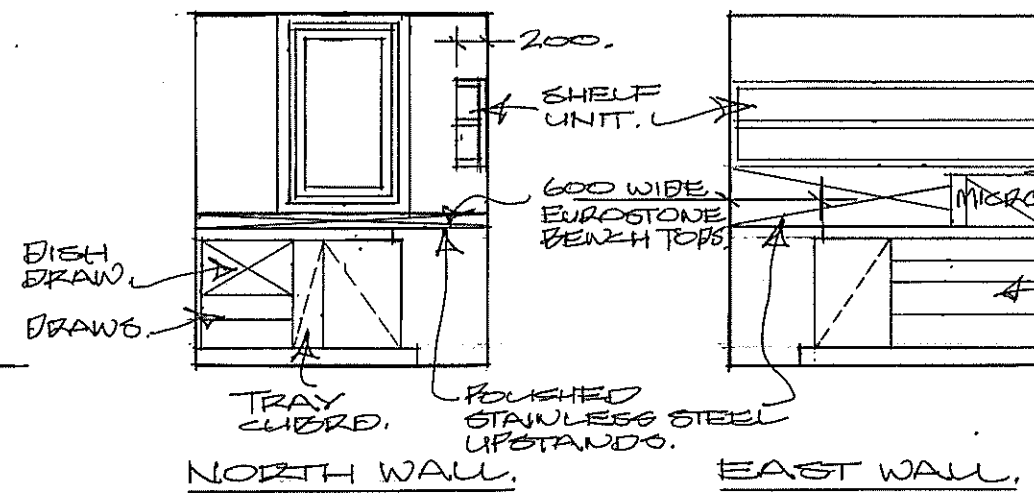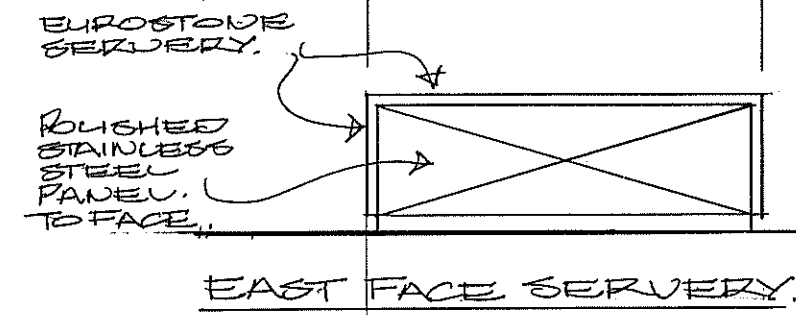

SKULLERY DETAILS

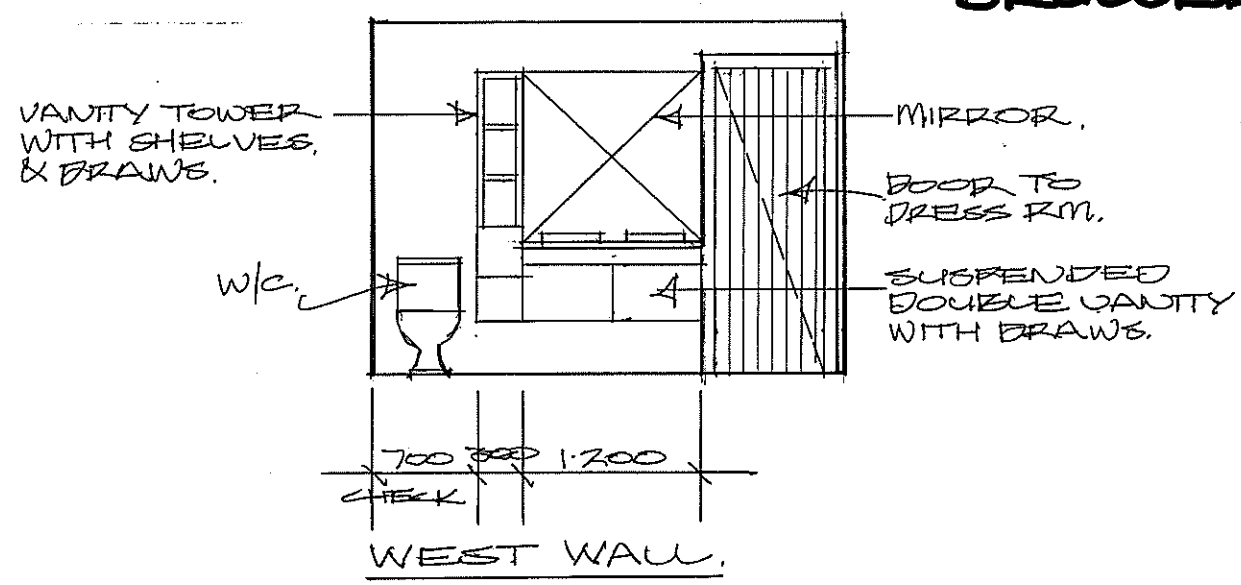

NOTE:-
ALL KITCHEN & BATH RM. FITTINGS TO BE SUPPLIED BY THE OWNERS, BUILDER TO ALLOW FOR INSTALLATION & FITTING.

BATH RM DETAIL SCALES 1:25 A1 1:50 A3.

- NOTES:
1. All work is to comply with NZS 3604, The N.Z. Building Code, regulations and associated documents.
 2. Contractor to check all dimensions, heights, structure set outs, drains and levels prior to start on site, before and during construction.
 3. All materials specified or selected to be fixed in strict accordance with manufacturers specifications warranties and BRANZ appraisals and by licensed applicators.
 4. All work to be carried out to best trade practice.

© COPYRIGHT of The Little Design Company Ltd
AMENDMENTS:

LITTIN, LITTLE & ASSOCIATES
ARCHITECTURE & INTERIOR DESIGN

The Little Design Company Ltd
PO Box 104 009, Auckland 1230
295 Lincoln Road, Waitakere City, Auckland
P: 09-838-6744, F: 09-838-6755, M: 0274-144-657
Email: real.littledesign@gmail.com

PROJECT:
PROPOSED
NEW RESIDENCE
FOR
MR & MRS M GOLDSMITH
AT
193 CULLEN RD
WAIPU

DRAWING TITLE:
KITCHEN
BATH RM
DETAILS.

DATE: NOVEMBER 2014
SCALES: 1:25 A1 1:50 A3.
JOB NO.119
DRAWING NO. OF